

# OAB REDEVELOPMENT, NLSIU, BENGALURU-TENDER STAGE DRAWINGS (NOT FOR CONSTRUCTION)

LIST OF DRAWINGS:

• MEP DRAWINGS:

Electrical Drawings - LIGHTING LAYOUT:

- |    |                 |  |
|----|-----------------|--|
| 1. | TD-E-LTG-201    | Lower Ground Floor Lighting Layout         |
| 2. | TD-E-LTG-202    | Ground Floor Lighting Layout               |
| 3. | TD-E-LTG-203    | First Floor Lighting Layout                |
| 4. | TD-E-LTG-204    | Second Floor Lighting Layout               |
| 5. | TD-E-LTG-205    | Third, Fourth, Fifth Floor Lighting Layout |
| 6. | TD-E-LTG-DB-201 | DB Details                                 |

Electrical Drawings - POWER LAYOUT:

- |     |                 |   |
|-----|-----------------|---|
| 7.  | TD-E-PWR-201    | Lower Ground Floor Power Layout         |
| 8.  | TD-E-PWR-202    | Ground Floor Power Layout               |
| 9.  | TD-E-PWR-203    | First Floor Power Layout                |
| 10. | TD-E-PWR-204    | Second Floor Power Layout               |
| 11. | TD-E-PWR-205    | Third, Fourth, Fifth Floor Power Layout |
| 12. | TD-E-PWR-DB-201 | DB Details                              |
| 13. | TD-E-PWR-DB-202 | DB Details                              |

Electrical Drawings - FLOOR RACEWAY LAYOUT :

- |     |              |   |
|-----|--------------|---|
| 14. | TD-E-FRW-201 | Ground Floor - Floor Raceway Layout         |
| 15. | TD-E-FRW-202 | First Floor - Floor Raceway Layout          |
| 16. | TD-E-FRW-203 | Second Floor - Floor Raceway Layout         |
| 17. | TD-E-FRW-204 | Third, Fourth, Fifth - Floor Raceway Layout |

Electrical Drawings - CEILING RACEWAY LAYOUT:

- |     |              |  |
|-----|--------------|--|
| 18. | TD-E-CRW-201 | Lower Ground Floor Ceiling Raceway Layout        |
| 19. | TD-E-CRW-202 | Ground Floor Ceiling Raceway Layout              |
| 20. | TD-E-CRW-203 | First Floor Ceiling Raceway Layout               |
| 21. | TD-E-CRW-204 | Second Floor Ceiling Raceway Layout              |
| 22. | TD-E-CRW-205 | Third, Fourth, Fifth Floor Ceiling Raceway Layou |

Electrical Drawings - SOLAR LAYOUT :

- |     |              |                              |
|-----|--------------|------------------------------|
| 23. | TD-E-SLR-201 | Terrace Floor - Solar Layout |
|-----|--------------|------------------------------|

Electrical Drawings - CCTV :

- |     |               |  |
|-----|---------------|--|
| 24. | TD-E-CCTV-201 | Lower Ground Floor CCTV Layout           |
| 25. | TD-E-CCTV-202 | Ground Floor CCTV Layout                 |
| 26. | TD-E-CCTV-203 | First Floor CCTV Layout                  |
| 27. | TD-E-CCTV-204 | Second Floor CCTV Layout                 |
| 28. | TD-E-CCTV-205 | Third Floor CCTV Layout                  |
| 29. | TD-E-CCTV-206 | Fourth, Fifth, Terrace Floor CCTV Layout |

CLIENT	:	NLSIU Gnana Bharathi Main Rd, opp. NAAC, Teachers Colony, Naagarabhaavi, Bengaluru, Karnataka 560072
CONSULTING ARCHITECT	:	Design Cooperative (DCOOP Architects) Unit No. 109, 1st Floor,Swastik Chambers, S.G.Barve Marg,Chembur, Mumbai-400071 PH: +91 22 3515 4031 Email: mail@dcoop.in
STRUCTURAL CONSULTANT	:	Manjunath & Co. Consulting engineers #236, 5th Cross, K.G.Nagar, Bangalore - 19 PH: (080)6616610, 6616611 Email: manjaxe2010@gmail.com
MEP CONSULTANT	:	<b>Mc D Built Environment Research Laboratory Pvt Ltd,</b> Green building,Sustainability and MEP services, No 12,Subramanya Arcade, Tower B , Opposite to Jalbhavan, Old Gurappanapalya, BTM 1st stage ,Bannerghтта road ,Bangalore-560 029. PH: +91 80 41222020, URL: www.mcdberl.com
SUSTAINABILITY CONSULTANT	:	Mc D Built Environment Research Laboratory Pvt Ltd, Green building,Sustainability and MEP services, No 12,Subramanya Arcade, Tower B , Opposite to Jalbhavan, Old Gurappanapalya, BTM 1st stage ,Bannerghтта road ,Bangalore-560 029. PH: +91 80 41222020, URL: www.mcdberl.com




 

 








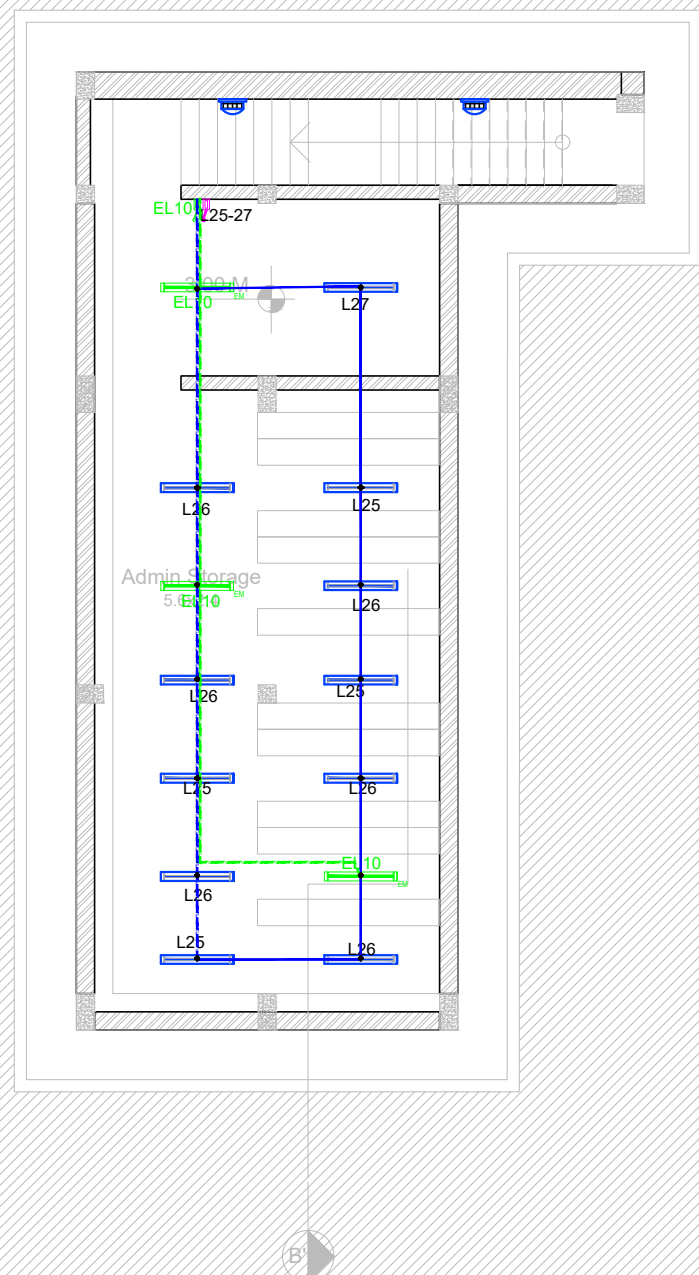






 

 
# **ELECTRICAL TENDER DRAWINGS - LIGHTING LAYOUT**

**OAB REDEVELOPMENT, NLSIU, BENGALURU**

Dec 2024






TYPE	DESCRIPTION	CCT
	20W 9000M SUSPENDED LINEAR LIGHT FIXTURE	5700K
	20W 1200MM SUSPENDED LINEAR LIGHT FIXTURE	5700K
	30W 1800MM SUSPENDED LINEAR LIGHT FIXTURE	5700K
	20W 1200MM SUSPENDED LINEAR LIGHT FIXTURE	5700K
	20W 60° BEAM ANGLE SUSPENDED CYLINDRICAL LIGHT FIXTURE	5700K
	20W SUSPENDED BATTEN LIGHT FIXTURE	5700K
	20W 60° BEAM ANGLE SUSPENDED CYLINDRICAL LIGHT FIXTURE	5700K
	12W MIRROR LIGHT FIXTURE	5700K
	15W BULK HEAD LIGHT FIXTURE	5700K
	30W 6000M DIA RING LIGHT FIXTURE	5700K
	18W DOWN LIGHT FIXTURE	5700K
	30W LIGHT FIXTURE DOUBLE HEIGHT	5700K
	6W LIGHT FIXTURE	5700K
	6W DOWN LIGHT FIXTURE	5700K
	30W LIGHT FIXTURE IP RATED	5700K
	30W 350X350MM LIGHT FIXTURE	5700K
	35W 1200MM DIA CEILING FAN	
	35W 900MM DIA CEILING FAN	
	1200MM WALL MOUNTED FAN	
	FAN REGULATOR	
	6A SINGLE POLE SWITCH(NORMAL)	
	6A SINGLE POLE SWITCH(EMERGENCY)	

DWG NO : TD-E-LTG-201

This drawing is the property of Mc D Built environment research laboratory Pvt Ltd, no part of the drawing may be reproduced in any manner whatsoever without permission from McD berl Pvt Ltd.



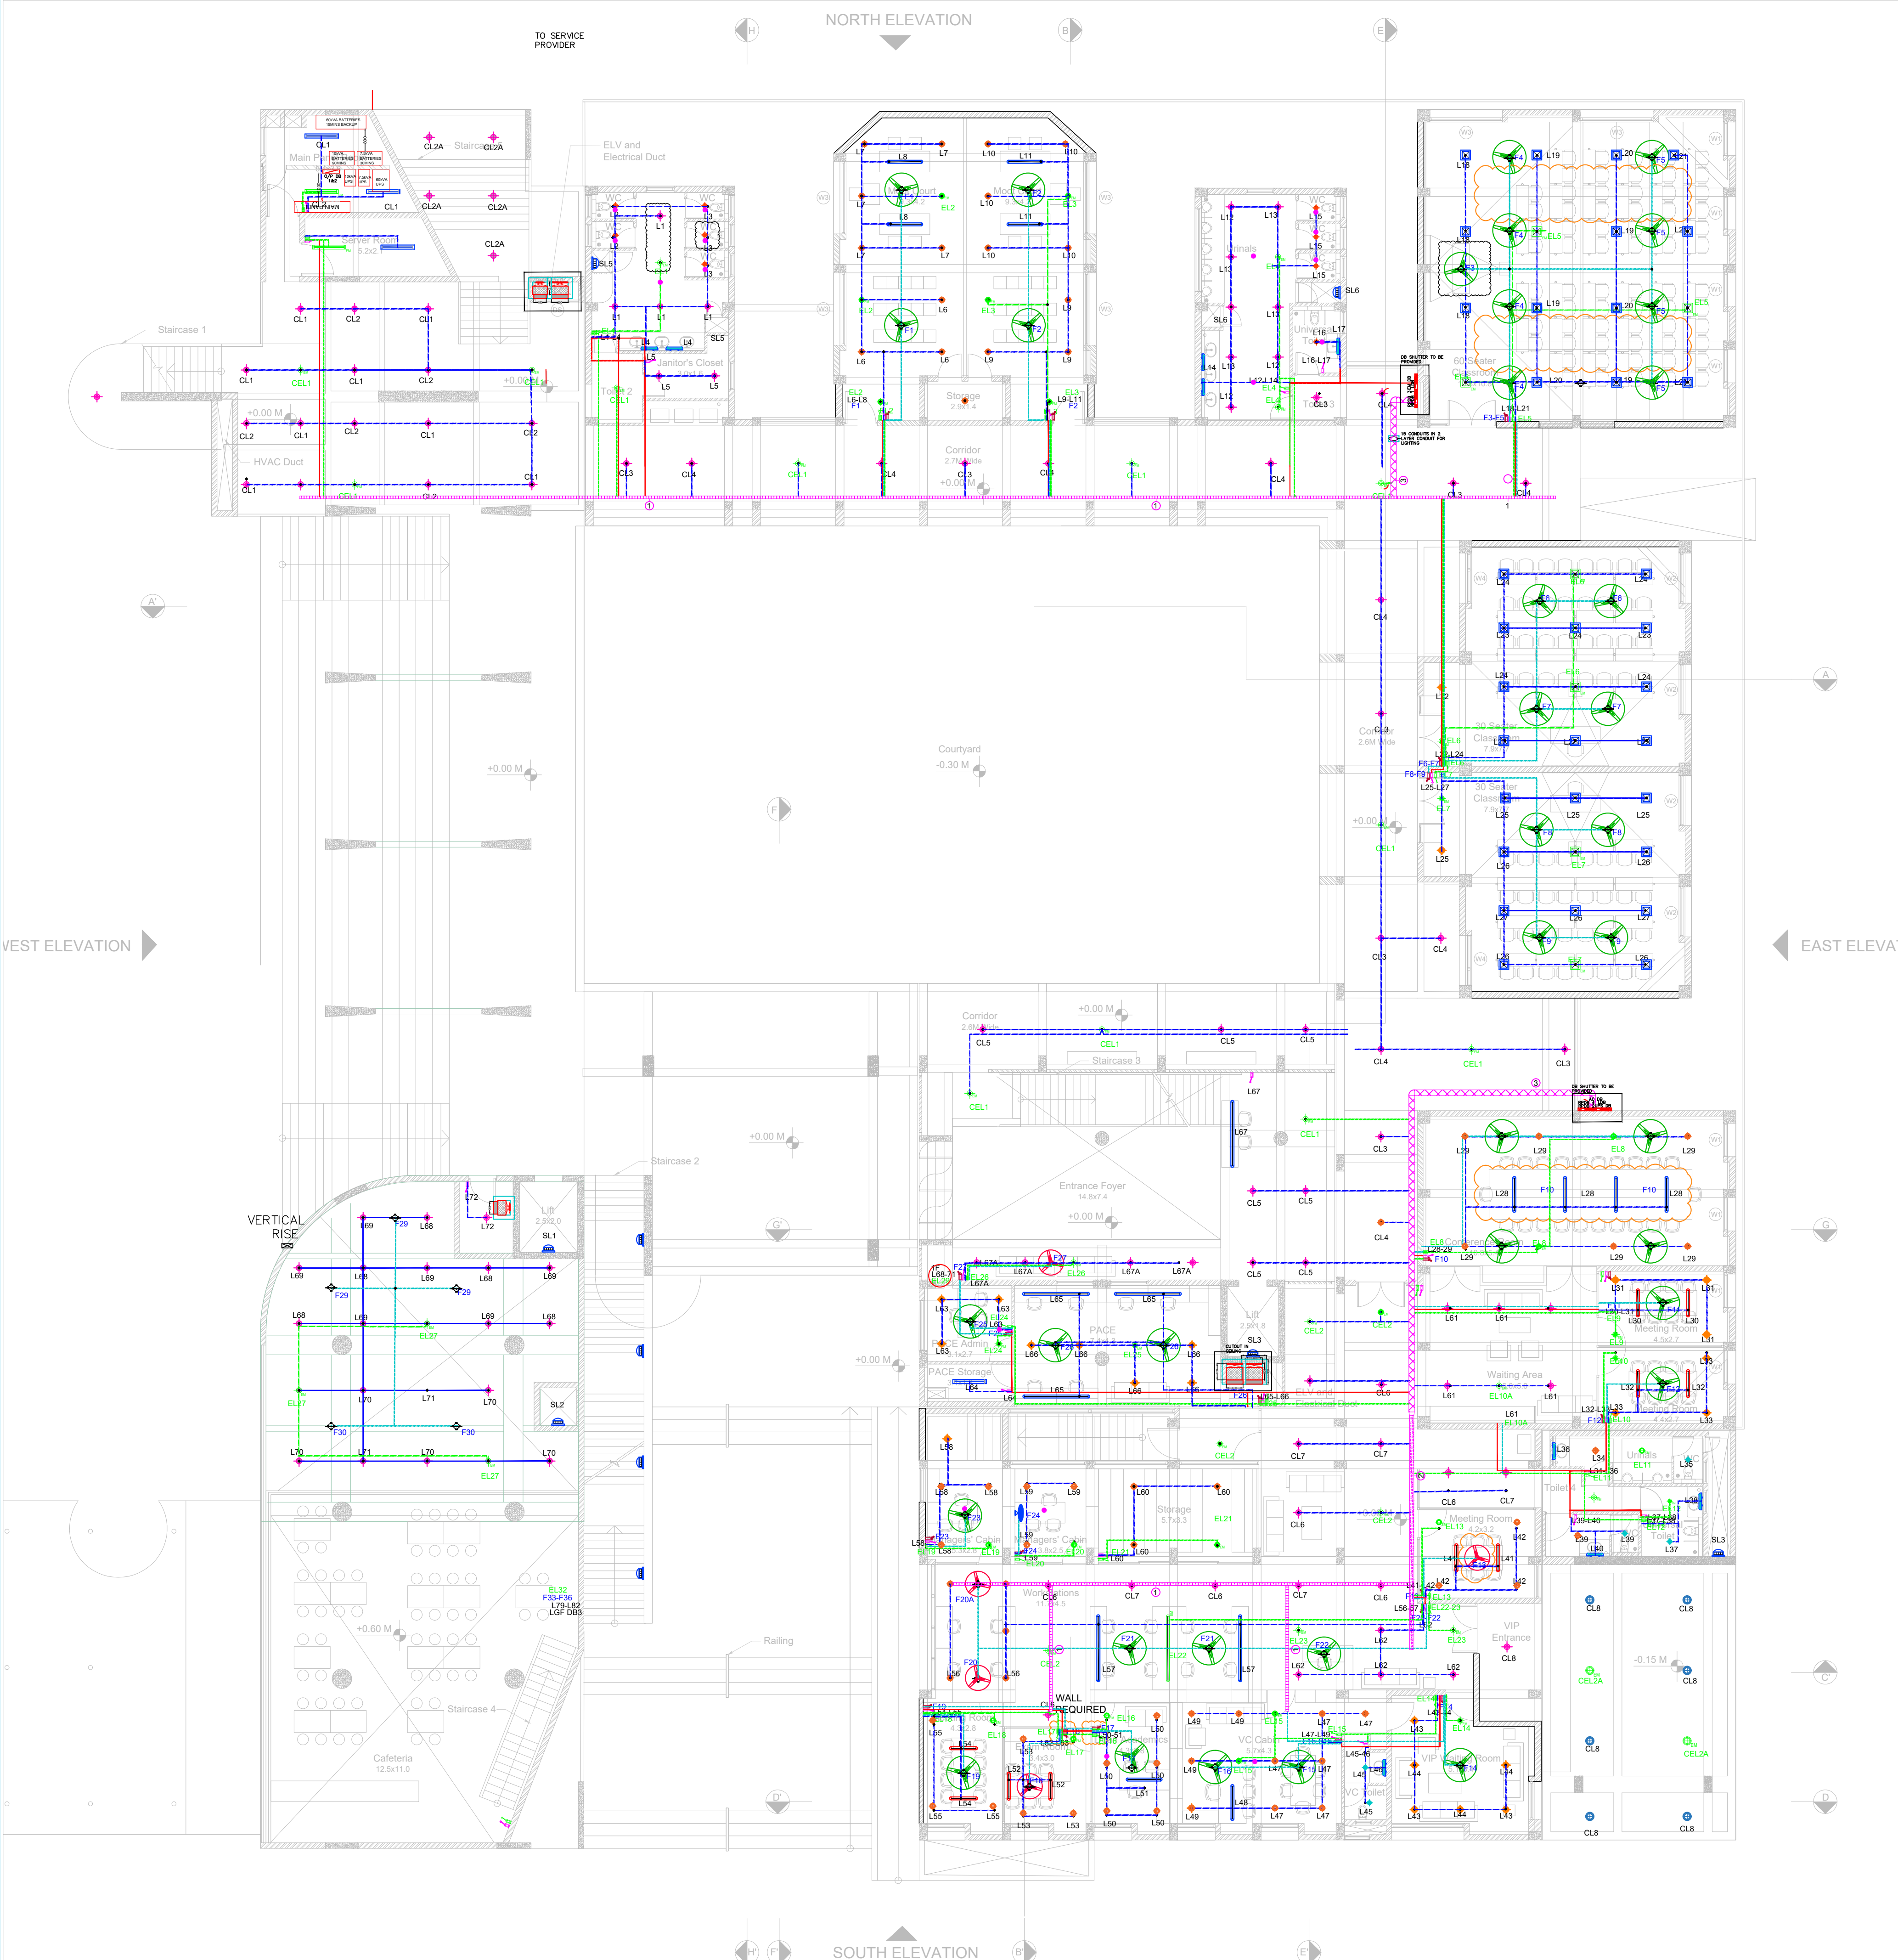

TYPE	DESCRIPTION	CCT
	20W 900MM SUSPENDED LINEAR LIGHT FIXTURE	5700K
	20W 1200MM SUSPENDED LINEAR LIGHT FIXTURE	5700K
	30W 1800MM SUSPENDED LINEAR LIGHT FIXTURE	5700K
	20W 1200MM SUSPENDED LINEAR LIGHT FIXTURE	5700K
	20W 60° BEAM ANGLE SUSPENDED CYLINDRICAL LIGHT FIXTURE	5700K
	20W SUSPENDED BATTEN LIGHT FIXTURE	5700K
	20W 60° BEAM ANGLE SUSPENDED CYLINDRICAL LIGHT FIXTURE	5700K
	12W MIRROR LIGHT FIXTURE	5700K
	15W BULK HEAD LIGHT FIXTURE	5700K
	30W 600MM DIA RING LIGHT FIXTURE	5700K
	18W DOWN LIGHT FIXTURE	5700K
	30W LIGHT FIXTURE DOUBLE HEIGHT	5700K
	6W LIGHT FIXTURE	5700K
	6W DOWN LIGHT FIXTURE	5700K
	30W LIGHT FIXTURE IP RATED	5700K
	30W 350X350MM LIGHT FIXTURE	5700K
	35W 1200MM DIA CEILING FAN	
	35W 900MM DIA CEILING FAN	
	1200MM WALL MOUNTED FAN	
	FAN REGULATOR	
	6A SINGLE POLE SWITCH(NORMAL)	
	6A SINGLE POLE SWITCH(EMERGENCY)	

KEYPLAN :-

ISSUALS

R0

TENDER\_STAGE

11.12.2024

RS

REVISIONS

OWNER'S NAME :-

CLIENT :-

NLSIU BENGALURU

PROJECT ARCHITECT:-  
DCOOP  
ARCHITECTURE.DESIGN.RESEARCH  
UNIT NO. 109, 1ST FLOOR, SWASTIK CHAMBERS,  
SG BARVE ROAD, CHEMBUR, MUMBAI - 400071  
PH: 24706945/46 E-MAIL: mail@dcop.in

OFFICE SEAL :-

MEP & SUSTAINABILITY CONSULTANT :-  
  
Mc D Built Environment Research Laboratory Pvt Ltd,  
Green building,Sustainability and MEP services,  
No 12,Subramanya Arcade, Tower B, Opposite to Jalbhavan, Old  
Gurappanapalya, BTM 1st stage, Bannerghita road ,Bangalore-560 029.  
Ph:+91 80 41222020,URL: www.mcdberl.com

PROJECT TITLE :-  
NLSIU BENGALURU

TENDER STAGE

DRAWING TITLE :-  
GROUND FLOOR LIGHTING  
LAYOUT

PHASE	:	BLOCK	:	SCALE	:			
DESIGNED	:	RS	:	DATE	:	11.12.2024	:	1:125
DRAWN	:	RS	:	APPROVED	:	MEGHANA	:	REV NO:
CHECKED	:	MEGHANA	:	SHEET	:	A1	:	R1

DWG NO : TD-E-LTG-202  
This drawing is the property of Mc D Built environment research laboratory Pvt Ltd, no part of the drawing may be reproduced in any manner whatsoever without permission from McD berl Pvt Ltd.





TYPE	DESCRIPTION	CCT
	20W 900MM SUSPENDED LINEAR LIGHT FIXTURE	5700K
	20W 1200MM SUSPENDED LINEAR LIGHT FIXTURE	5700K
	30W 1800MM SUSPENDED LINEAR LIGHT FIXTURE	5700K
	20W 1200MM SUSPENDED LINEAR LIGHT FIXTURE	5700K
	20W 60° BEAM ANGLE SUSPENDED CYLINDRICAL LIGHT FIXTURE	5700K
	20W SUSPENDED BATTEN LIGHT FIXTURE	5700K
	20W 60° BEAM ANGLE SUSPENDED CYLINDRICAL LIGHT FIXTURE	5700K
	12W MIRROR LIGHT FIXTURE	5700K
	15W BULK HEAD LIGHT FIXTURE	5700K
	30W 600MM DIA RING LIGHT FIXTURE	5700K
	18W DOWN LIGHT FIXTURE	5700K
	30W LIGHT FIXTURE DOUBLE HEIGHT	5700K
	6W LIGHT FIXTURE	5700K
	6W DOWN LIGHT FIXTURE	5700K
	30W LIGHT FIXTURE IP RATED	5700K
	30W 350X350MM LIGHT FIXTURE	5700K
	35W 1200MM DIA CEILING FAN	
	35W 900MM DIA CEILING FAN	
	1200MM WALL MOUNTED FAN	
	FAN REGULATOR	
	6A SINGLE POLE SWITCH(NORMAL)	
	6A SINGLE POLE SWITCH(EMERGENCY)	

KEYPLAN :-

ISSUALS

R0

TENDER STAGE

11.12.2024

RS

REVISIONS

OWNER'S NAME :-

CLIENT :-

NLSIU BENGALURU

PROJECT ARCHITECT:-  
DCOOP  
ARCHITECTURE.DESIGN.RESEARCH  
UNIT NO. 109, 1ST FLOOR, SWASTIK CHAMBERS,  
SG BARVE ROAD, CHEMBUR, MUMBAI - 400071  
PH: 24706945/46 E-MAIL: mail@dcop.in

OFFICE SEAL :-

MEP & SUSTAINABILITY CONSULTANT :-  
  
Mc D Built Environment Research Laboratory Pvt Ltd,  
Green building,Sustainability and MEP services,  
No 12,Subramanya Arcade, Tower B, Opposite to Jalbhavan, Old  
Gurappanapalya, BTM 1st stage ,Bannerghita road ,Bangalore-560 029.  
Ph:+91 80 41222020,URL: www.mcdberl.com

PROJECT TITLE :-

NLSIU BENGALURU

TENDER STAGE

DRAWING TITLE :-

FIRST FLOOR LIGHTING LAYOUT

PHASE	:	BLOCK	:	SCALE	:
DESIGNED	:	RS	:	DATE	:
DRAWN	:	RS	:	APPROVED	:
CHECKED	:	MEGHANA	:	SHEET	:

DWG NO : TD-E-LTG-203

This drawing is the property of Mc D Built environment research laboratory Pvt Ltd, no part of the drawing may be reproduced in any manner whatsoever without permission from McD berl Pvt Ltd.





TYPE	DESCRIPTION	CCT
	20W 900MM SUSPENDED LINEAR LIGHT FIXTURE	5700K
	20W 1200MM SUSPENDED LINEAR LIGHT FIXTURE	5700K
	30W 1800MM SUSPENDED LINEAR LIGHT FIXTURE	5700K
	20W 1200MM SUSPENDED LINEAR LIGHT FIXTURE	5700K
	20W 60° BEAM ANGLE SUSPENDED CYLINDRICAL LIGHT FIXTURE	5700K
	20W SUSPENDED BATTEN LIGHT FIXTURE	5700K
	20W 60° BEAM ANGLE SUSPENDED CYLINDRICAL LIGHT FIXTURE	5700K
	12W MIRROR LIGHT FIXTURE	5700K
	15W BULK HEAD LIGHT FIXTURE	5700K
	30W 600MM DIA RING LIGHT FIXTURE	5700K
	18W DOWN LIGHT FIXTURE	5700K
	30W LIGHT FIXTURE DOUBLE HEIGHT	5700K
	6W LIGHT FIXTURE	5700K
	6W DOWN LIGHT FIXTURE	5700K
	30W LIGHT FIXTURE IP RATED	5700K
	30W 350X350MM LIGHT FIXTURE	5700K
	35W 1200MM DIA CEILING FAN	
	35W 900MM DIA CEILING FAN	
	1200MM WALL MOUNTED FAN	
	FAN REGULATOR	
	6A SINGLE POLE SWITCH(NORMAL)	
	6A SINGLE POLE SWITCH(EMERGENCY)	

KEYPLAN :-

ISSUALS

R0

TENDER STAGE

11.12.2024

RS

REVISIONS

OWNER'S NAME :-

CLIENT :-

NLSIU BENGALURU

PROJECT ARCHITECT:-  
DCOOP  
ARCHITECTURE.DESIGN.RESEARCH  
UNIT NO. 109, 1ST FLOOR, SWASTIK CHAMBERS,  
SG BARVE ROAD, CHEMBUR, MUMBAI - 400071  
PH: 24706945/46 E-MAIL: mail@dcloop.in

OFFICE SEAL :-

MEP & SUSTAINABILITY CONSULTANT :-  
  
Mc D Built Environment Research Laboratory Pvt Ltd,  
Green building,Sustainability and MEP services,  
No 12,Subramanya Arcade, Tower B , Opposite to Jalbhavan, Old  
Gurappanapalya, BTM 1st stage ,Bannerghita road ,Bangalore-560 029.  
Ph:+91 80 41222020,URL: www.mcdberl.com

PROJECT TITLE :-

NLSIU BENGALURU

TENDER STAGE




DRAWING TITLE :-

SECOND FLOOR LIGHTING  
LAYOUT

PHASE	:	BLOCK	:	SCALE	:			
DESIGNED	:	RS	:	DATE	:	11.12.2024	:	1:125
DRAWN	:	RS	:	APPROVED	:	MEGHANA	:	REV NO:
CHECKED	:	MEGHANA	:	SHEET	:	A1	:	R1

DWG NO : TD-E-LTG-204  
This drawing is the property of Mc D Built environment research laboratory Pvt Ltd, no part of the drawing may be reproduced in any manner whatsoever without permission from McD berl Pvt Ltd.



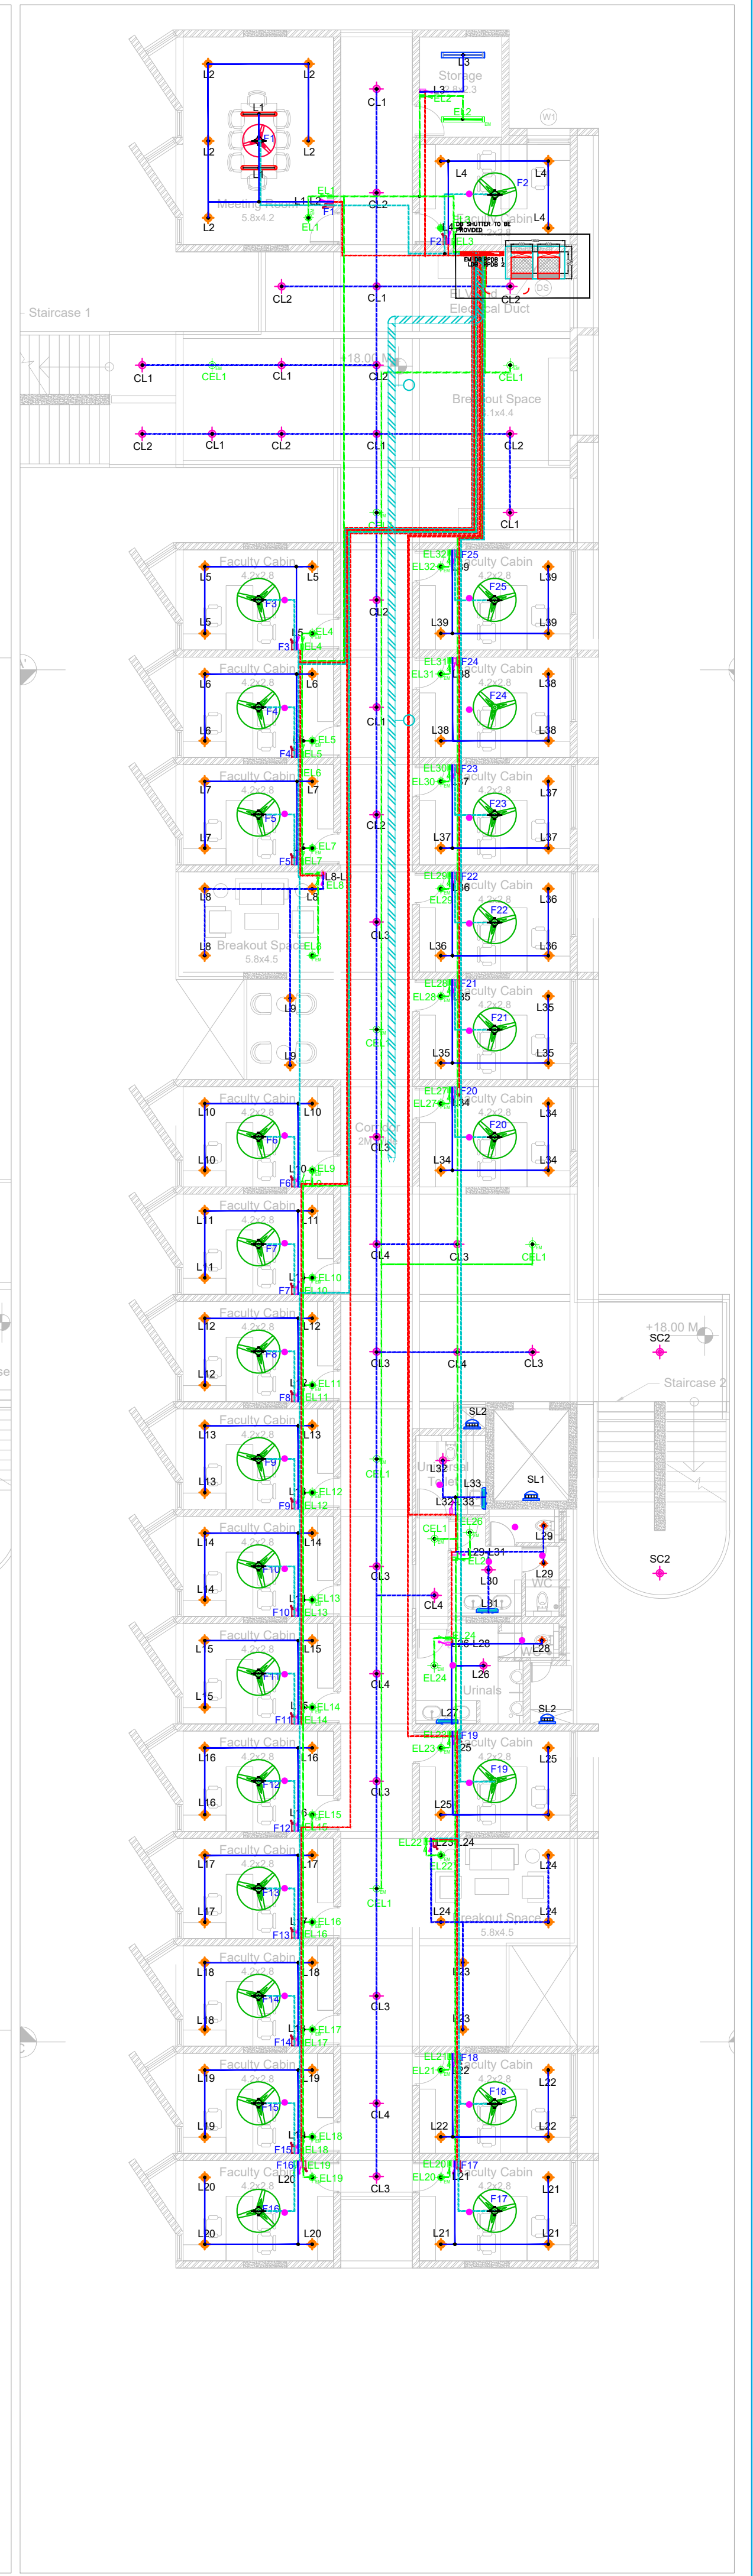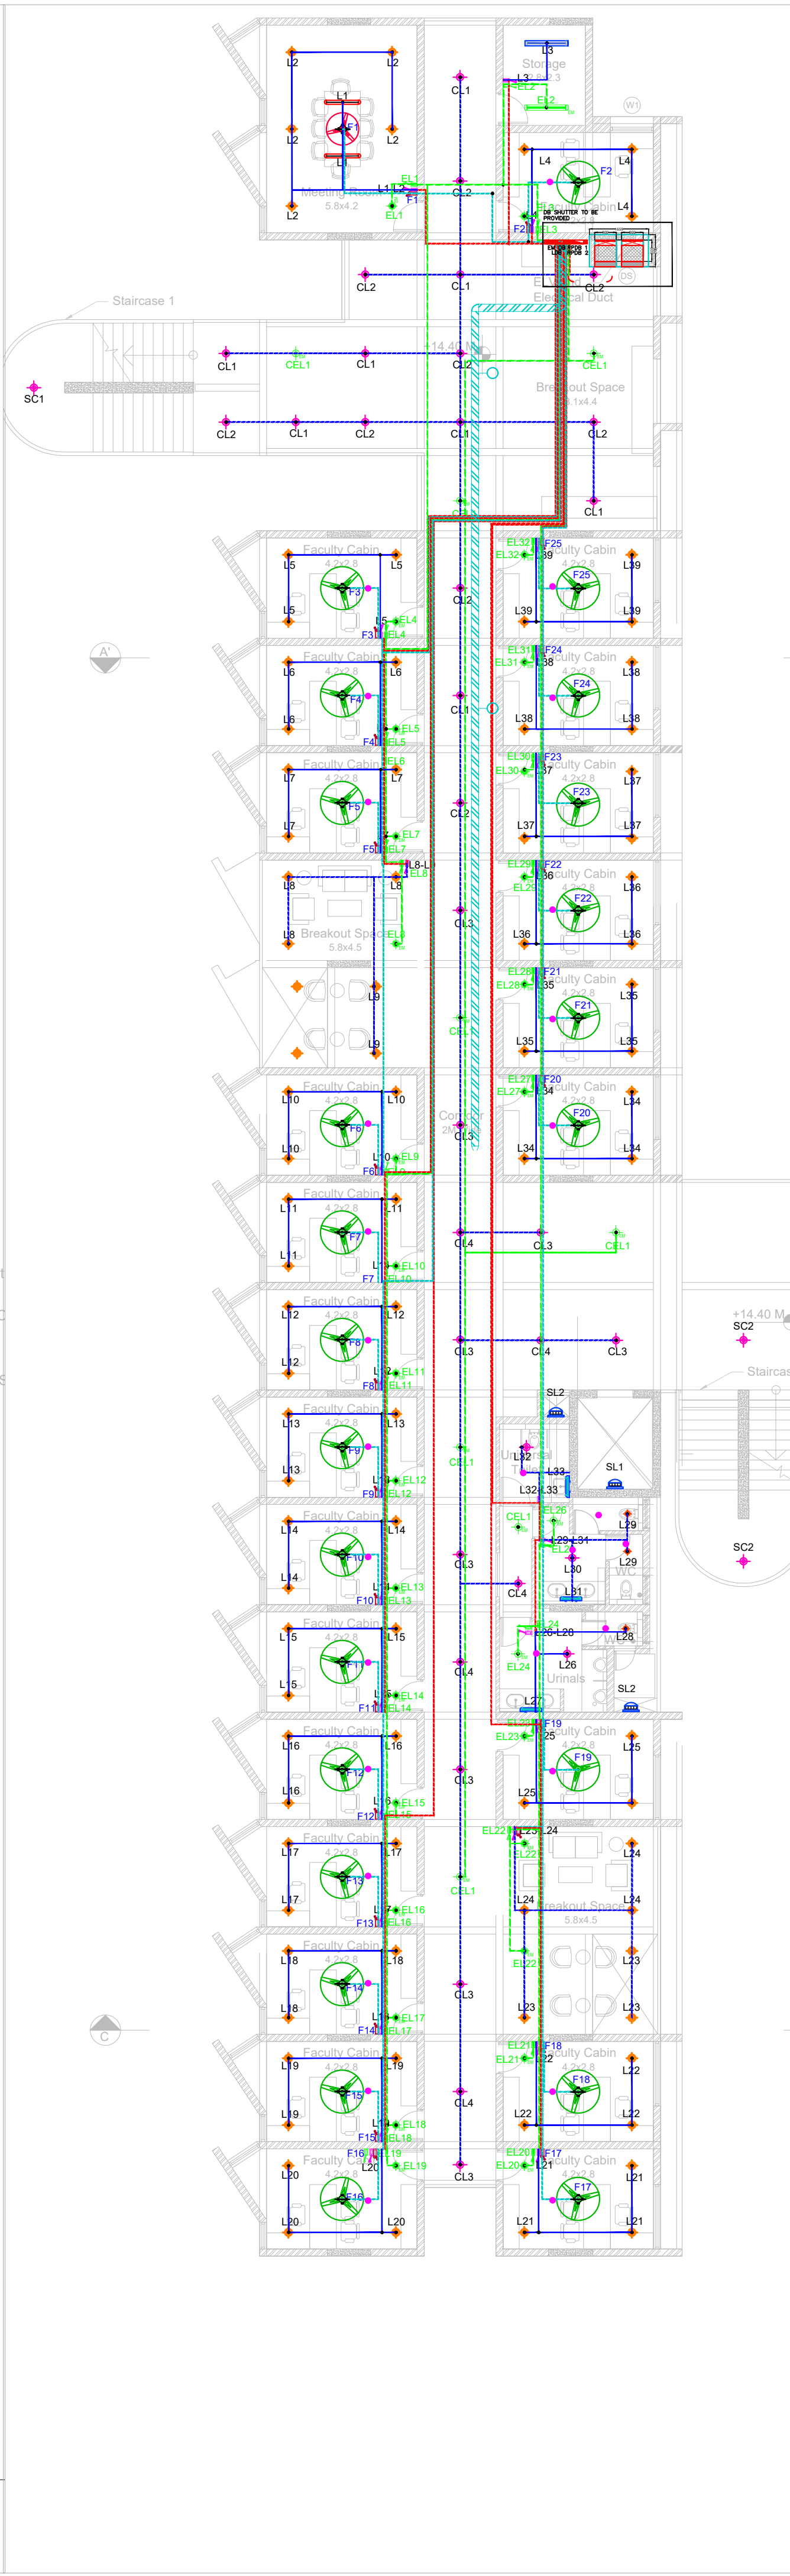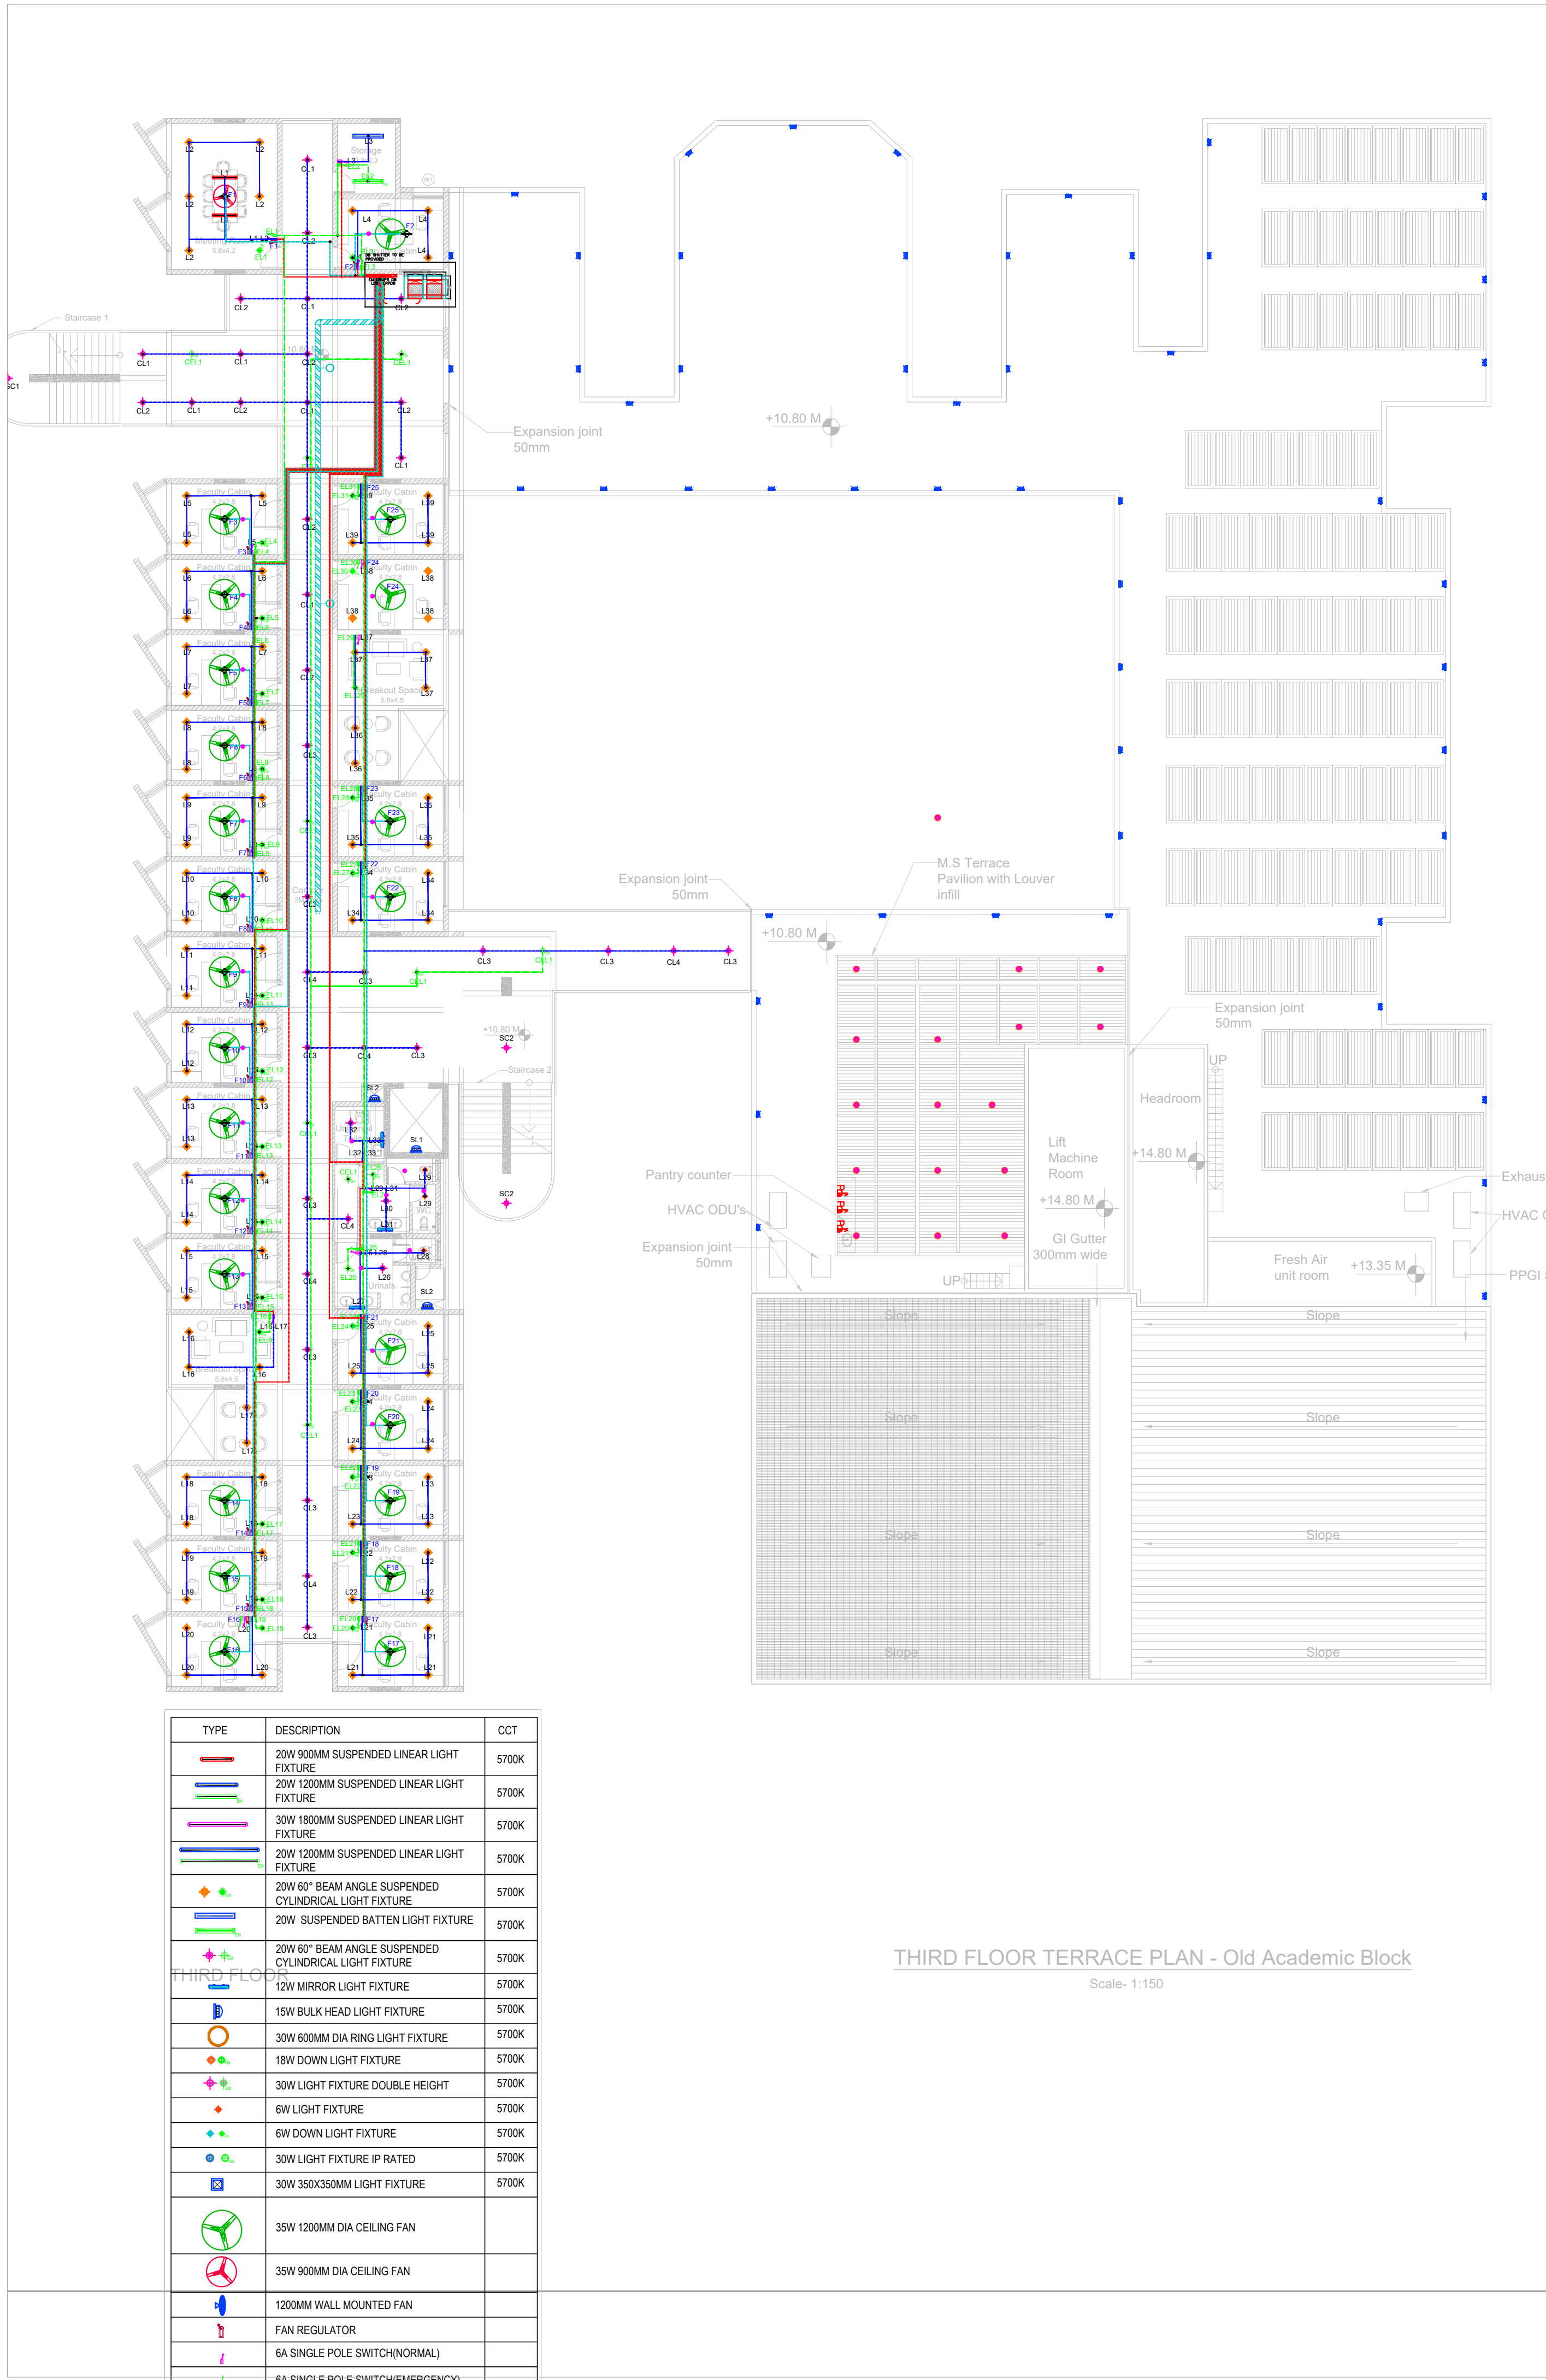

KEYPLAN :-

ISSUALS

R0

TENDER STAGE

11.12.2024

RS

REVISIONS

OWNER'S NAME :-

CLIENT :-

NLSIU BENGALURU

PROJECT ARCHITECT:-  
DCOOP  
ARCHITECTURE.DESIGN.RESEARCH  
UNIT NO. 109, 1ST FLOOR, SWASTIK CHAMBERS,  
SG BARVE ROAD, CHEMBUR, MUMBAI - 400071  
PH: 24706945/46 E-MAIL: mail@dcop.in

OFFICE SEAL :-

MEP & SUSTAINABILITY CONSULTANT :-  
  
Mc D Built Environment Research Laboratory Pvt Ltd,  
Green building,Sustainability and MEP services,  
No 12,Subramanya Arcade, Tower B , Opposite to Jalbhavan, Old  
Gurappanapalya, BTM 1st stage ,Bannerghita road ,Bangalore-560 029.  
Ph:+91 80 41222020,URL: www.mcdberl.com

PROJECT TITLE :-

NLSIU BENGALURU

TENDER STAGE

DRAWING TITLE :-

THIRD,FOURTH,FIFTH FLOOR  
LIGHTING LAYOUT

PHASE :  
DESIGNED : RS

BLOCK :  
DATE : 11.12.2024

SCALE :  
1:125

DRAWN : RS

APPROVED : MEGHANA

REV NO:

CHECKED : MEGHANA

SHEET : A1


R1

DWG NO : TD-E-LTG-205


This drawing is the property of Mc D Built environment research laboratory Pvt Ltd, no part of the drawing may be reproduced in any manner whatsoever without permission from McD berl Pvt Ltd.




LGF

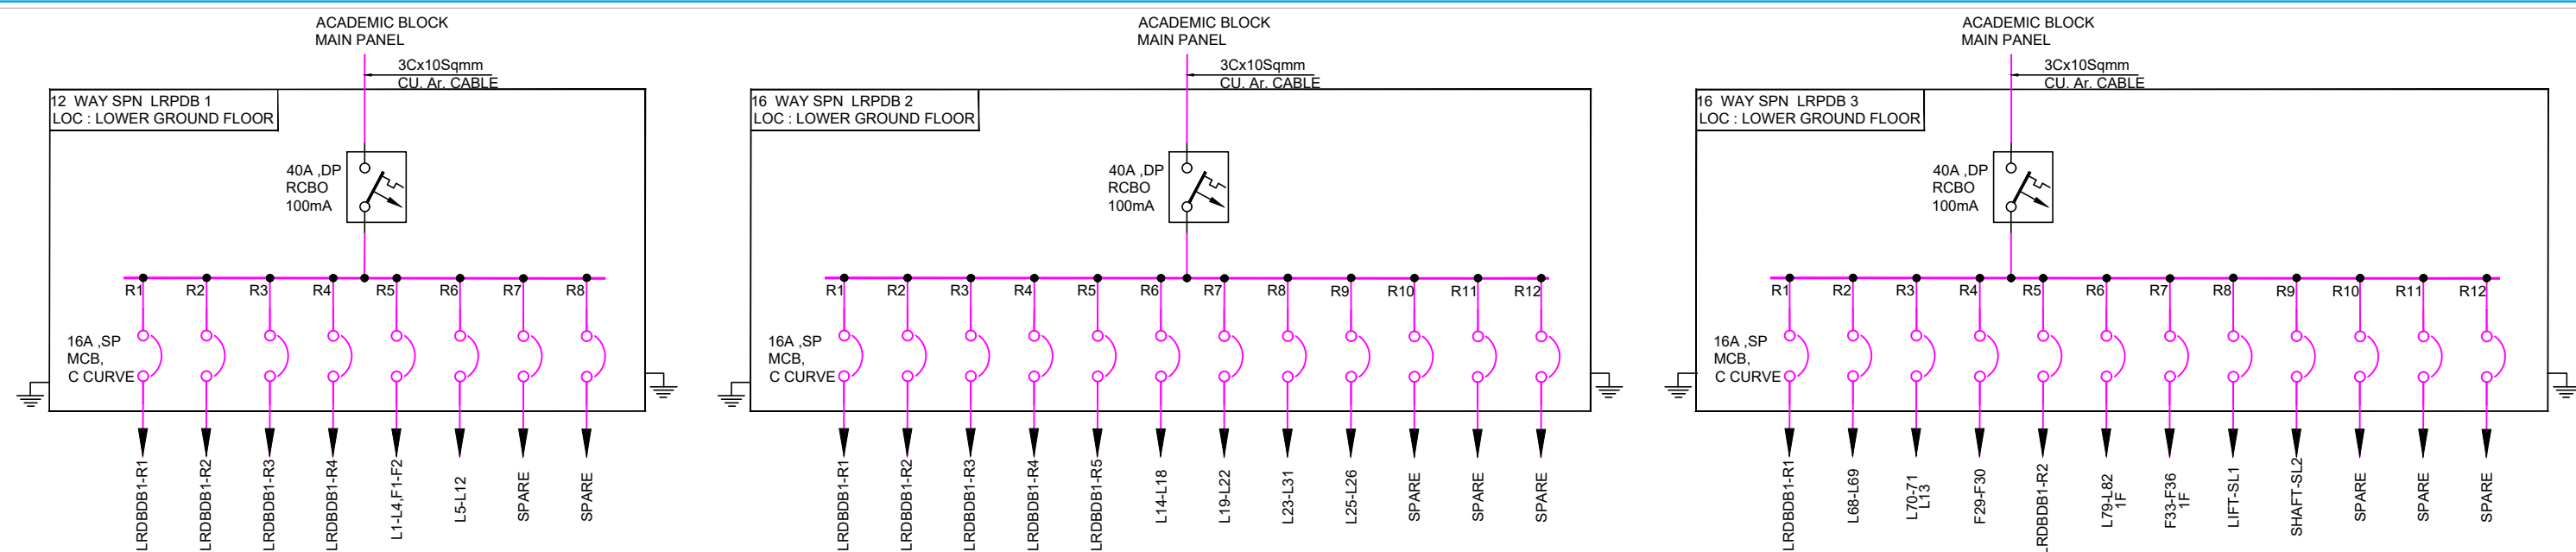


GF

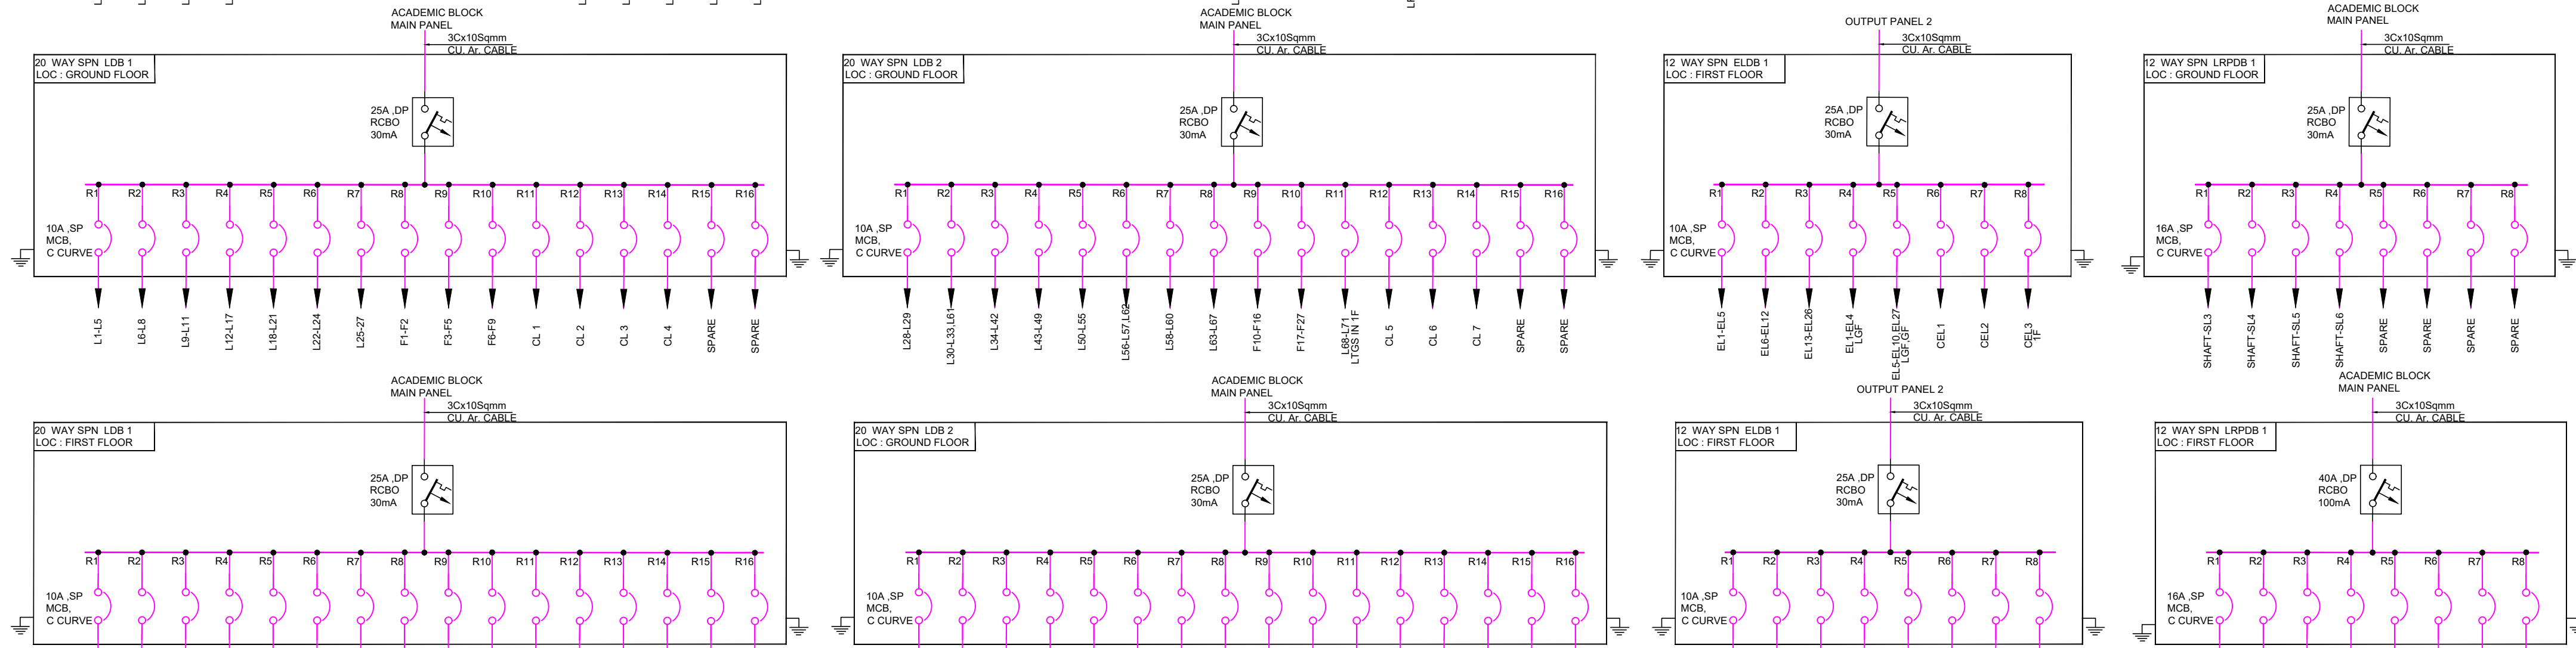


1F

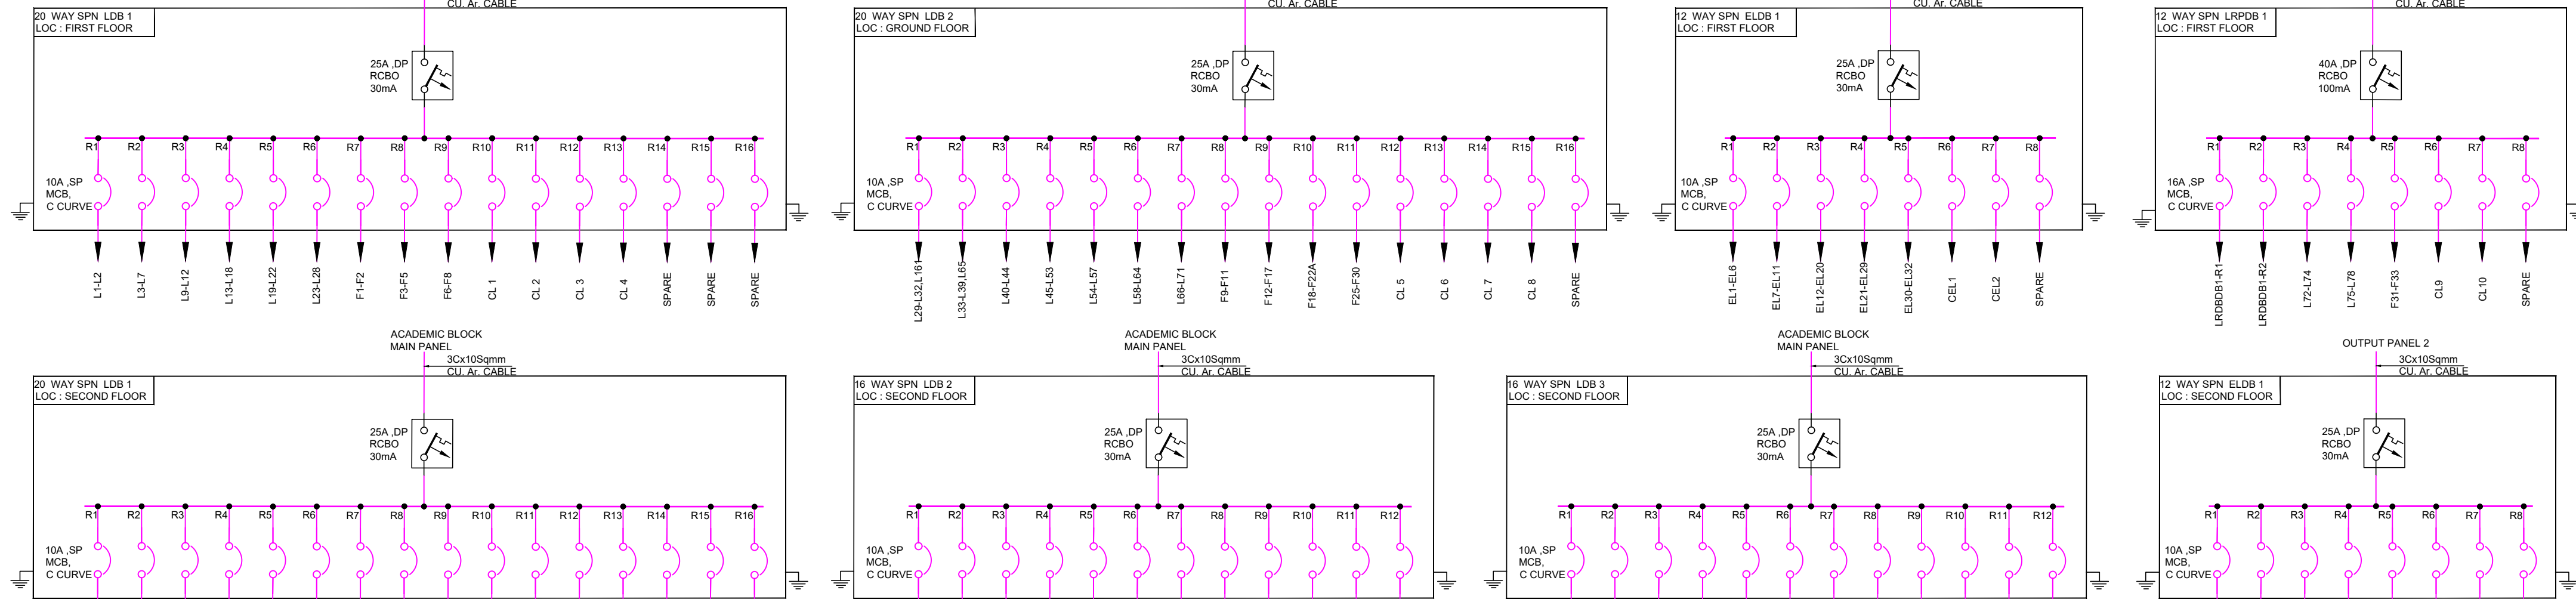


2F

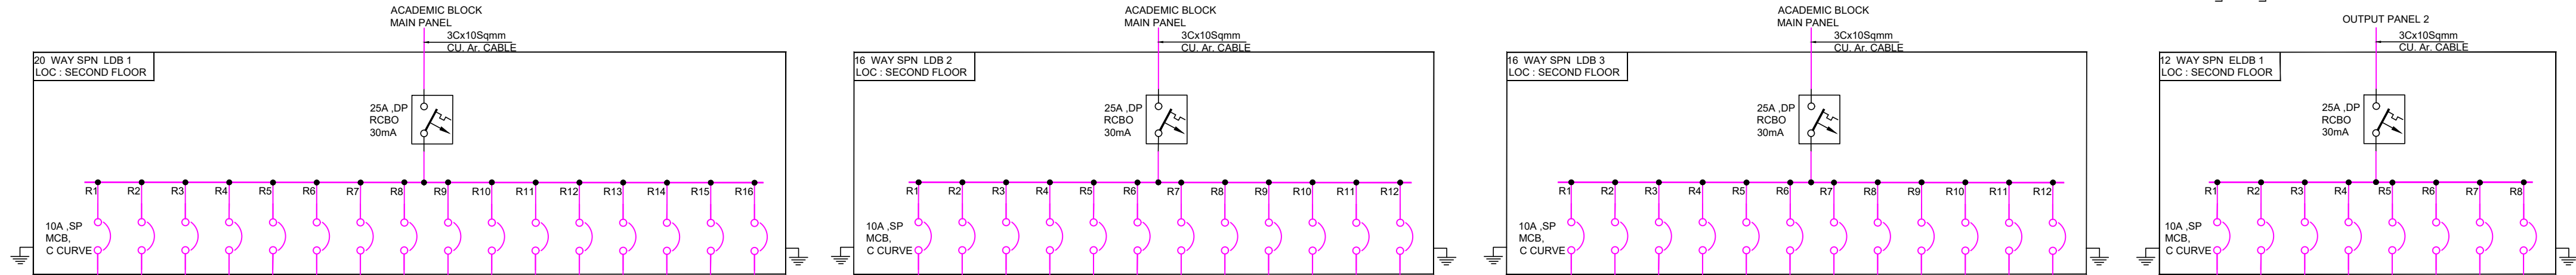


3F

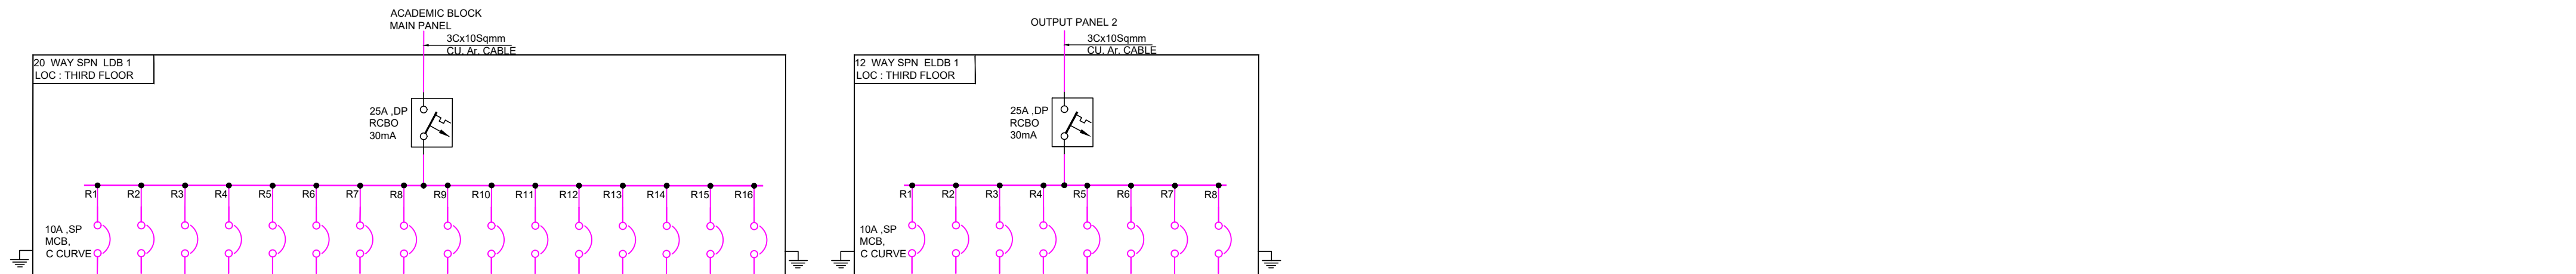

4F

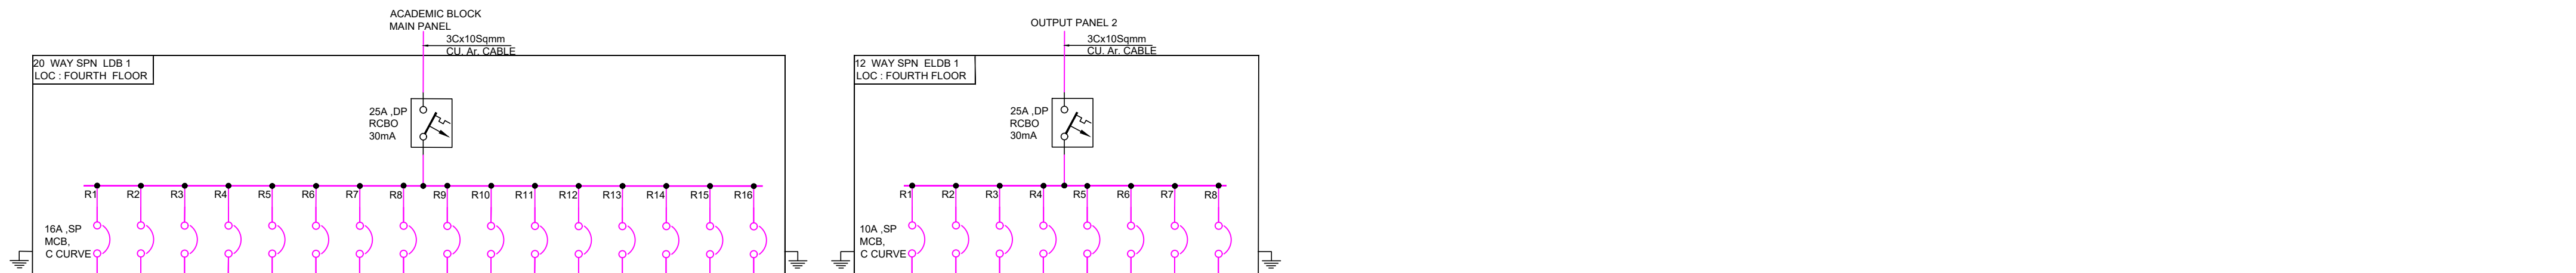

5F

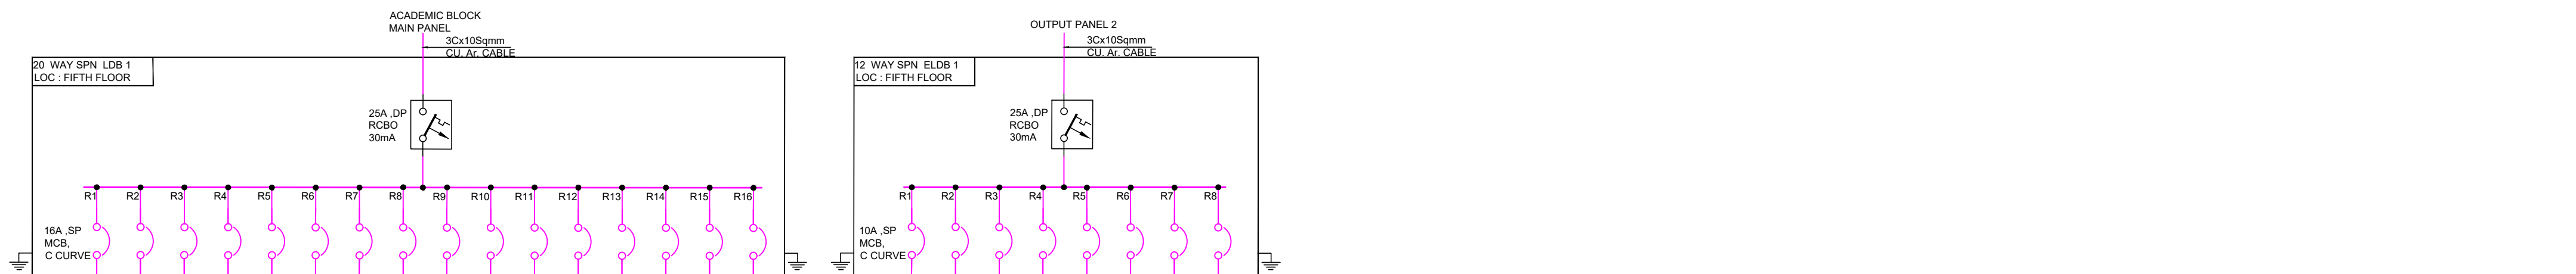

KEYPLAN :-

ISSUALS

REVISIONS

OWNER'S NAME :-

CLIENT :-

NLSIU BENGALURU

PROJECT ARCHITECT:-

DCOOP

ARCHITECTURE.DESIGN.RESEARCH

UNIT NO. 109, 1ST FLOOR, SWASTIK CHAMBERS,  
SG BARVE ROAD, CHEMBUR, MUMBAI - 400071  
PH: 24706945/46 E-MAIL: mail@doop.in

OFFICE SEAL :-

MEP & SUSTAINABILITY CONSULTANT :-



Mc D Built Environment Research Laboratory Pvt Ltd,  
Green building,Sustainability and MEP services,  
No 12,Subramanya Arcade, Tower B , Opposite to Jalbhavan, Old  
Gurappanapalya, BTM 1st stage ,Bannerghatta road ,Bangalore-560 029.  
Ph:+91 80 41222020,URL: www.mcdberl.com

PROJECT TITLE :-

NLSIU BENGALURU

TENDER STAGE

DRAWING TITLE :-

ALL FLOORS DB SCHEDULE  
LAYOUT

PHASE	:	BLOCK	:	SCALE	:
DESIGNED	:	RS	:	DATE	:
DRAWN	:	RS	:	APPROVED	:
CHECKED	:	MEGHANA	:	SHEET	:

DWG NO : TD-LTG-E-DB-201  
This drawing is the property of Mc D Built environment research  
laboratory Pvt Ltd, no part of the drawing may be reproduced in  
any manner whatsoever without permission from McD berl Pvt Ltd.



# **ELECTRICAL TENDER DRAWINGS - POWER LAYOUT**

**OAB REDEVELOPMENT, NLSIU, BENGALURU**

Dec 2024





## ISSUALS

## REVISIONS

CLIENT :-

NLSIU BENGALURU

PROJECT ARCHITECT:-

**DCOOP**  
ARCHITECTURE.DESIGN.RESEARCH

UNIT NO. 109, 1ST FLOOR, SWASTIK CHAMBERS  
SG BARVE ROAD, CHEMBUR, MUMBAI - 400071  
PH: 24706945/46 E-MAIL: mail@dcoop.in

OFFICE SEAL :-

MEP & SUSTAINABILITY CONSULTANT :-



**Mc D Built Environment Research Laboratory Pvt Ltd,**  
Green building,Sustainability and MEP services,  
No 12,Subramanya Arcade, Tower B , Opposite to Jalbhavan, Old  
Gurappanapalya, BTM 1st stage ,Bannerghita road ,Bangalore-560 029.  
Ph:+91 80 41222020,URL: [www.mcdberl.com](http://www.mcdberl.com)

PROJECT TITLE :-

NLSIU BENGALURU

## TENDER STAGE


DRAWING TITLE :-

## LOWER GROUND FLOOR POWER LAYOUT

DWG NO : TD-E-PWR-201

This drawing is the property of Mc D Built environment research laboratory Pvt Ltd, no part of the drawing may be reproduced in any manner whatsoever without permission from McD berl Pvt Ltd.



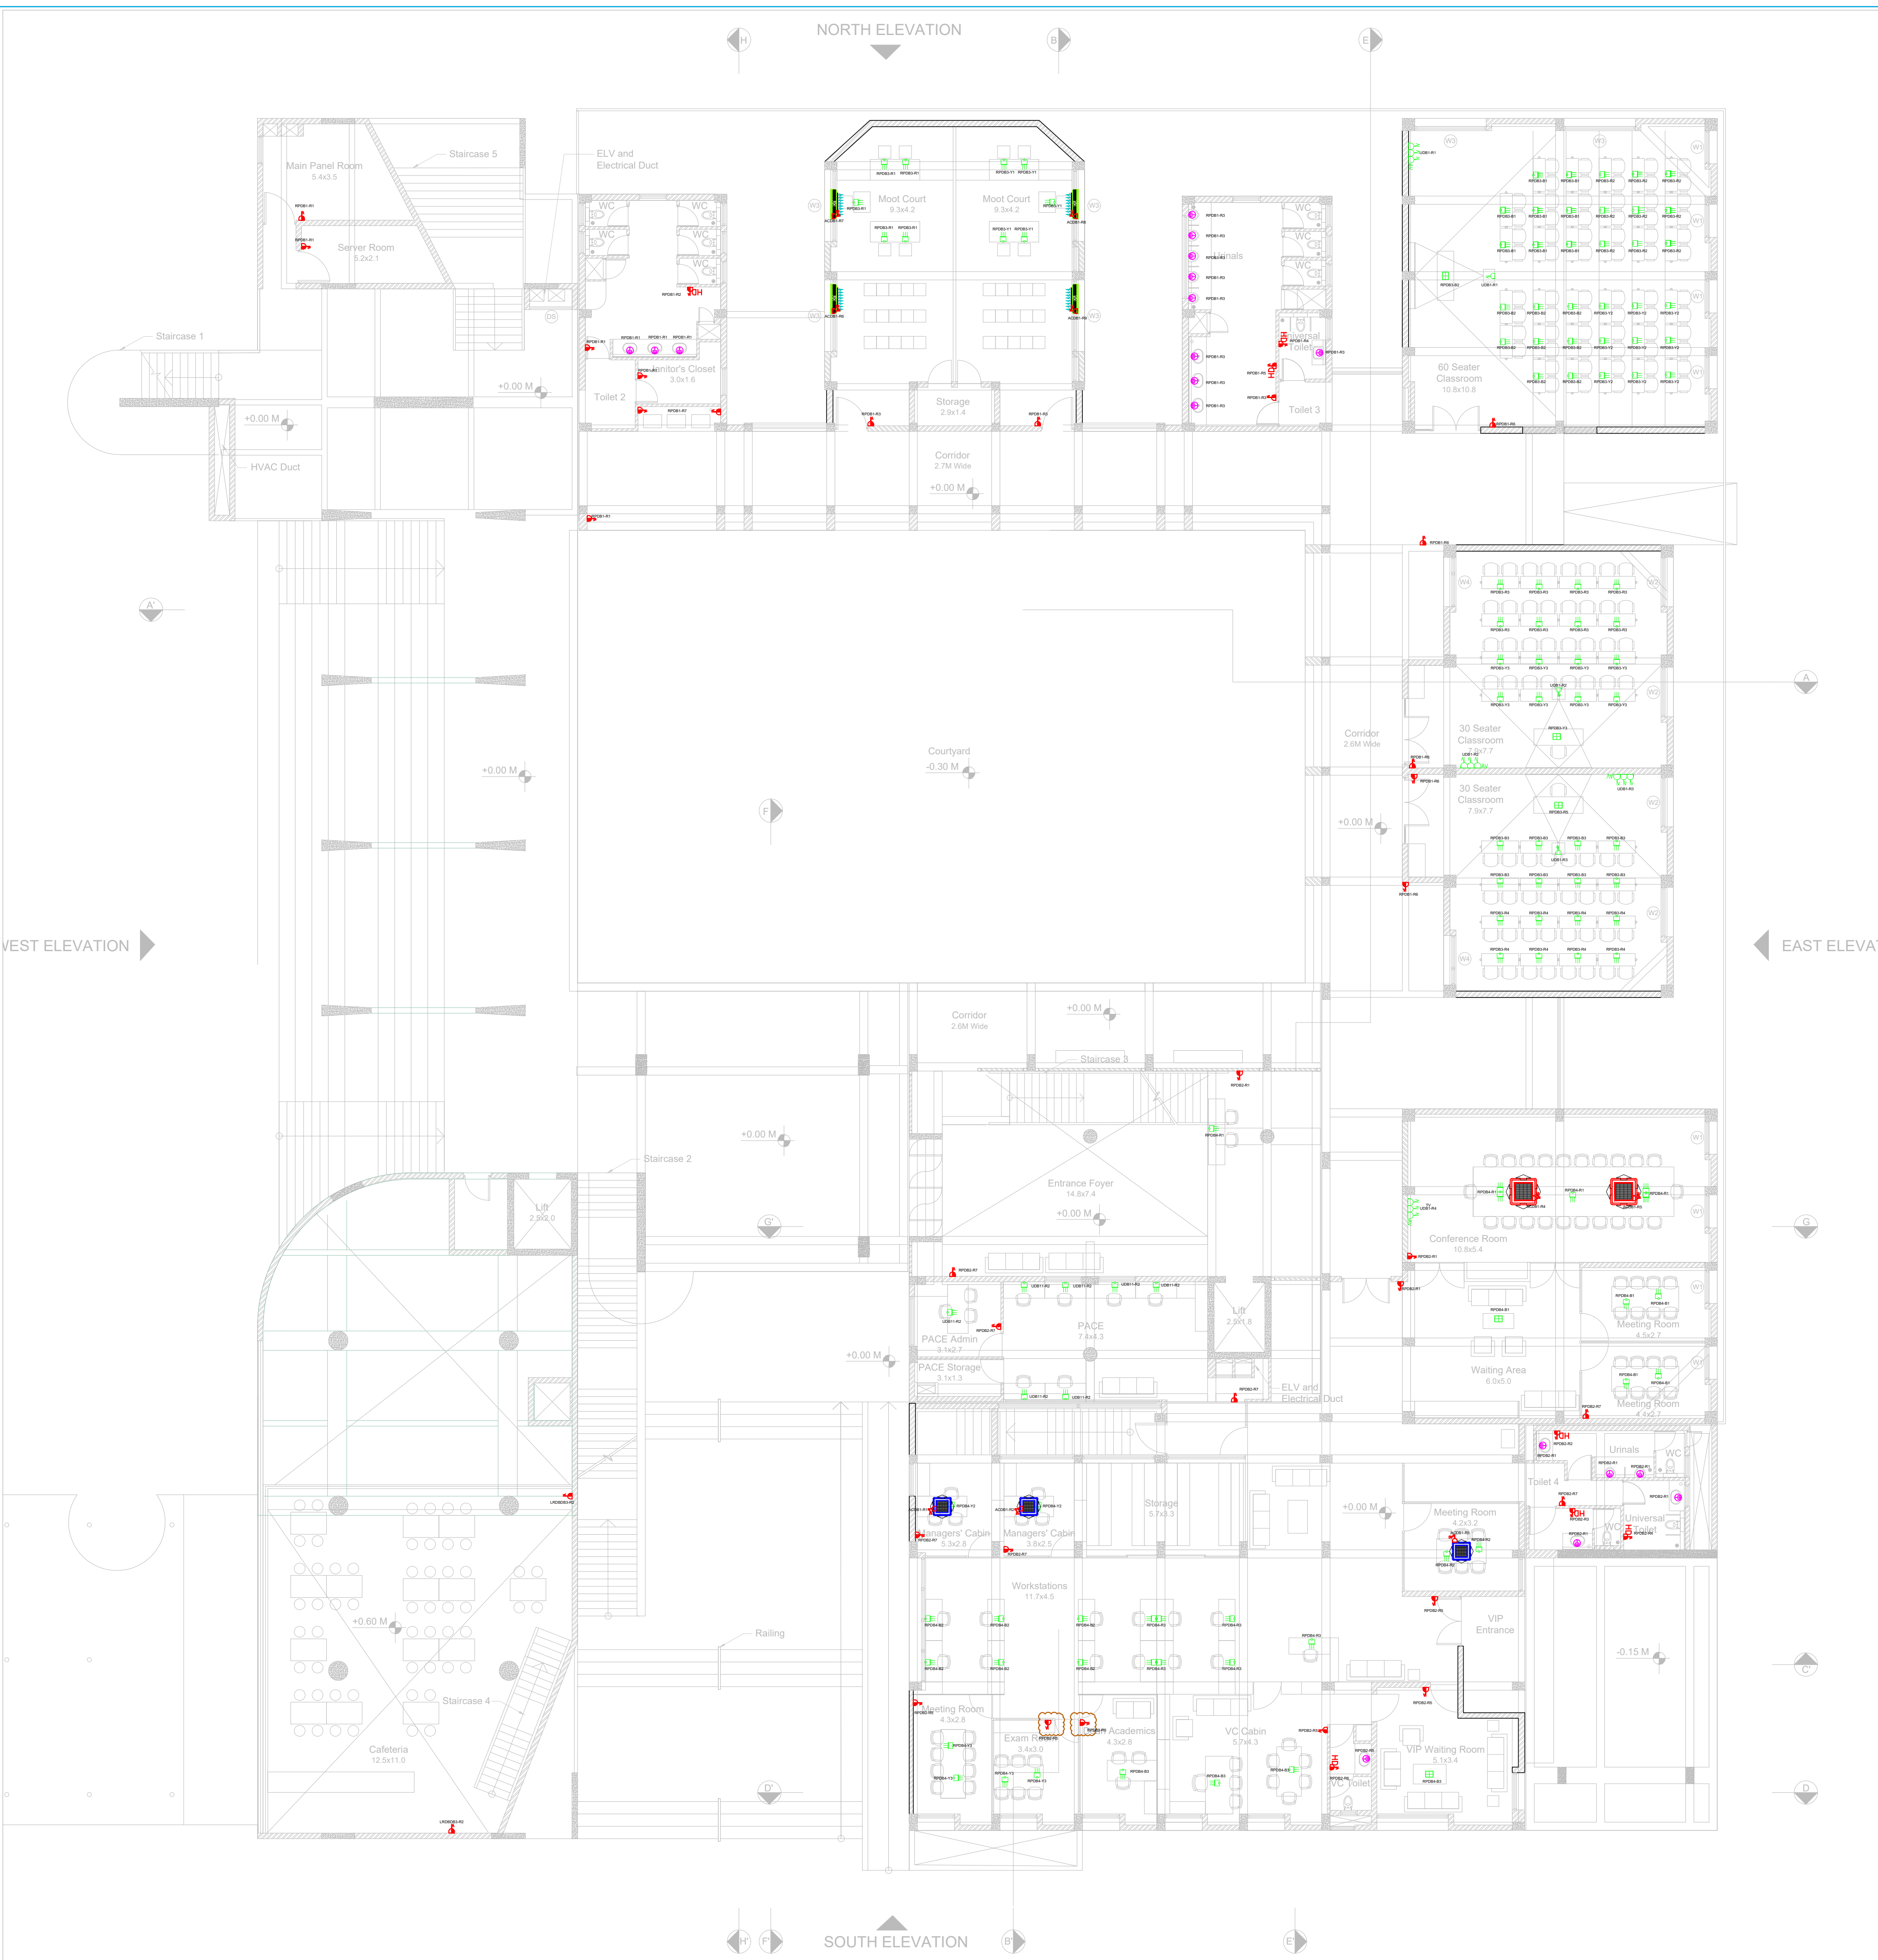

ELECTRICAL LEGENDS		
S/NO	AREA	DESCRIPTION
1	CLASSROOMS (LAPTOPS)	3Nos. OF 6A UNIVERSAL SOCKET CONTROLLED BY 1No. OF 6A SP SWITCH WITH OUT BOX ON UPS POWER.
2	TOILETS	1 NO OF 5/6A UNIVERSAL SOCKET WITHOUT SWITCH FOR URINALS & WASH BASIN SENSORS ON RAW POWER (WCEILING). 6/16A. UNIVERSAL SOCKET CONTROLLED BY 1 No. OF 16 A SINGLE POLE SWITCH ON RAW POWER FOR HAND DRIER. (Ø1200MM FROM FFL.)
3	PASSAGE/ CORRIDOR/ SERVICE ROOM	6/16A. UNIVERSAL SOCKET CONTROLLED BY 1 No. OF 16 A SINGLE POLE SWITCH ON RAW POWER- CLEANING SOCKET(300ØMM FROM FFL.)
4	PANTRY	6/16A. UNIVERSAL SOCKET CONTROLLED BY 1No. OF 16A SP SWITCH FOR UTILITY ON RAW POWER (AS PER ARCH ELEVATION).
5	AC	16A, 5 PIN SOCKET CONTROLLED BY 1 No. OF 16 A SINGLE POLE SWITCH ON RAW POWER(240ØMM FROM FFL.)
6	CLASSROOMS /CABINS/LOUNGE	6A. UNIVERSAL SOCKET CONTROLLED BY 1 No. OF 6 A SINGLE POLE SWITCH ON RAW POWER- FLOOR POP UP BOX ON UPS POWER
7	CLASSROOMS /MEETING ROOMS	16A. UNIVERSAL SOCKET CONTROLLED BY 1No. OF 16A SP SWITCH FOR PROJECTOR ON UPS POWER (AS PER ARCH ELEVATION).
8	CLASSROOMS /MEETING ROOMS	3Nos. OF 16A UNIVERSAL SOCKET CONTROLLED BY 1No. OF 16A SP SWITCH WITH OUT BOX ON UPS POWER-FOR AV & SPEAKER.



KEYPLAN :-

ISSUALS

R0	TENDER STAGE	11.12.2024	RS
----	--------------	------------	----

REVISIONS

OWNER'S NAME :-

CLIENT :-

NLSIU BENGALURU

PROJECT ARCHITECT:-  
DCCOOP  
ARCHITECTURE.DESIGN.RESEARCH  
UNIT NO. 109, 1ST FLOOR, SWASTIK CHAMBERS,  
SG BARVE ROAD, CHEMBUR, MUMBAI - 400071  
PH: 24706945/46 E-MAIL: mail@dcoop.in

OFFICE SEAL :-

MEP & SUSTAINABILITY CONSULTANT :-  
  
Mc D Built Environment Research Laboratory Pvt Ltd,  
Green building,Sustainability and MEP services,  
No 12,Subramanya Arcade, Tower B, Opposite to Jalbhavan, Old  
Gurappanapalya, BTM 1st stage ,Bannerghita road ,Bangalore-560 029.  
Ph:+91 80 41222020,URL: www.mcdberl.com

PROJECT TITLE :-

NLSIU BENGALURU

TENDER STAGE


DRAWING TITLE :-

GROUND FLOOR POWER LAYOUT

PHASE	:	BLOCK	:	SCALE	:
DESIGNED	:	RS	:	DATE	:
DRAWN	:	RS	:	APPROVED	:
CHECKED	:	MEGHANA	:	SHEET	:
DWG NO	:	TD-E-PWR-202	:		:

This drawing is the property of Mc D Built environment research laboratory Pvt Ltd, no part of the drawing may be reproduced in any manner whatsoever without permission from McD berl Pvt Ltd.



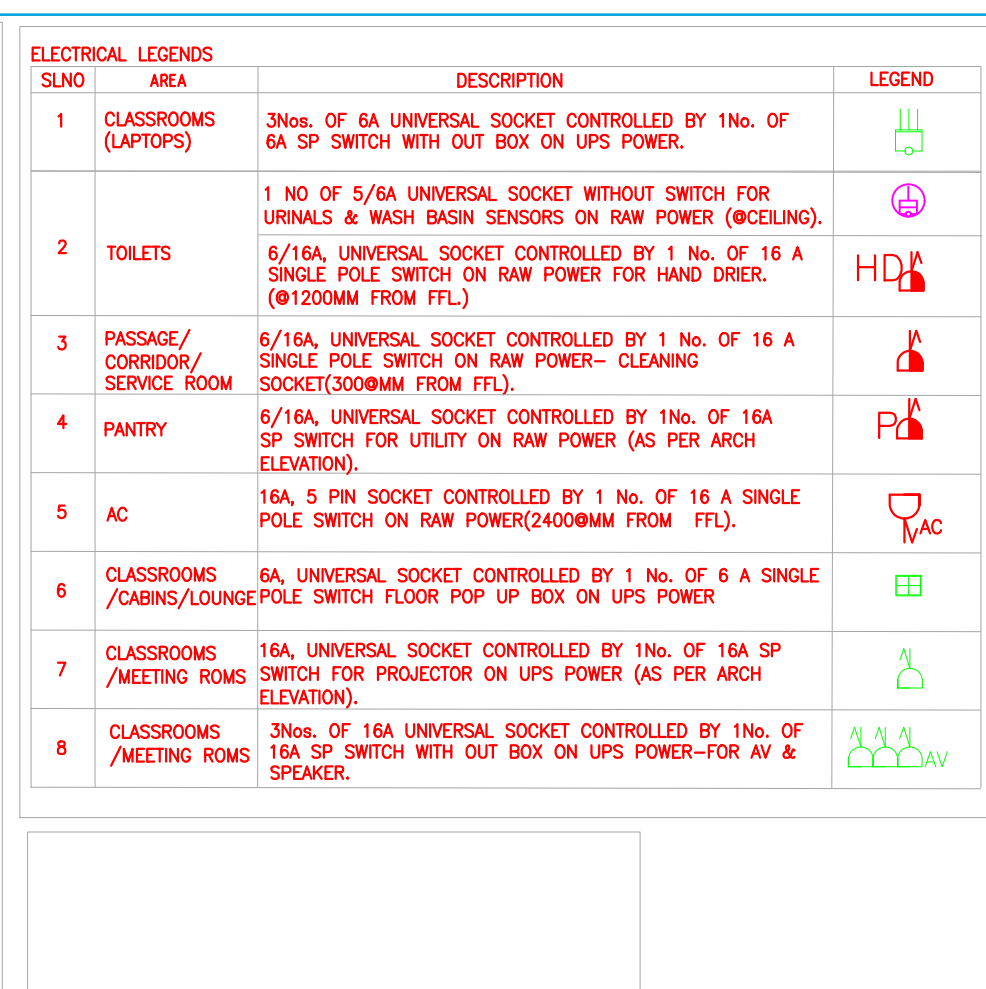

## ISSUALS

OWNER'S NAME :-

CLIENT :-

NLSIU BENGALURU

PROJECT ARCHITECT:-

DCOOP  
ARCHITECTURE.DESIGN.RESEARCH

UNIT NO. 109, 1ST FLOOR, SWASTIK CHAMBERS  
SG BARVE ROAD, CHEMBUR, MUMBAI - 400071  
PH: 24706945/46 E-MAIL: mail@dcoop.in

OFFICE SEAL :-

MEP & SUSTAINABILITY CONSULTANT :-



**Mc D Built Environment Research Laboratory Pvt Ltd,**  
Green building,Sustainability and MEP services,  
No 12,Subramanya Arcade, Tower B , Opposite to Jalbhavan, Old  
Gurappanapalya, BTM 1st stage ,Bannerghatta road ,Bangalore-560 029.  
Ph:+91 80 41222020,URL: [www.mcdberl.com](http://www.mcdberl.com)

PROJECT TITLE :-

NLSIU BENGALURU

## TENDER STAGE

DRAWING TITLE :-


## FIRST FLOOR POWER LAYOUT

PHASE :	BLOCK :	SCALE :
DESIGNED : RS	DATE : 11.12.2024	1:125
DRAWN : RS	APPROVED : MEGHANA	REV NO:
CHECKED : MEGHANA	SHEET : A1	R1

DWG NO : TD-E-PWR-203

This drawing is the property of Mc D Built environment research laboratory Pvt Ltd, no part of the drawing may be reproduced in any manner whatsoever without permission from McD berl Pvt Ltd.



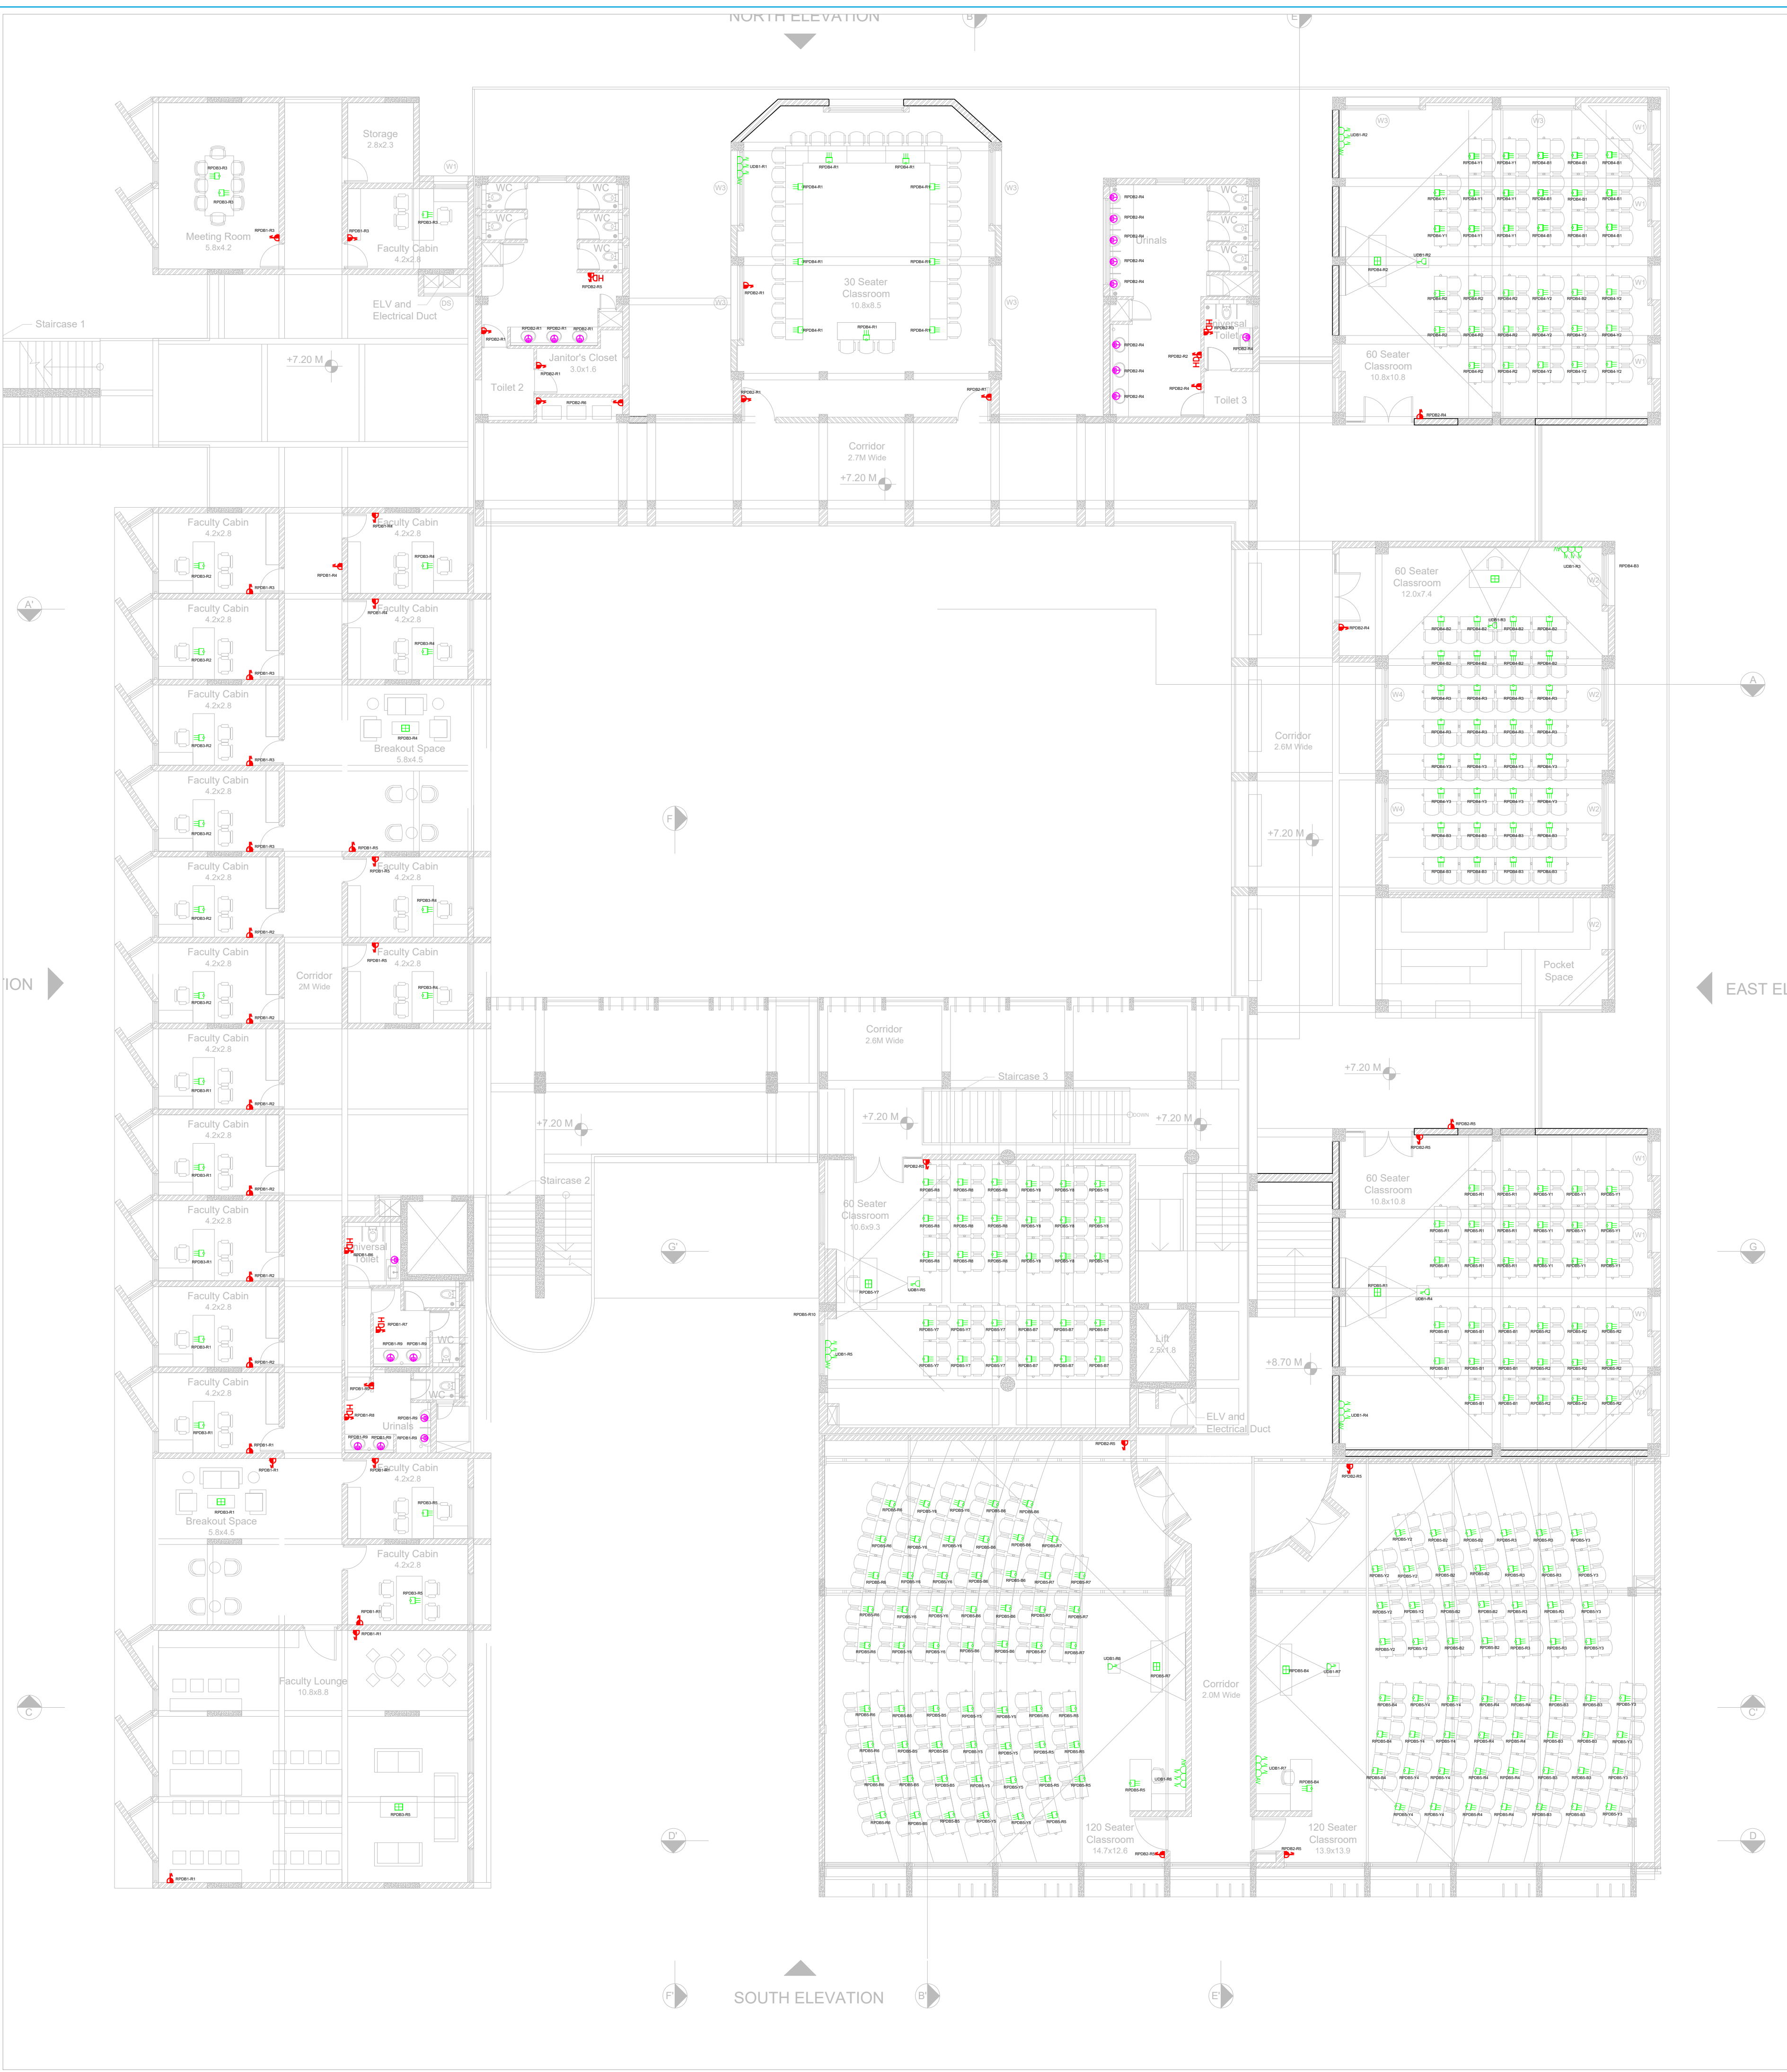

ELECTRICAL LEGENDS			
SLNO	AREA	DESCRIPTION	LEGEND
1	CLASSROOMS (LAPTOPS)	3Nos. OF 6A UNIVERSAL SOCKET CONTROLLED BY 1No. OF 6A SP SWITCH WITH OUT BOX ON UPS POWER.	
2	TOILETS	1 NO OF 5/6A UNIVERSAL SOCKET WITHOUT SWITCH FOR URINALS & WASH BASIN SENSORS ON RAW POWER (WCEILING). 6/16A. UNIVERSAL SOCKET CONTROLLED BY 1 No. OF 16 A SINGLE POLE SWITCH ON RAW POWER FOR HAND DRIER. (Ø1200MM FROM FFL.)	
3	PASSAGE/ CORRIDOR/ SERVICE ROOM	6/16A. UNIVERSAL SOCKET CONTROLLED BY 1 No. OF 16 A SINGLE POLE SWITCH ON RAW POWER- CLEANING SOCKET(300ØMM FROM FFL.)	
4	PANTRY	6/16A. UNIVERSAL SOCKET CONTROLLED BY 1No. OF 16A SP SWITCH FOR UTILITY ON RAW POWER (AS PER ARCH ELEVATION).	
5	AC	16A, 5 PIN SOCKET CONTROLLED BY 1 No. OF 16 A SINGLE POLE SWITCH ON RAW POWER(240ØMM FROM FFL.)	
6	CLASSROOMS /CABINS/LOUNGE	6A. UNIVERSAL SOCKET CONTROLLED BY 1 No. OF 6 A SINGLE POLE SWITCH ON RAW POWER- POP BOX ON UPS POWER	
7	CLASSROOMS /MEETING ROOMS	16A. UNIVERSAL SOCKET CONTROLLED BY 1No. OF 16A SP SWITCH FOR PROJECTOR ON UPS POWER (AS PER ARCH ELEVATION).	
8	CLASSROOMS /MEETING ROOMS	3Nos. OF 16A UNIVERSAL SOCKET CONTROLLED BY 1No. OF 16A SP SWITCH WITH OUT BOX ON UPS POWER-FOR AV & SPEAKER.	

KEYPLAN :-

ISSUALS

R0	TENDER STAGE	11.12.2024	RS
REVISIONS			

OWNER'S NAME :-

CLIENT :-

NLSIU BENGALURU

PROJECT ARCHITECT:-

**DCOOP**  
ARCHITECTURE.DESIGN.RESEARCH

UNIT NO. 109, 1ST FLOOR, SWASTIK CHAMBERS,  
SG BARVE ROAD, CHEMBUR, MUMBAI - 400071  
PH: 24706945/46 E-MAIL: mail@dooop.in

OFFICE SEAL :-

MEP & SUSTAINABILITY CONSULTANT :-



Mc D Built Environment Research Laboratory Pvt Ltd,  
Green building,Sustainability and MEP services,  
No 12,Subramanya Arcade, Tower B , Opposite to Jalbhavan, Old  
Gurappanapalya, BTM 1st stage ,Bannerghita road ,Bangalore-560 029.  
Ph:+91 80 41222020,URL: www.mcdberl.com

PROJECT TITLE :-

NLSIU BENGALURU

TENDER STAGE


DRAWING TITLE :-

SECOND FLOOR POWER  
LAYOUT

PHASE	:	BLOCK	:	SCALE	:
DESIGNED	:	RS	:	DATE	:
DRAWN	:	RS	:	APPROVED	:
CHECKED	:	MEGHANA	:	SHEET	:
DWG NO	:	TD-E-PWR-204	:		:















This drawing is the property of Mc D Built environment research laboratory Pvt Ltd, no part of the drawing may be reproduced in any manner whatsoever without permission from McD berl Pvt Ltd.




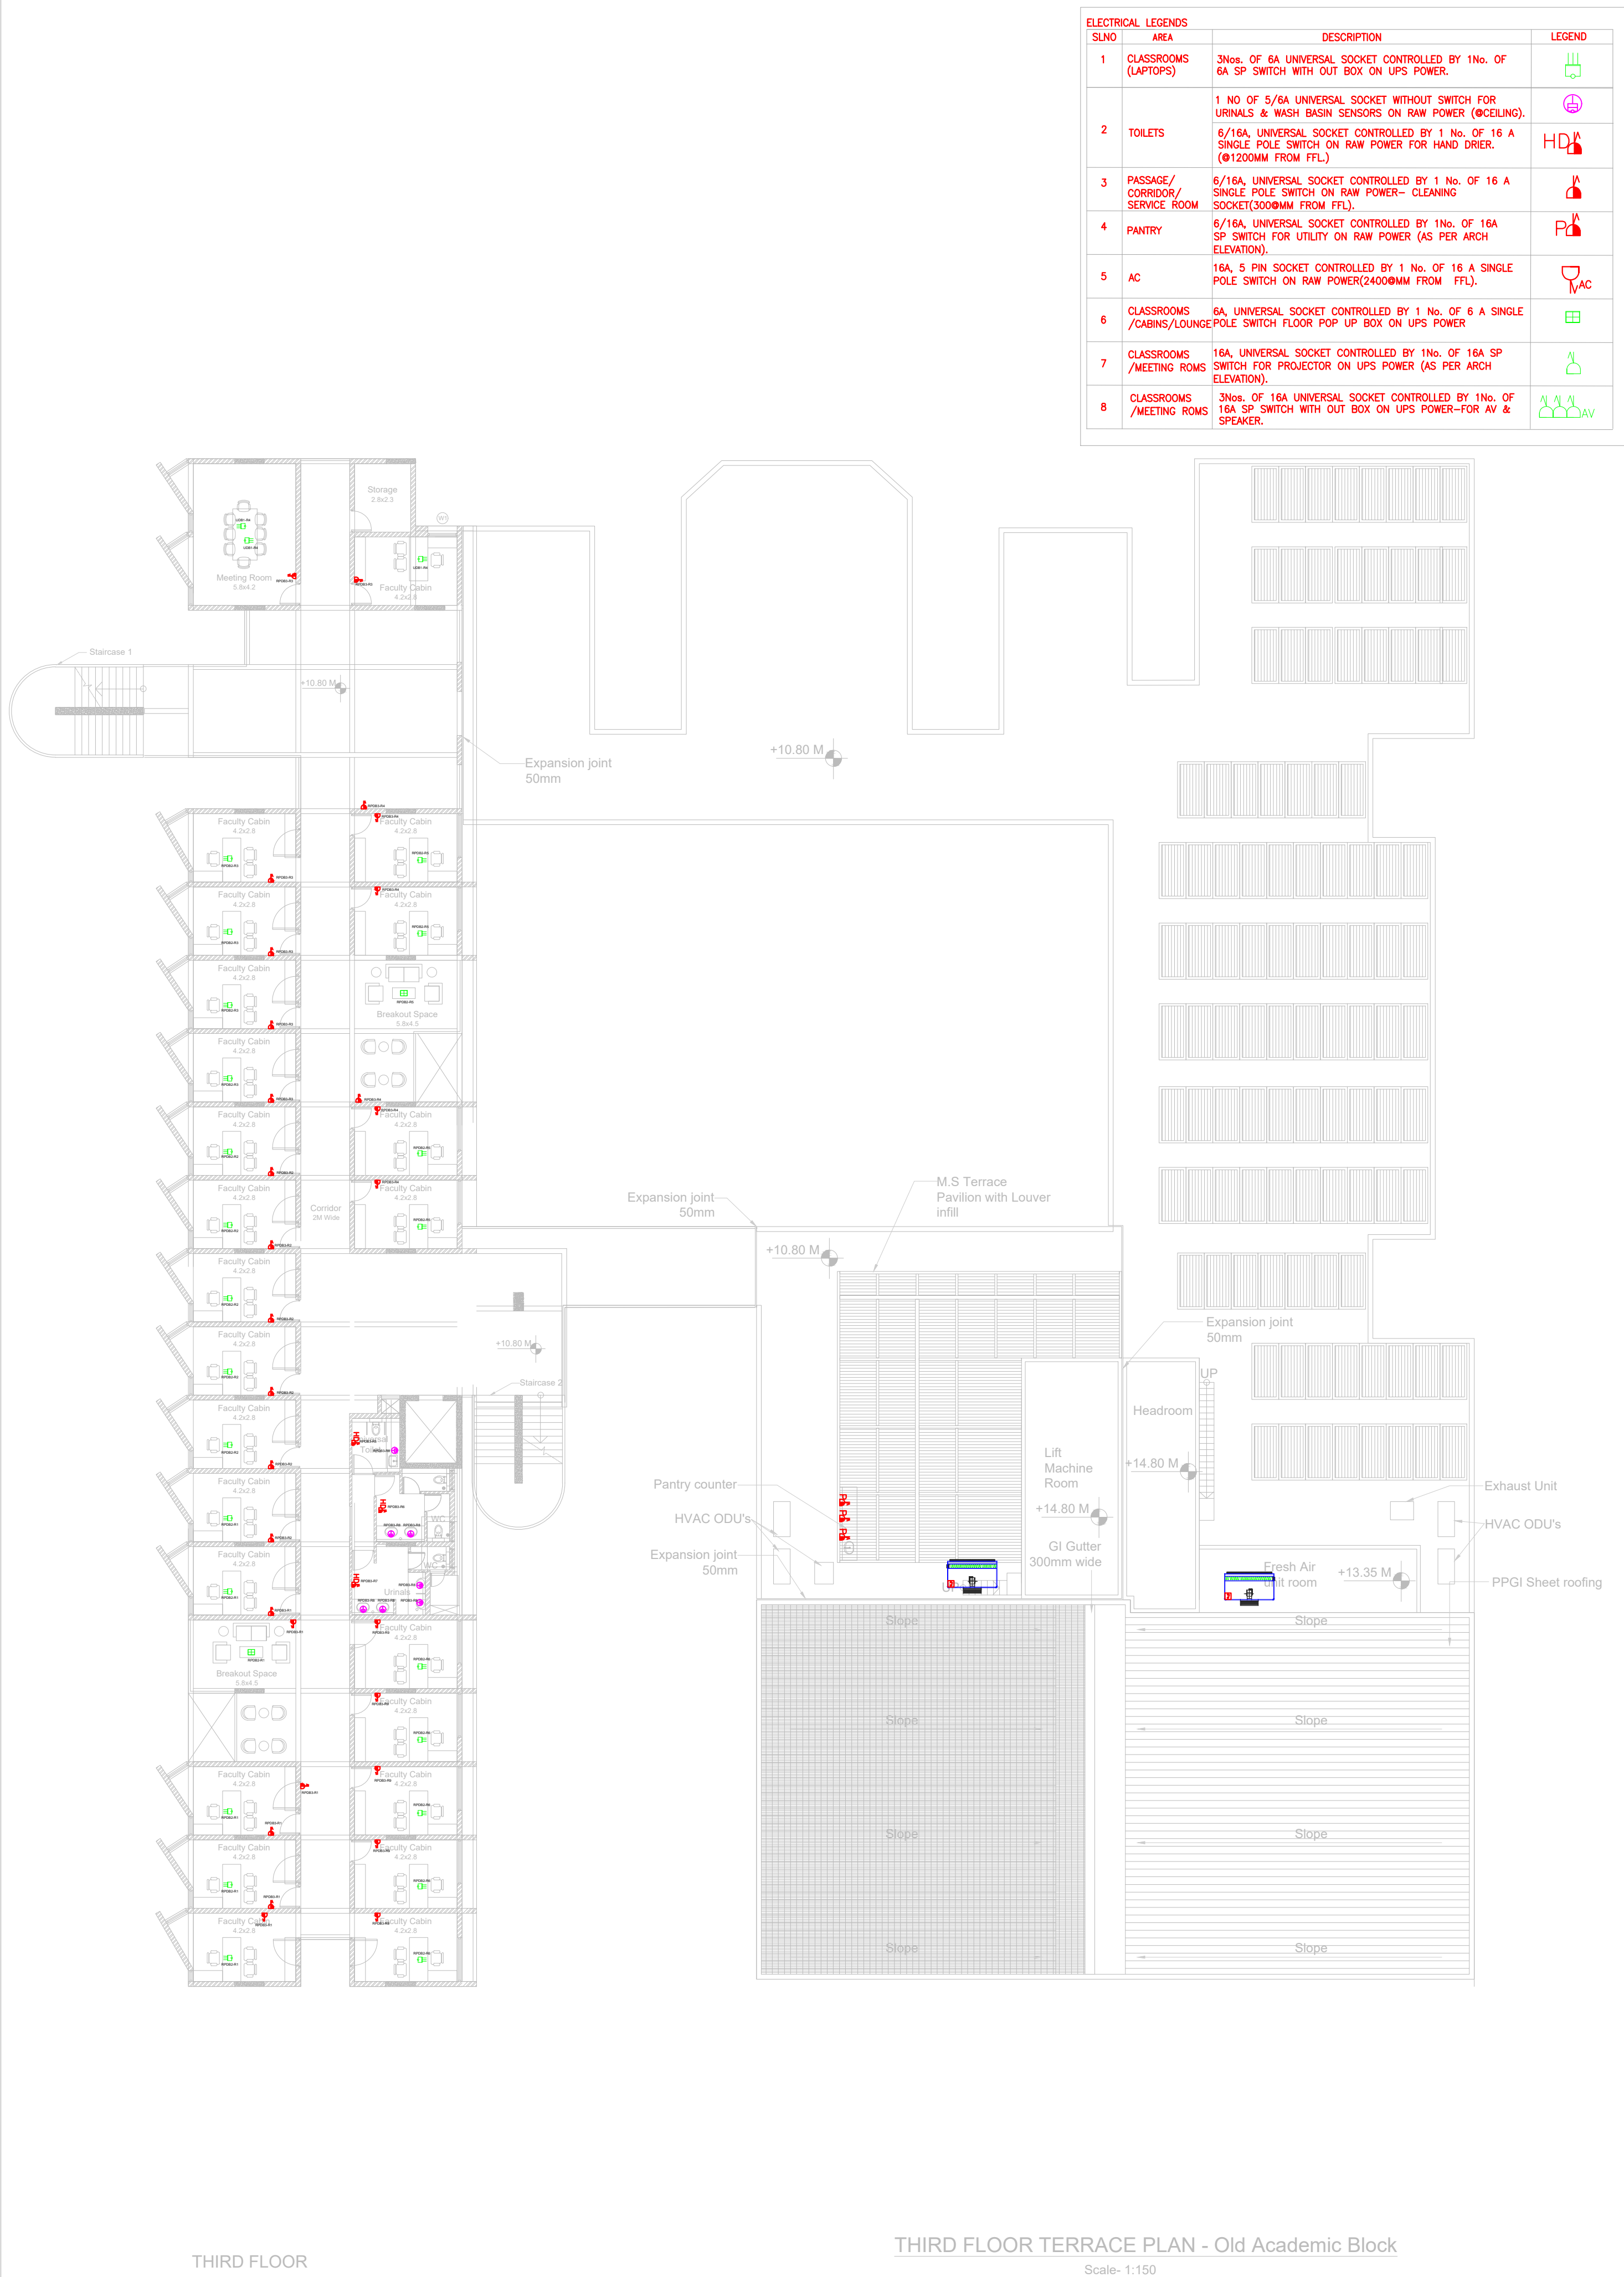




LGF

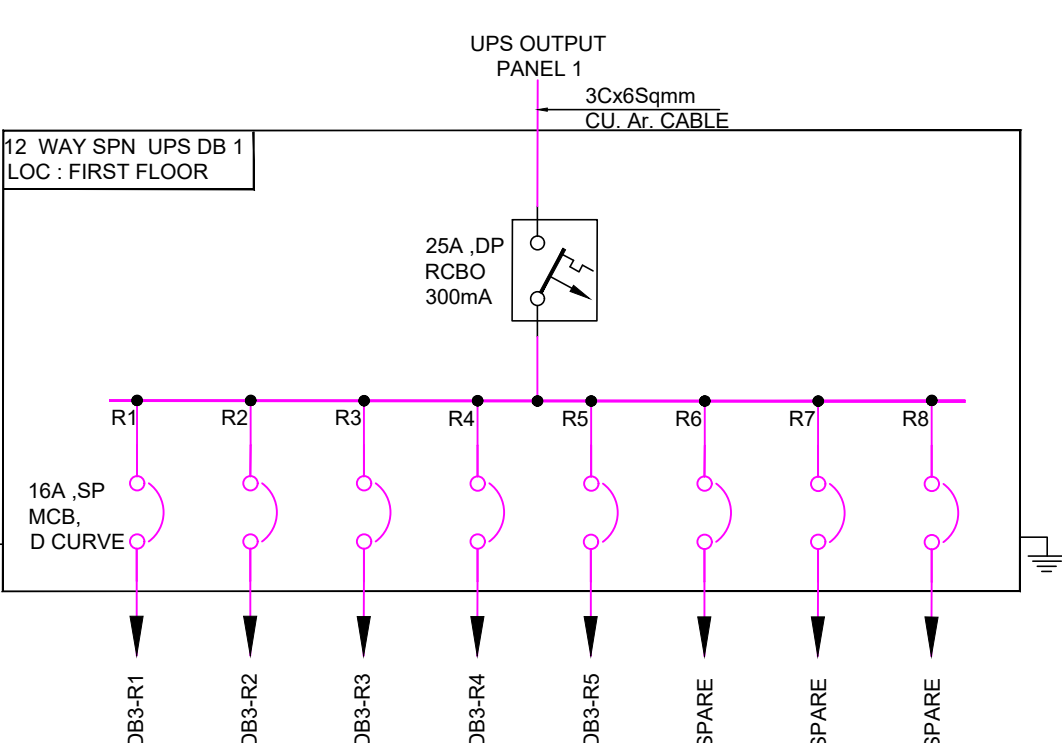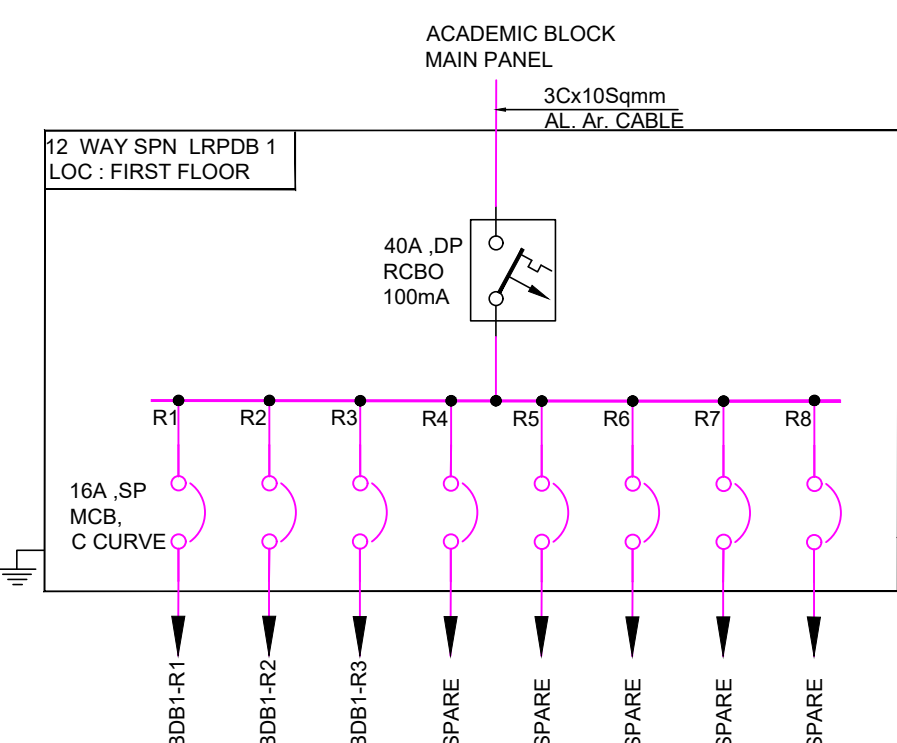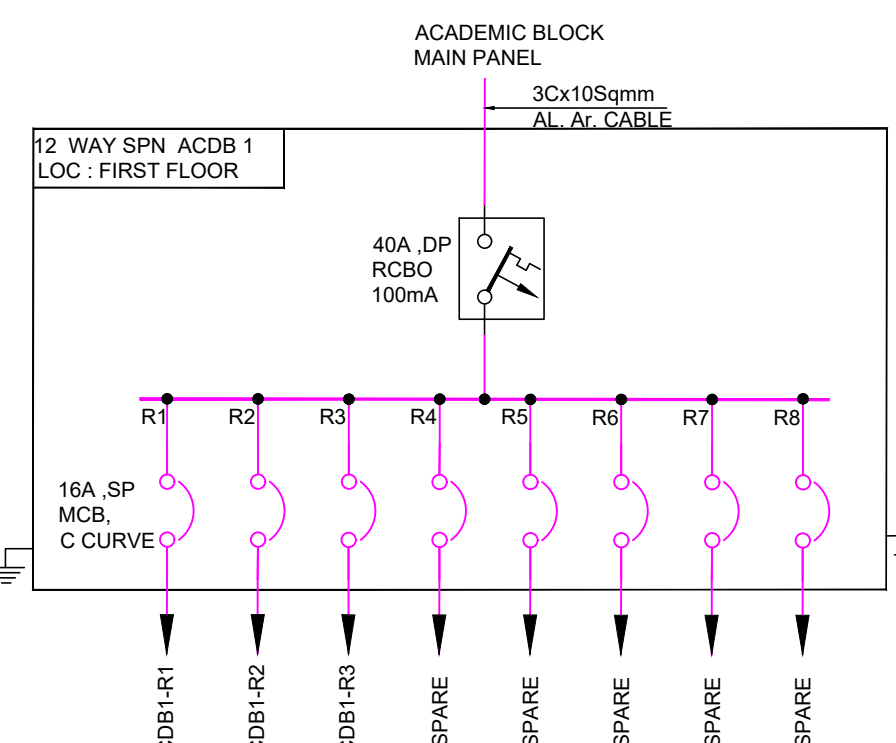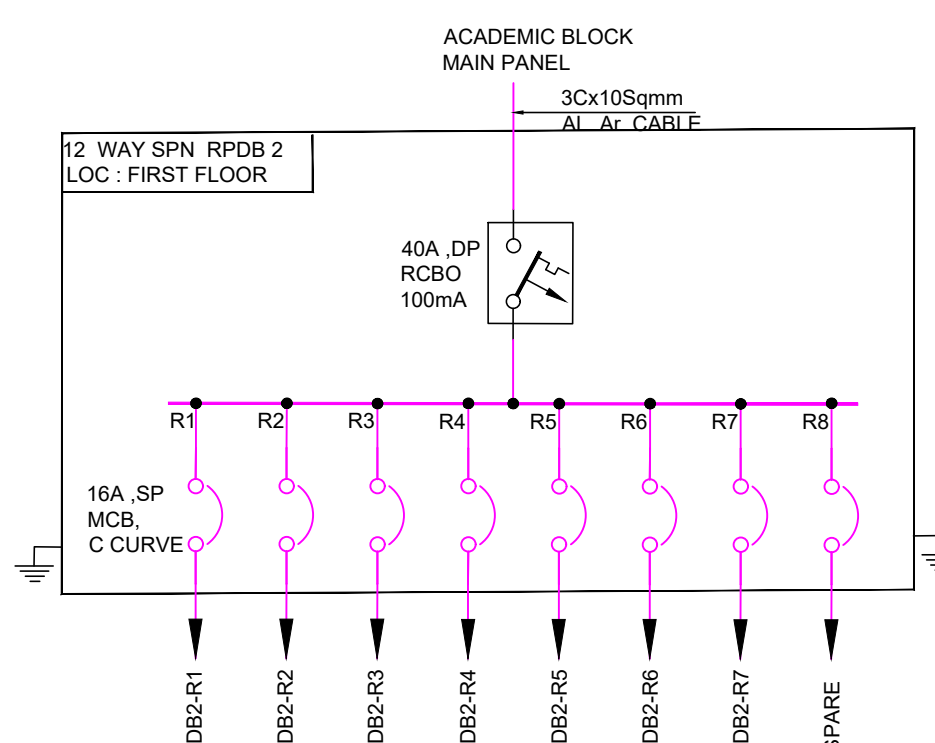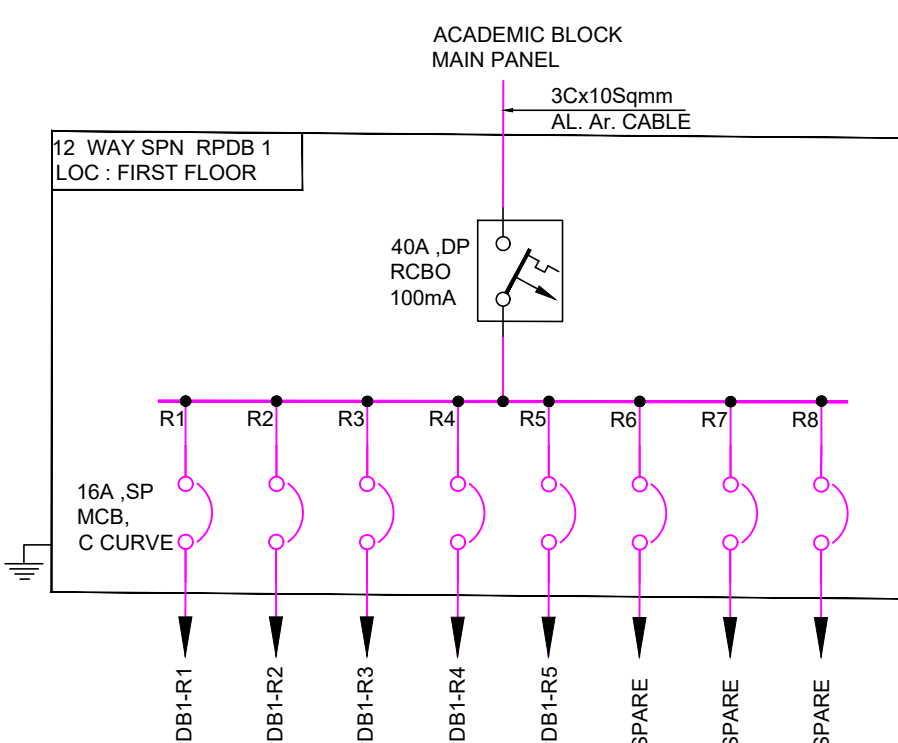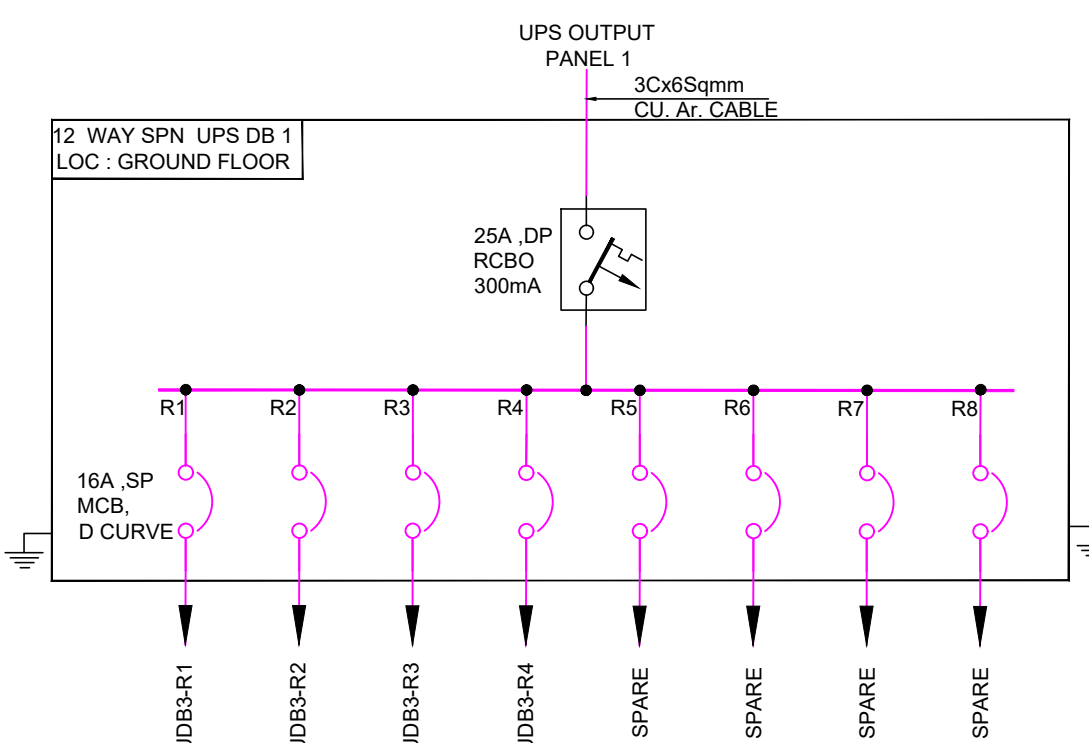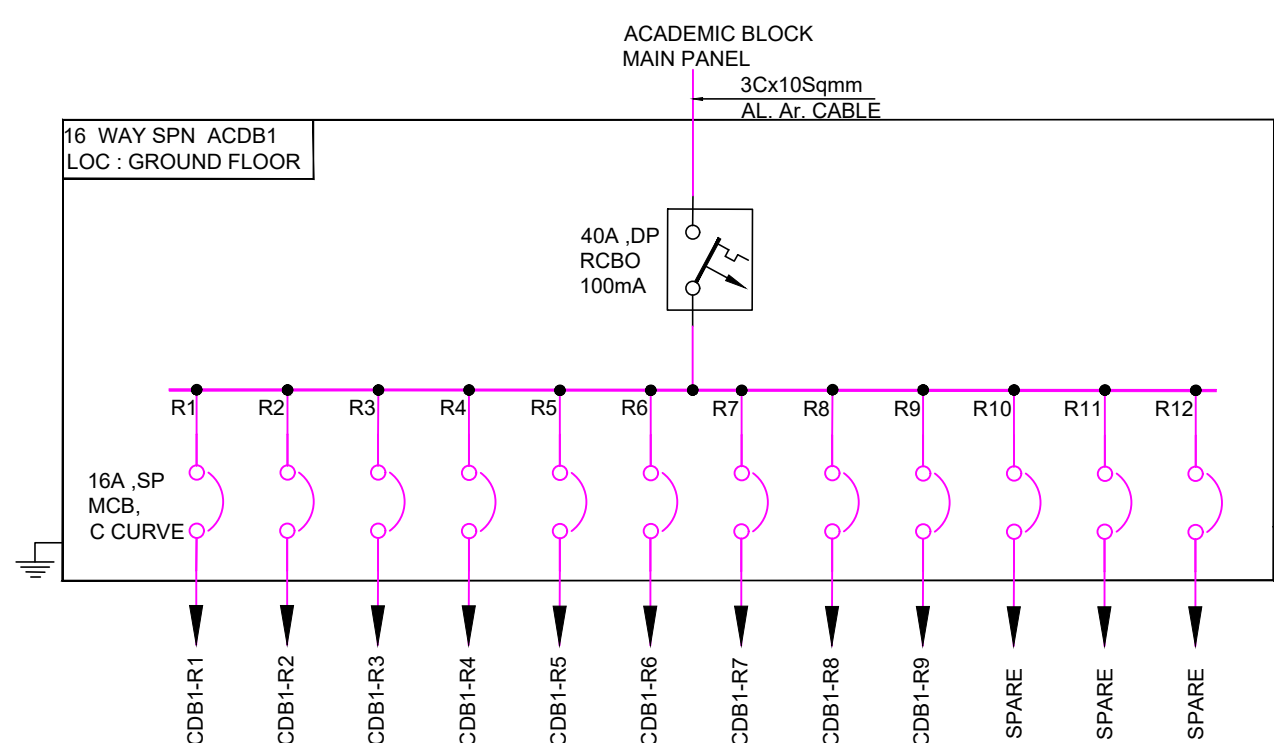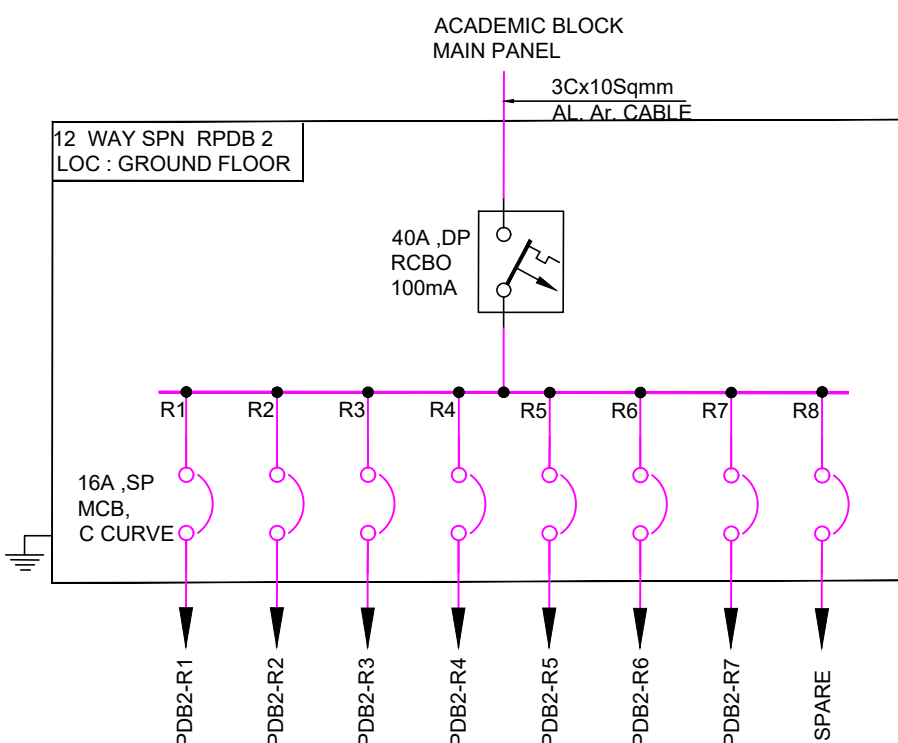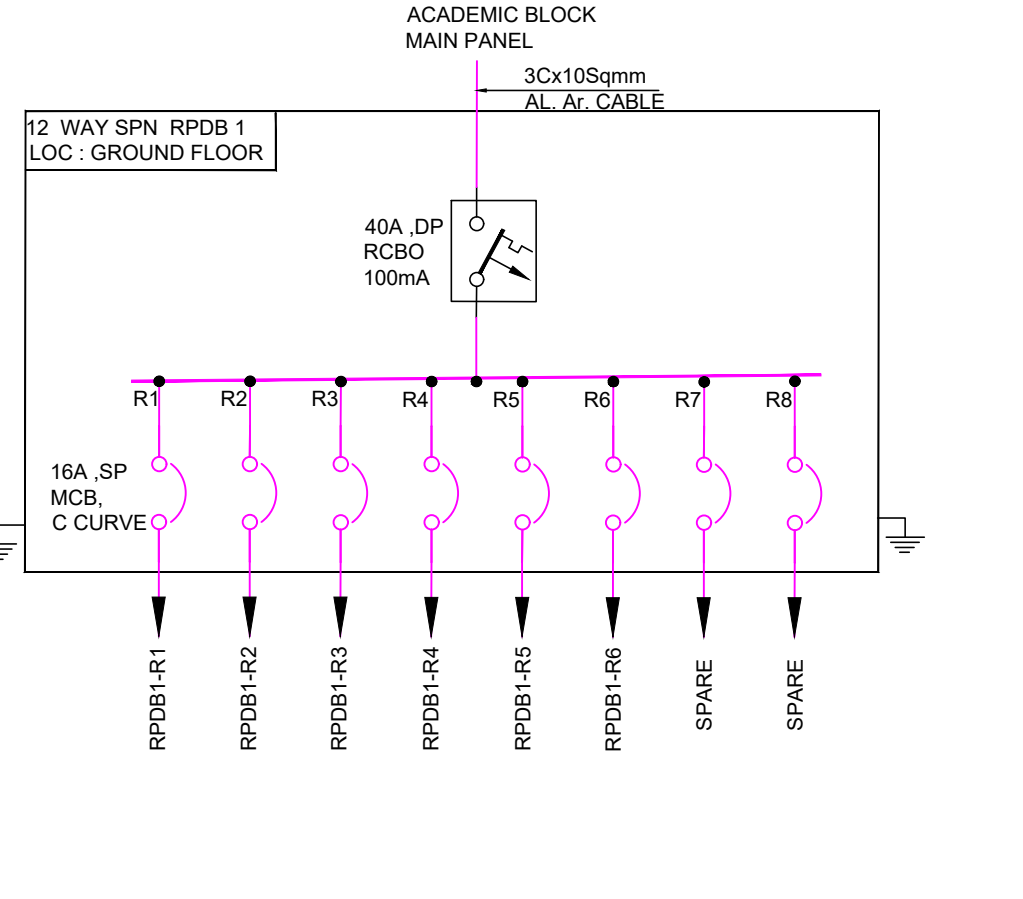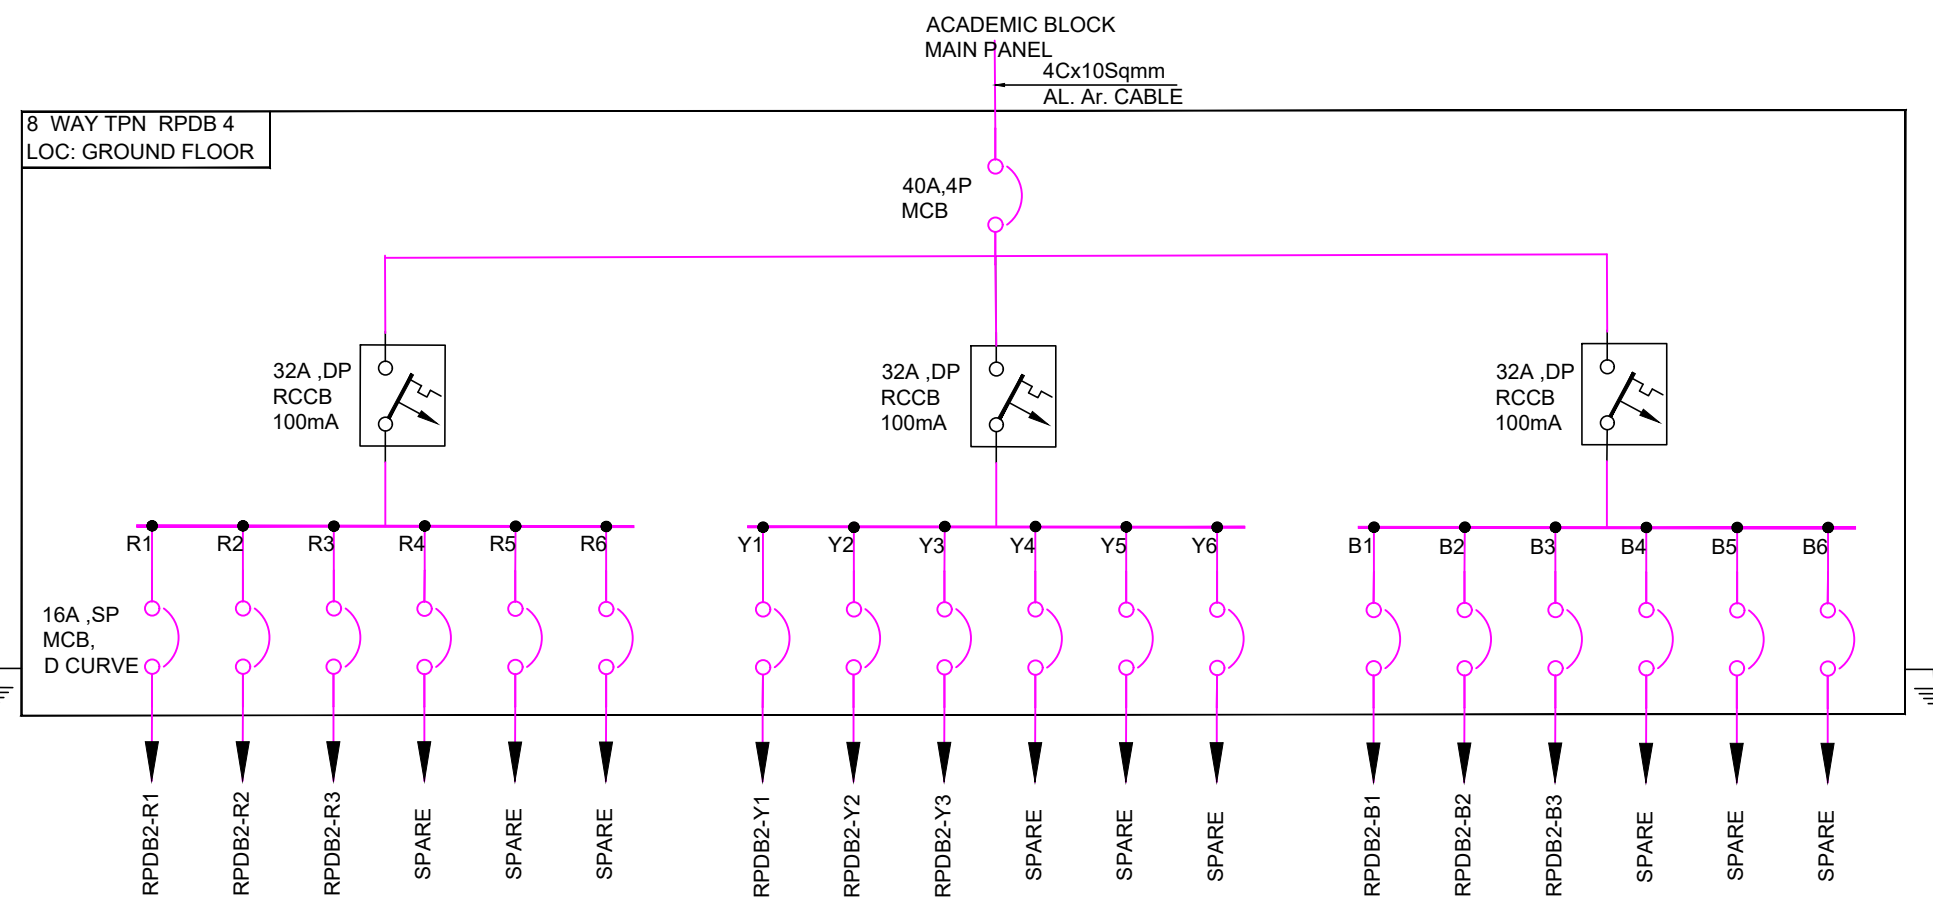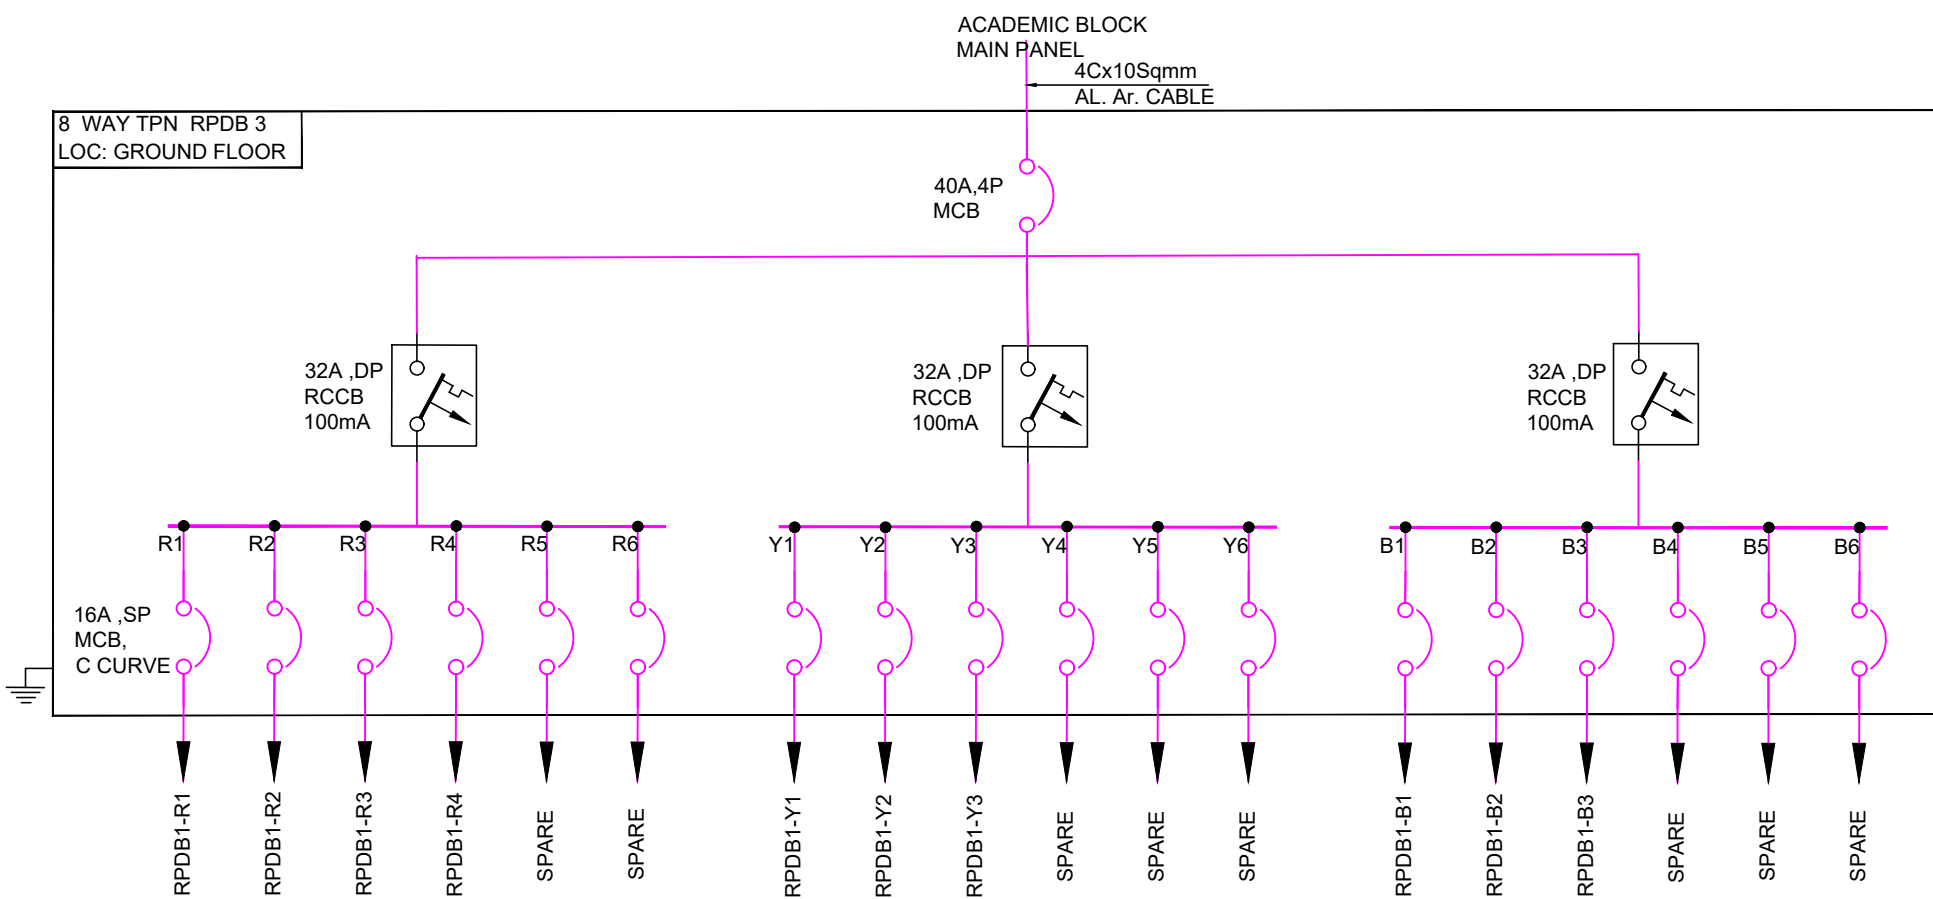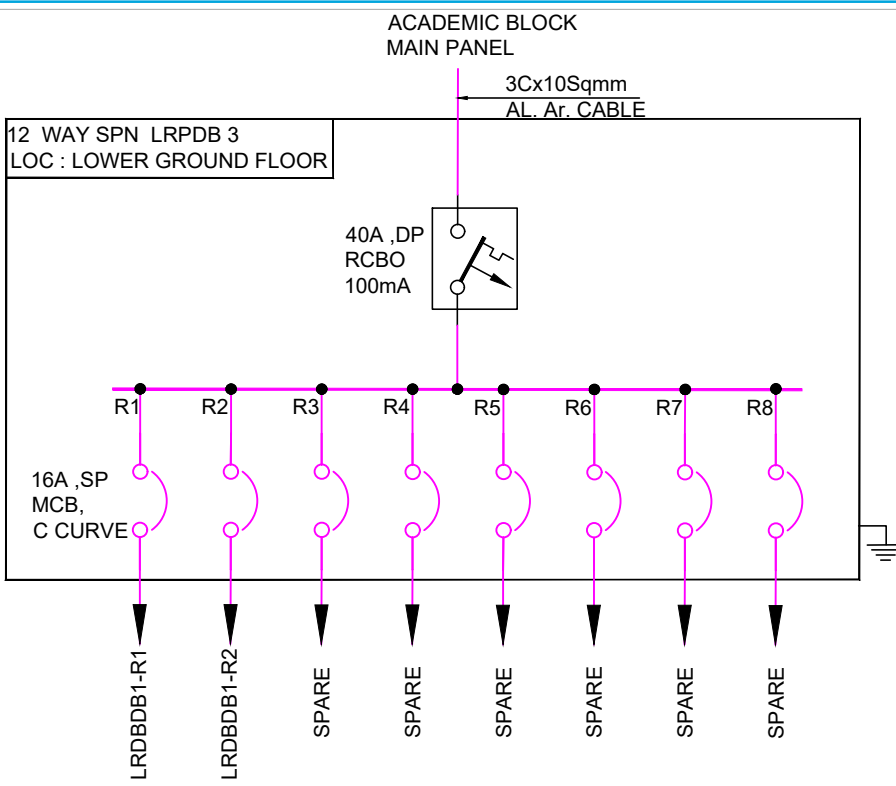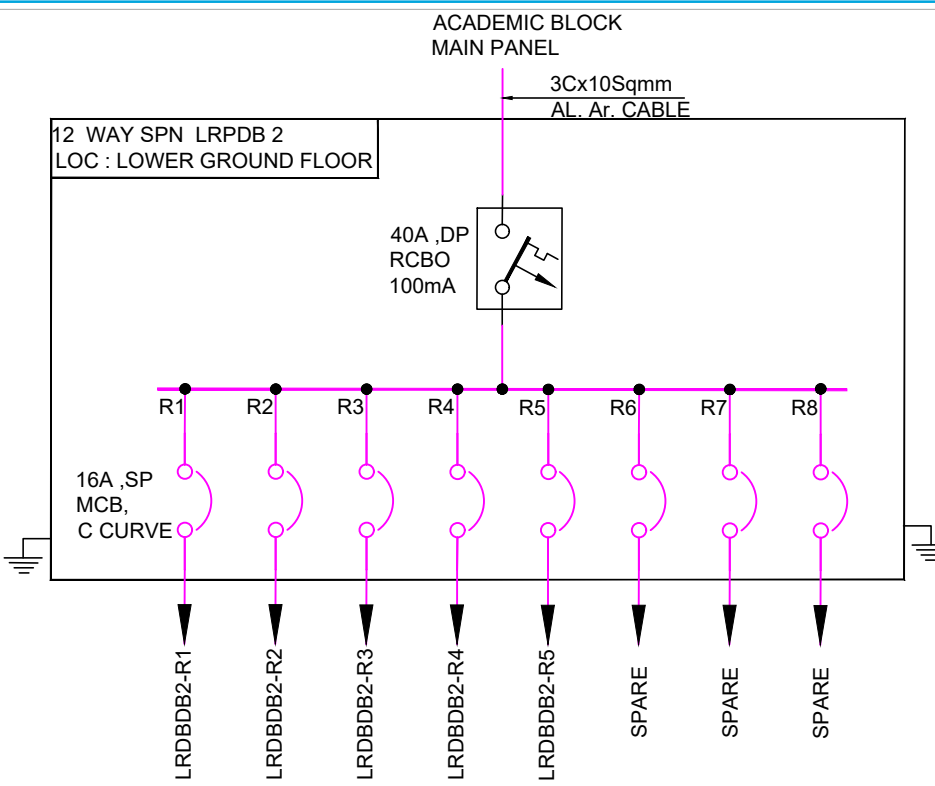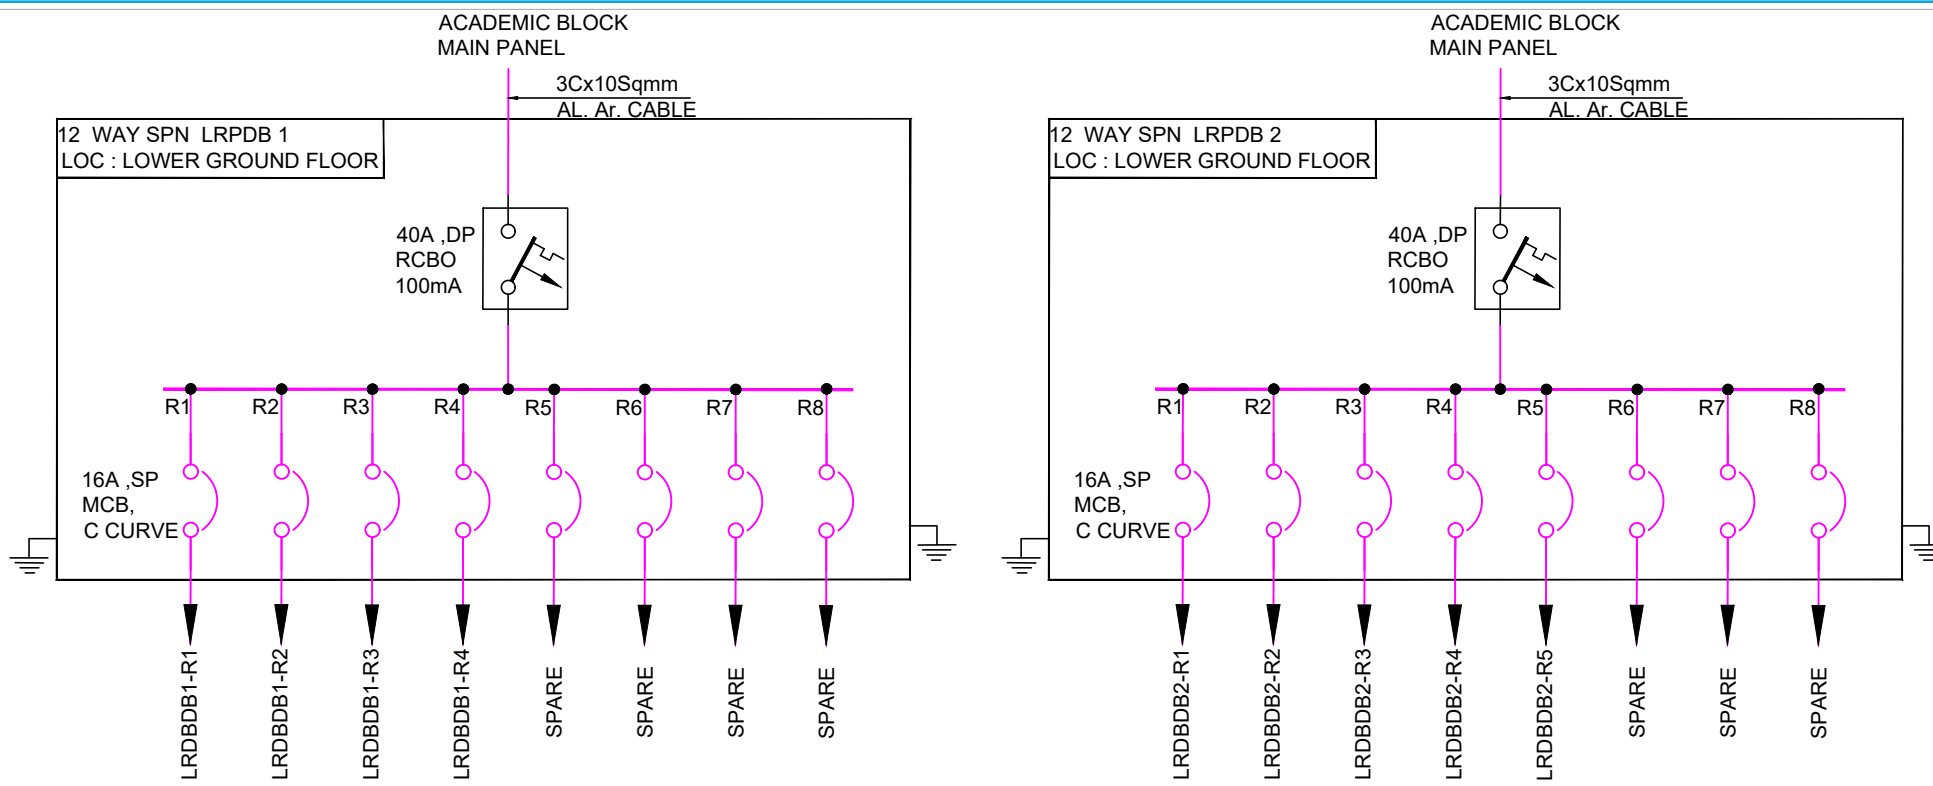

GF

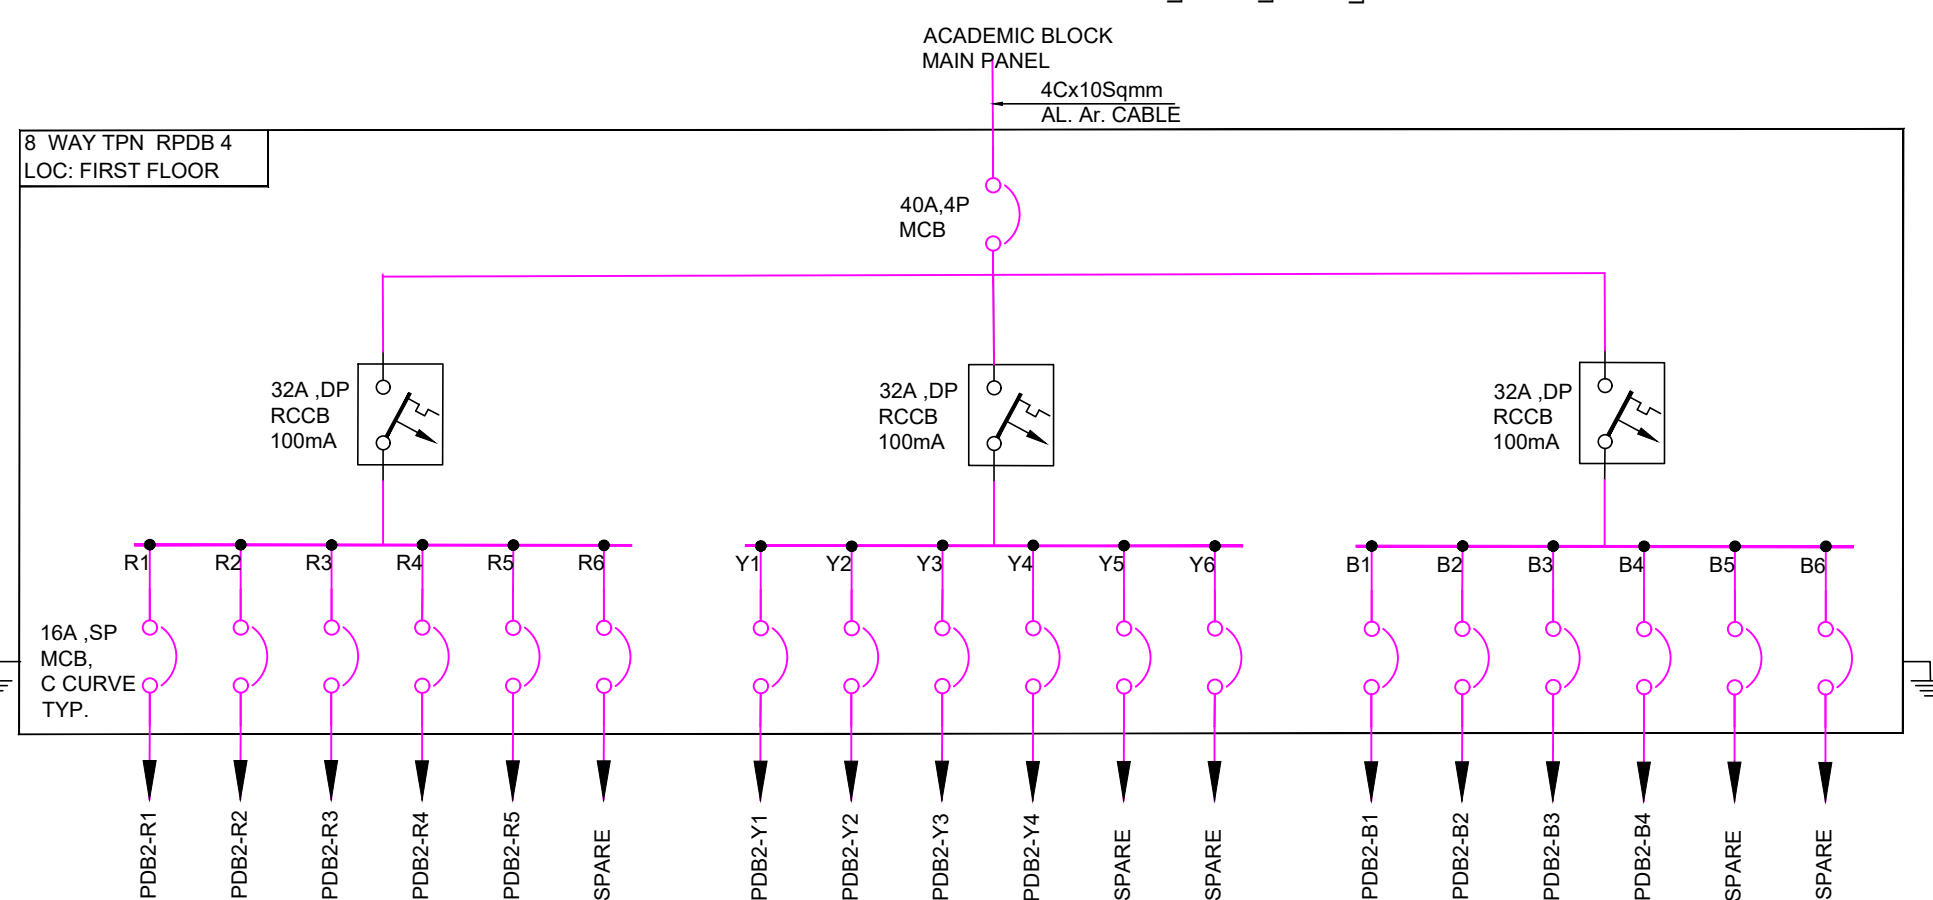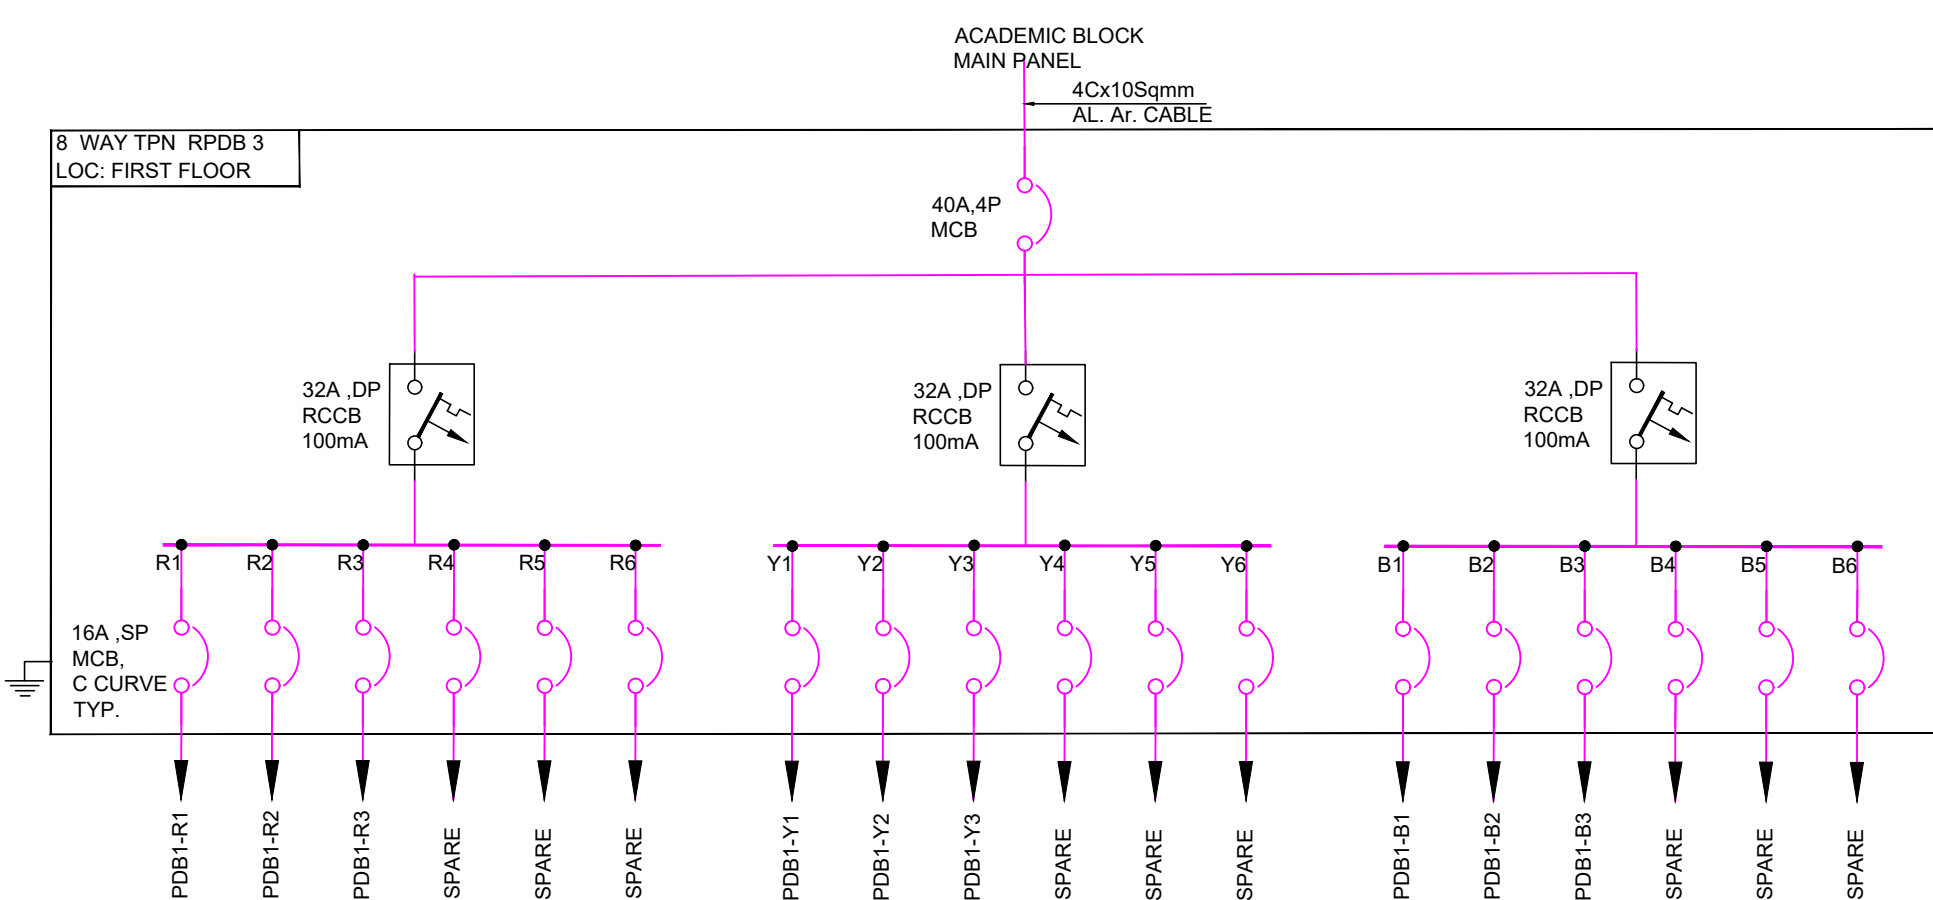

1F

KEYPLAN :-

ISSUALS

REVISIONS

OWNER'S NAME :-

CLIENT :-

NLSIU BENGALURU

PROJECT ARCHITECT:-

DCOOP

ARCHITECTURE.DESIGN.RESEARCH

UNIT NO. 109, 1ST FLOOR, SWASTIK CHAMBERS,  
SG BARVE ROAD, CHEMBUR, MUMBAI - 400071  
PH: 24706945/46 E-MAIL: mail@dcop.in

OFFICE SEAL :-

MEP & SUSTAINABILITY CONSULTANT :-



Mc D Built Environment Research Laboratory Pvt Ltd,  
Green building,Sustainability and MEP services,  
No 12,Subramanya Arcade, Tower B , Opposite to Jalbhavan, Old  
Gurappanapalya, BTM 1st stage ,Bannerghita road ,Bangalore-560 029.  
Ph:+91 80 41222020,URL: www.mcdberl.com

PROJECT TITLE :-

NLSIU BENGALURU

TENDER STAGE

DRAWING TITLE :-



DB DETAILS

PHASE	:	BLOCK	:	SCALE	:
DESIGNED	:	RS	:	DATE	:
DRAWN	:	RS	:	APPROVED	:
CHECKED	:	MEGHANA	:	SHEET	:
DWG NO	:	TD-E-PWR-DB-201	:	REV NO:	:
					R1



This drawing is the property of Mc D Built environment research laboratory Pvt Ltd, no part of the drawing may be reproduced in any manner whatsoever without permission from McD berl Pvt Ltd.




2F

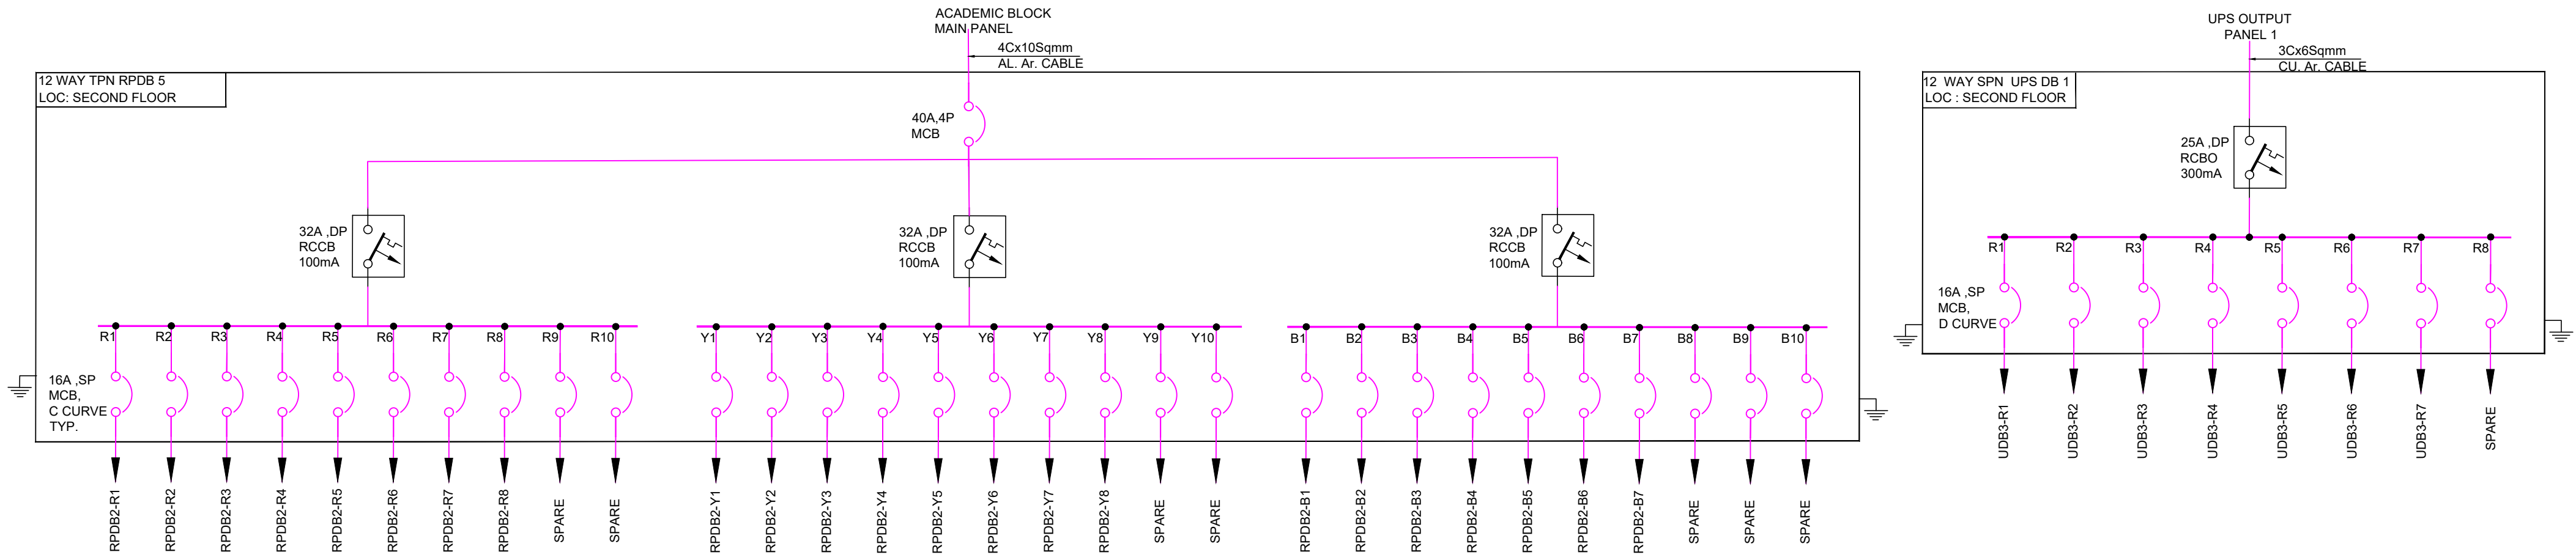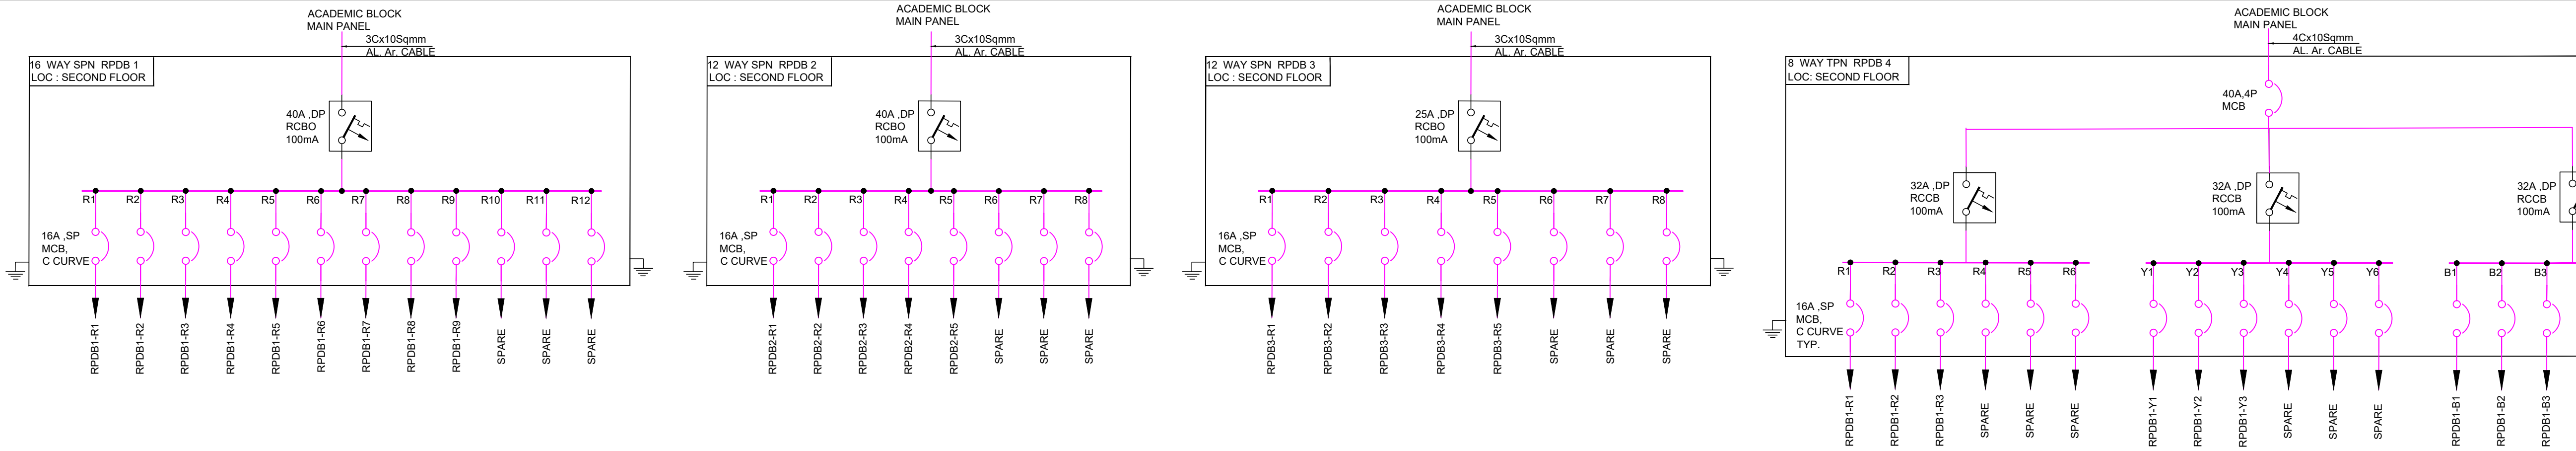

3F

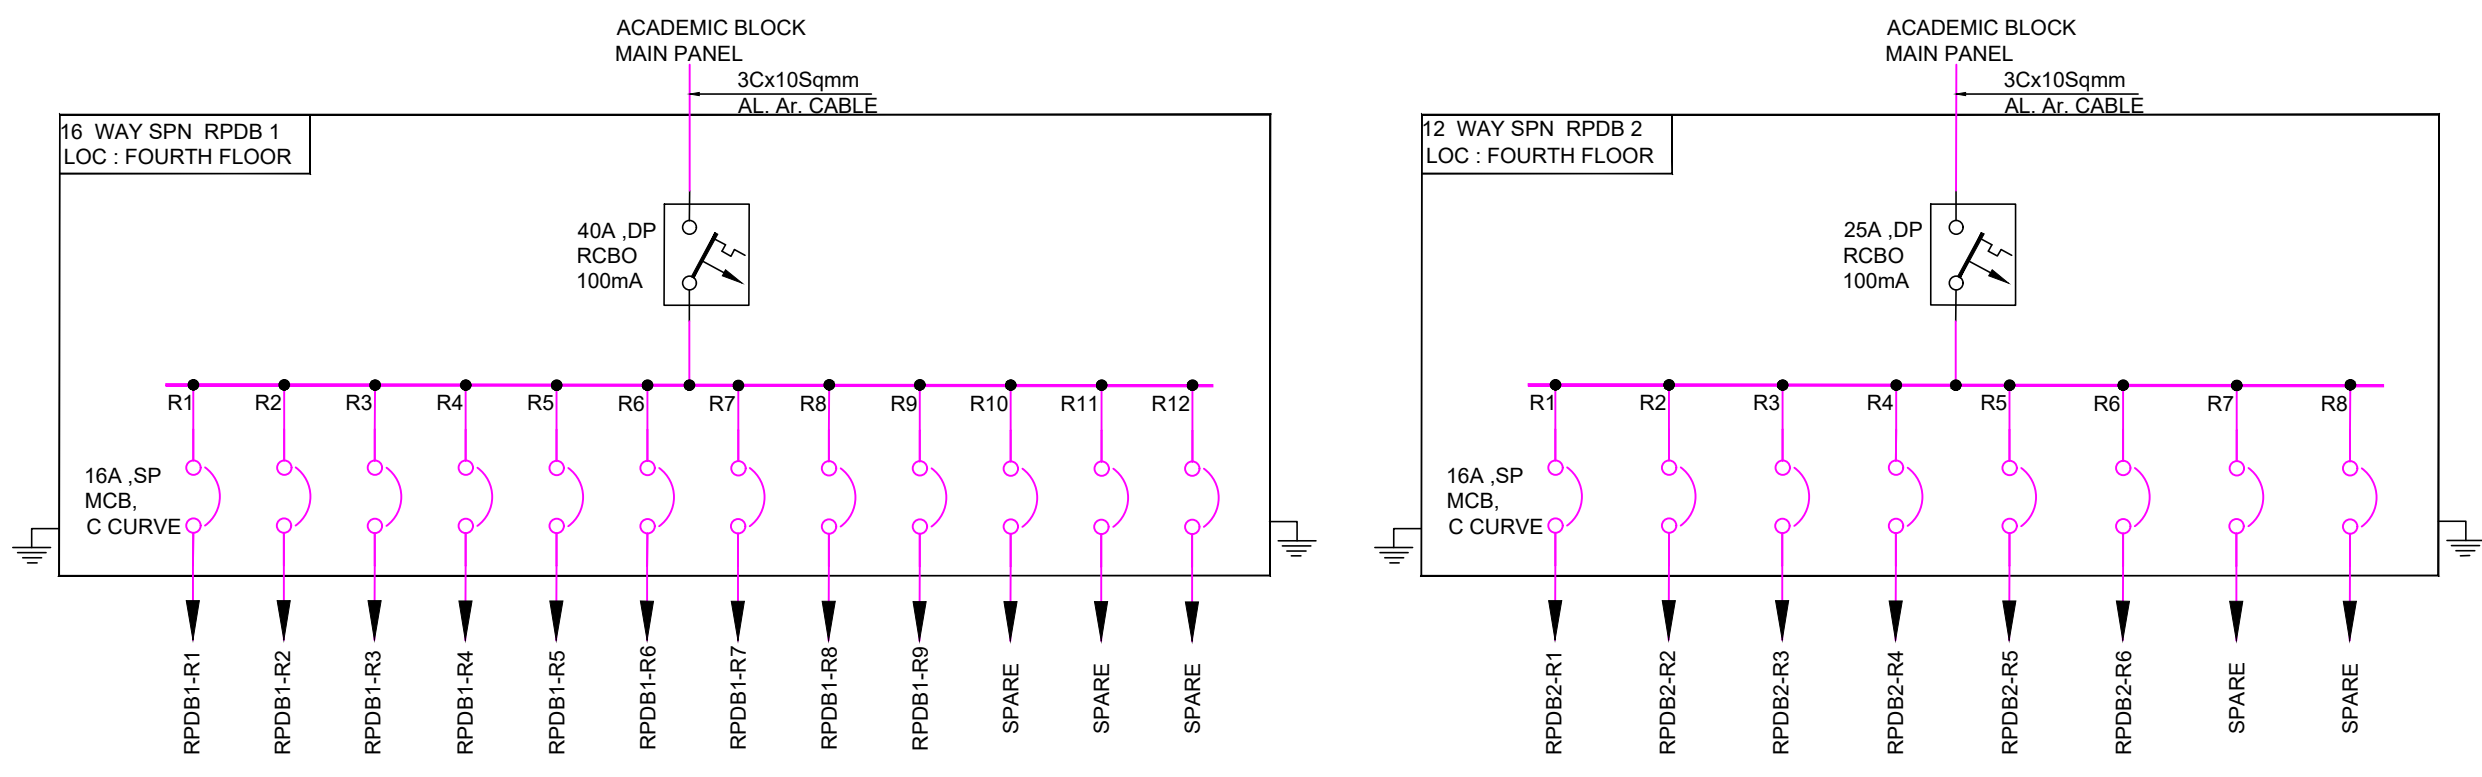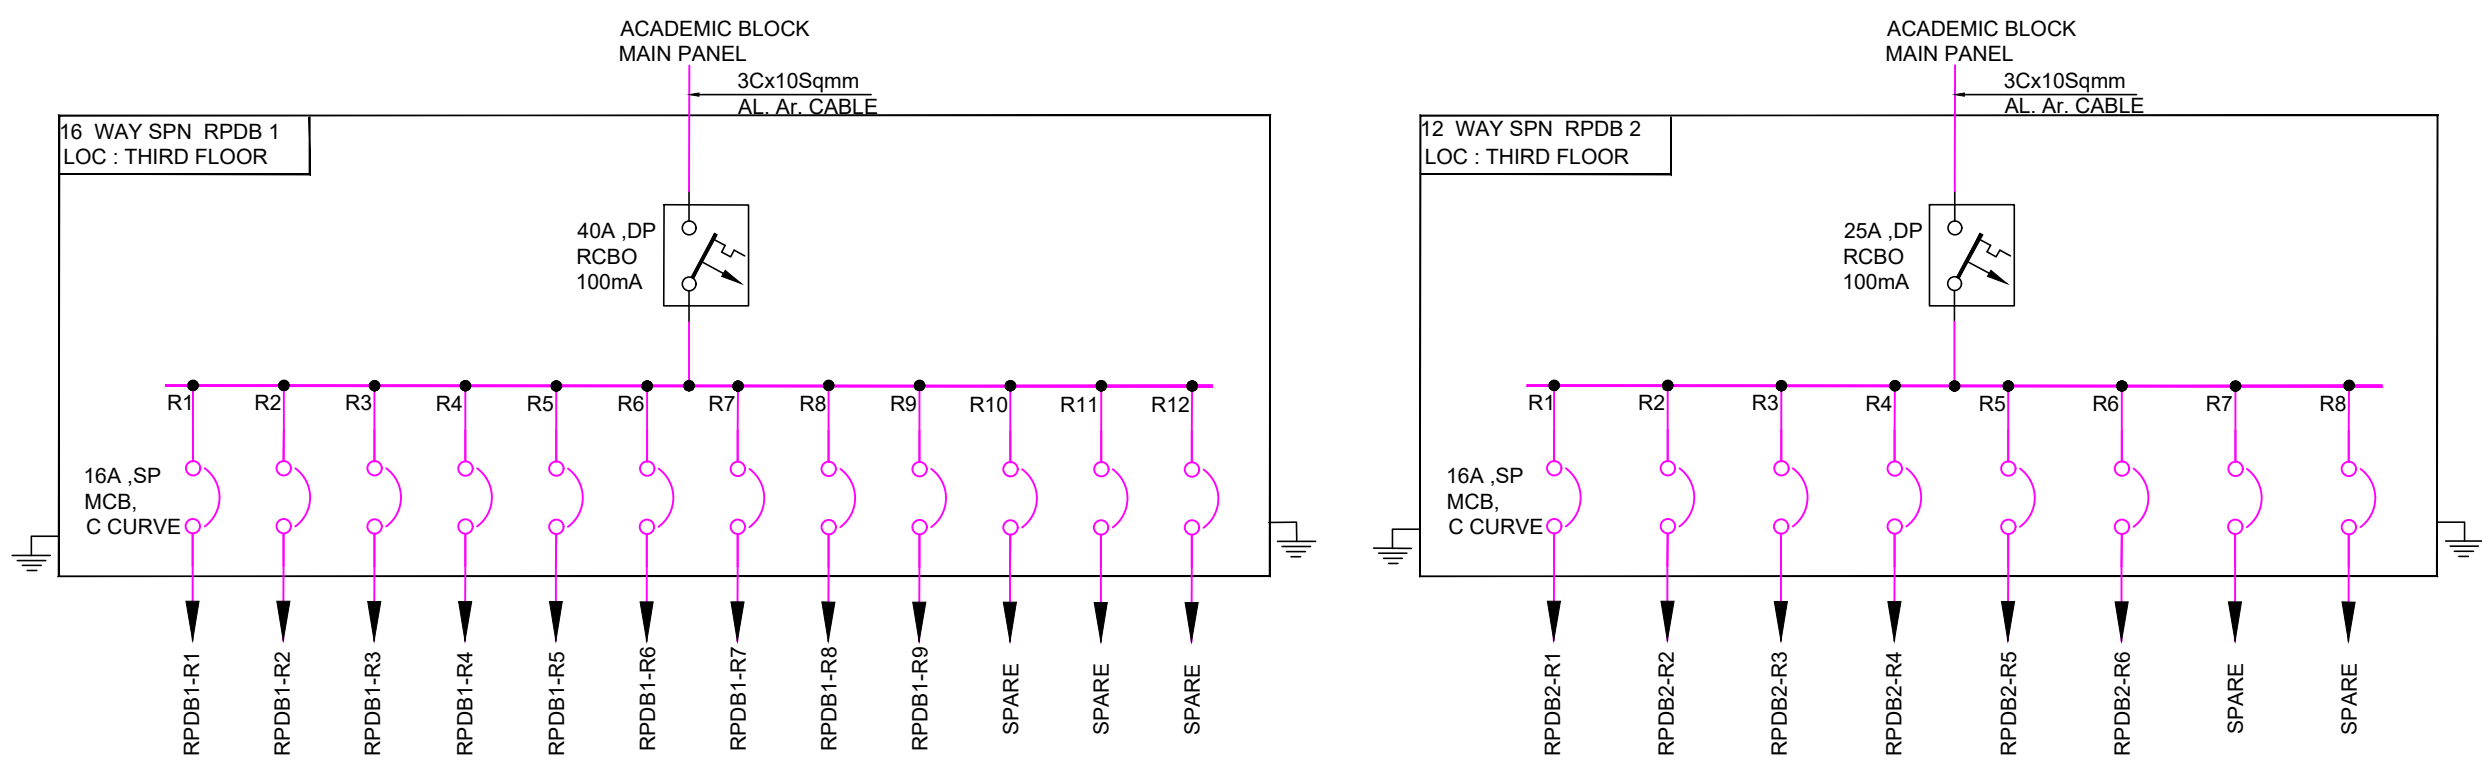

4F

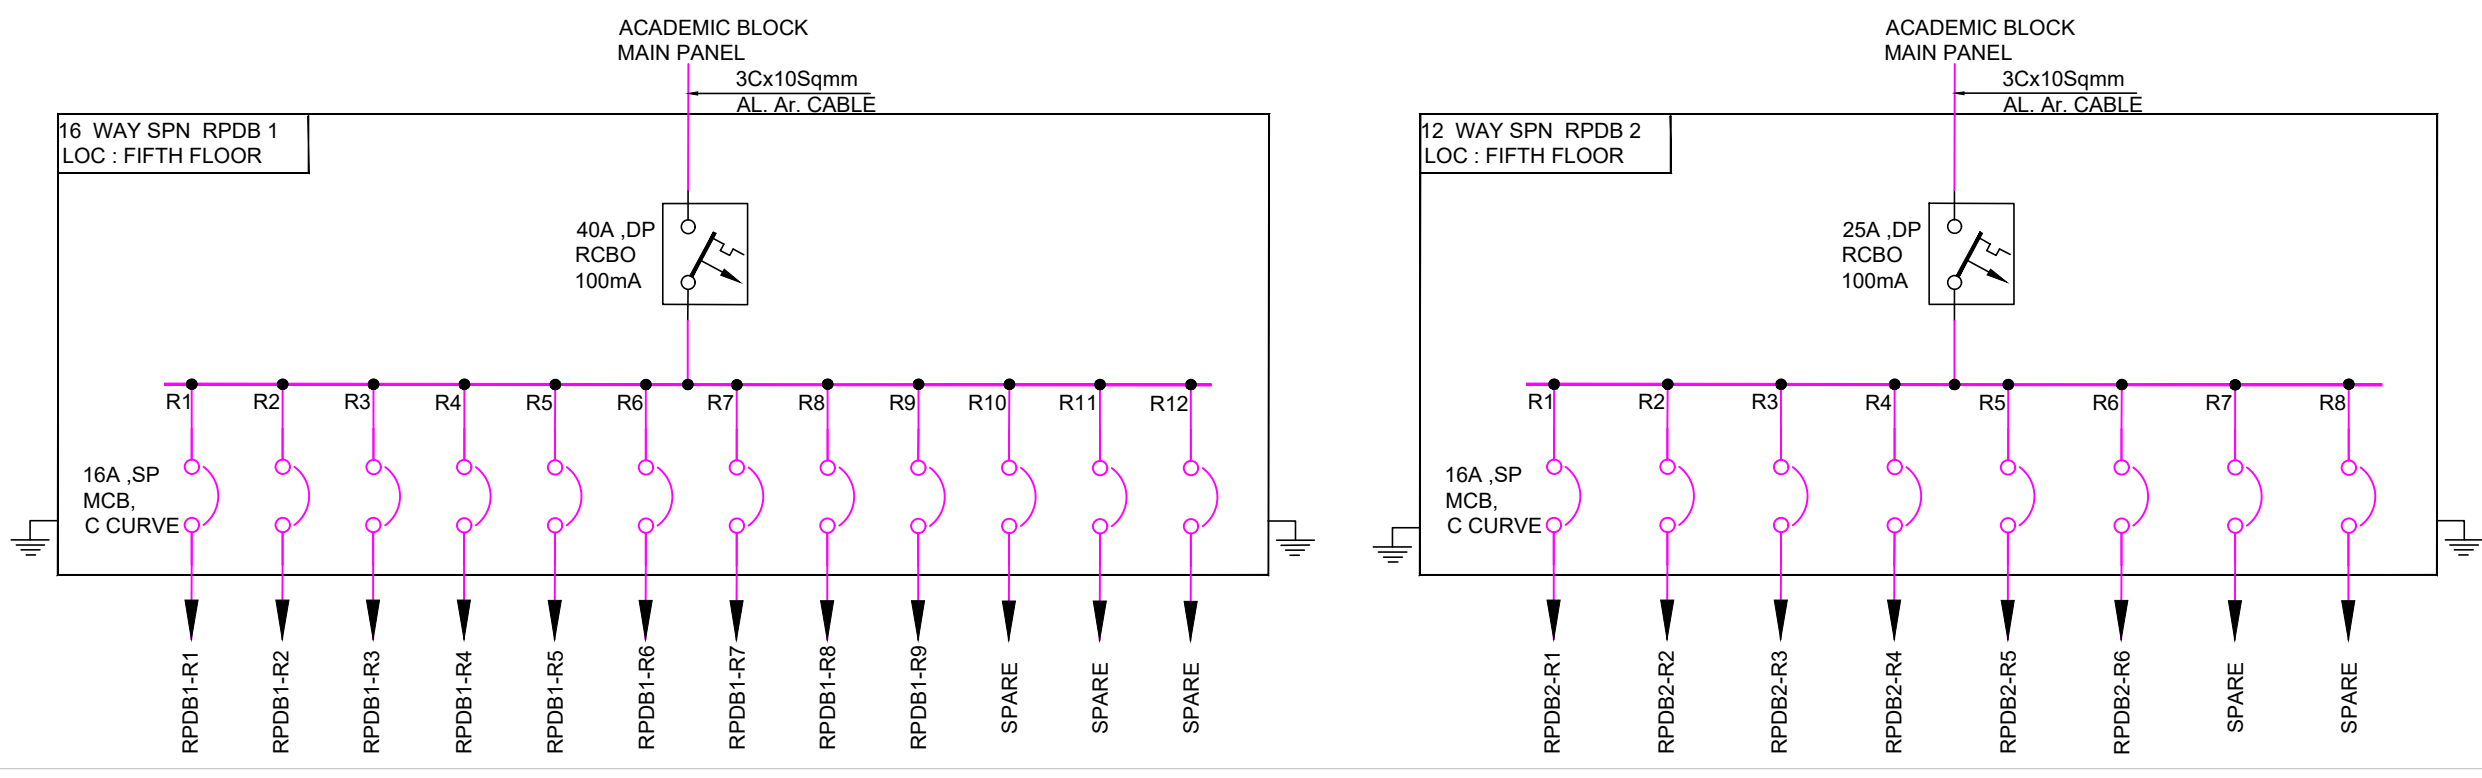

5F

KEYPLAN :-

ISSUALS

REVISIONS

OWNER'S NAME :-

CLIENT :-

NLSIU BENGALURU

PROJECT ARCHITECT:-

DCCOP

ARCHITECTURE.DESIGN.RESEARCH

UNIT NO. 109, 1ST FLOOR, SWASTIK CHAMBERS,  
SG BARVE ROAD, CHEMBUR, MUMBAI - 400071  
PH: 24706945/46 E-MAIL: mail@dcoop.in

OFFICE SEAL :-

MEP & SUSTAINABILITY CONSULTANT :-



Mc D Built Environment Research Laboratory Pvt Ltd,  
Green building,Sustainability and MEP services,  
No 12,Subramanya Arcade, Tower B , Opposite to Jalbhavan, Old  
Gurappanapalya ,BTM 1st stage ,Bannerghita road ,Bangalore-560 029.  
Ph:+91 80 41222020,URL: www.mcdberl.com

PROJECT TITLE :-

NLSIU BENGALURU

TENDER STAGE

DRAWING TITLE :-

DB DETAILS

PHASE	:	BLOCK	:	SCALE	:
DESIGNED	:	RS	:	DATE	:
DRAWN	:	RS	:	APPROVED	:
CHECKED	:	MEGHANA	:	SHEET	:
DWG NO	:	TD-E-PWR-DB-202	:	REV NO:	:
				R1	

This drawing is the property of Mc D Built environment research laboratory Pvt Ltd, no part of the drawing may be reproduced in any manner whatsoever without permission from McD berl Pvt Ltd.




# **ELECTRICAL TENDER DRAWINGS - FLOOR RACEWAY**

**OAB REDEVELOPMENT, NLSIU, BENGALURU**

Dec 2024



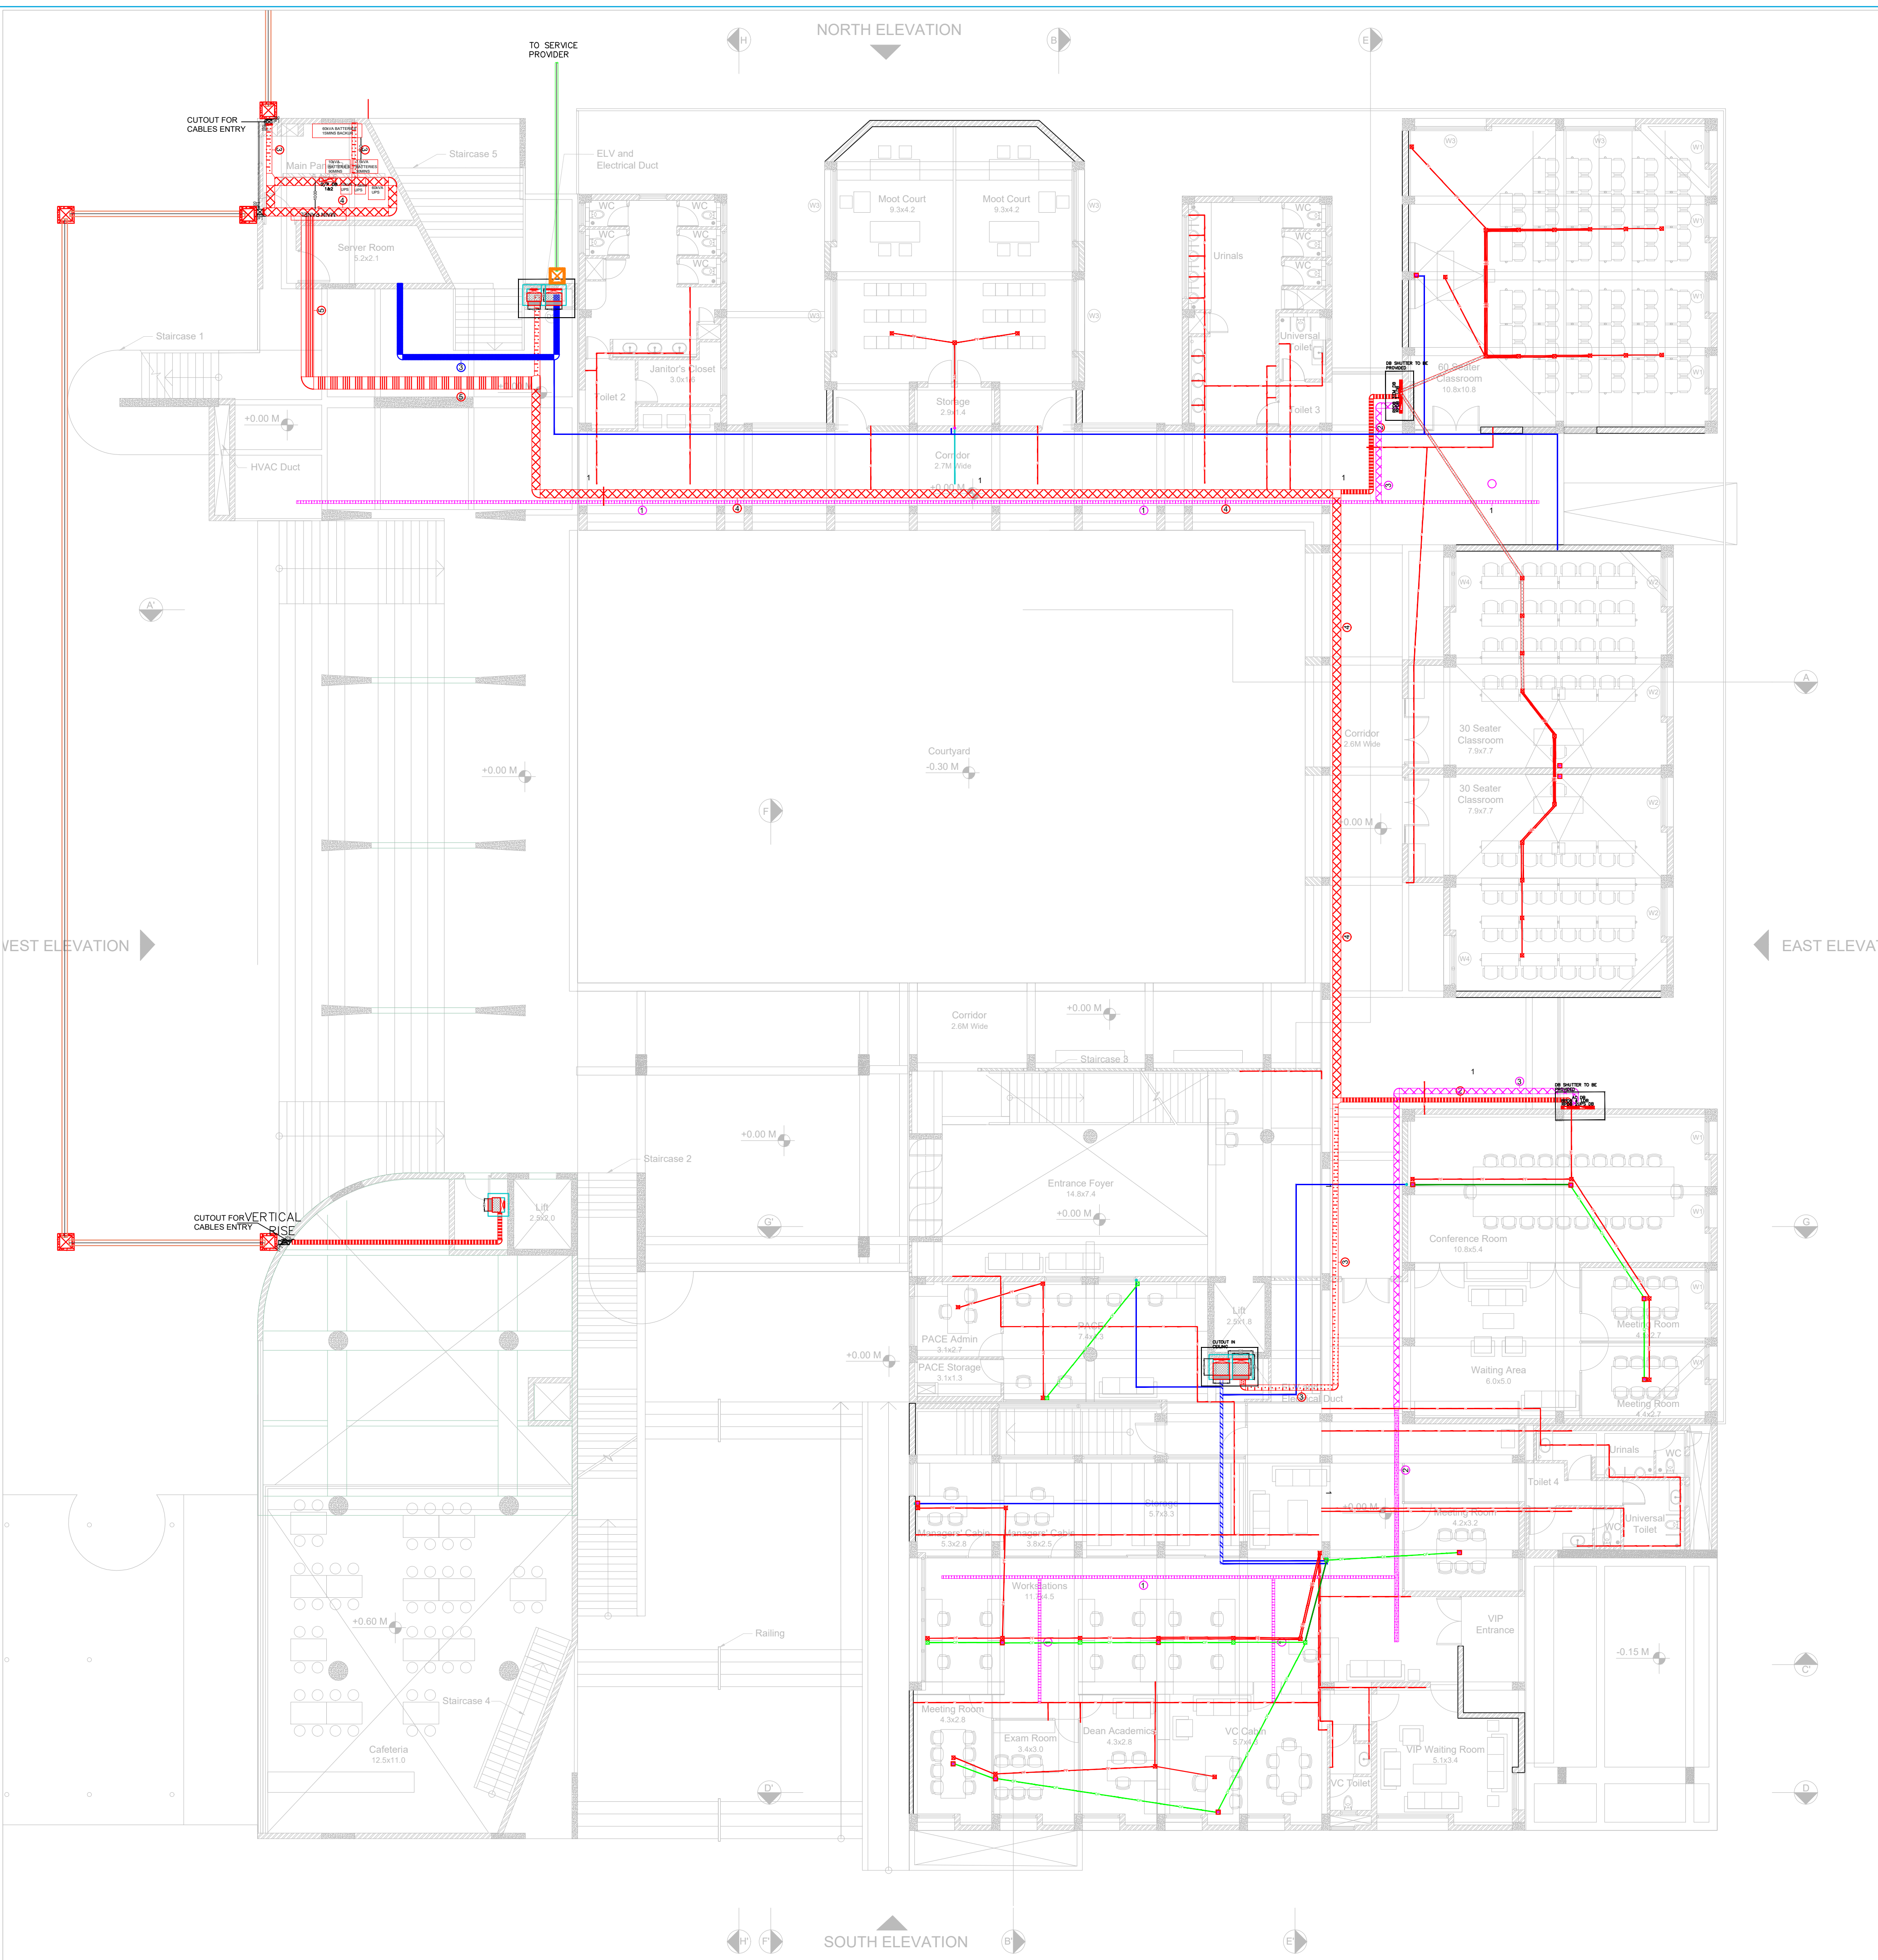

DATA FLOOR RACEWAY-LEGEND		
NO	SYMBOL	SERVICE DESCRIPTION
01		DATA 100x40mm GI FLOOR RACEWAY
02		DATA 150x40mm GI FLOOR RACEWAY
03		DATA 200x40mm GI FLOOR RACEWAY
04		DATA 300x40mm GI FLOOR RACEWAY
05		DATA 450x40mm GI FLOOR RACEWAY
06		DATA 125x125x50mm GI JUNCTION BOX
07		DATA 175x175x50mm GI JUNCTION BOX
08		DATA 225x225x50mm GI JUNCTION BOX
09		DATA 325x325x50mm GI JUNCTION BOX
10		DATA 32MMø FLOOR DATA CONDUIT
11		DATA 25MMø FLOOR DATA CONDUIT

ELECTRICAL FLOOR RACEWAY-LEGEND		
NO	SYMBOL	SERVICE DESCRIPTION
01		EB 100x40mm GI FLOOR RACEWAY
02		EB 150x40mm GI FLOOR RACEWAY
03		EB 200x40mm GI FLOOR RACEWAY
04		EB 300x40mm GI FLOOR RACEWAY
05		EB 450x40mm GI FLOOR RACEWAY
06		EB 125x125x50mm GI JUNCTION BOX
07		EB 175x175x50mm GI JUNCTION BOX
08		EB 225x225x50mm GI JUNCTION BOX
09		EB 325x325x50mm GI JUNCTION BOX
10		EB 32MMø FLOOR POWER CONDUIT
11		EB 25MMø FLOOR POWER CONDUIT

KEYPLAN :-

ISSUALS

R0	TENDER STAGE	11.12.2024	RS
REVISIONS			

OWNER'S NAME :-

CLIENT :-

NLSIU BENGALURU

PROJECT ARCHITECT:-

**DCOOP**  
ARCHITECTURE.DESIGN.RESEARCH

UNIT NO. 109, 1ST FLOOR, SWASTIK CHAMBERS,  
SG BARVE ROAD, CHEMBUR, MUMBAI - 400071  
PH: 24706945/46 E-MAIL: mail@dcloop.in

OFFICE SEAL :-

MEP & SUSTAINABILITY CONSULTANT :-



Mc D Built Environment Research Laboratory Pvt Ltd,  
Green building,Sustainability and MEP services,  
No 12,Subramanya Arcade, Tower B , Opposite to Jalbhavan, Old  
Gurappanapalya, BTM 1st stage ,Bannerghita road ,Bangalore-560 029.  
Ph:+91 80 41222020,URL: www.mcdberl.com

PROJECT TITLE :-

NLSIU BENGALURU

TENDER STAGE


DRAWING TITLE :-

GROUND FLOOR FLOOR  
RACEWAY LAYOUT

PHASE	:	BLOCK	:	SCALE	:
DESIGNED	:	RS	:	DATE	:
DRAWN	:	RS	:	DATE	:
CHECKED	:	MEGHANA	:	APPROVED	:
	:		:	MEGHANA	:
	:		:	SHEET	:
	:		:	A1	:
	:		:	REV NO:	:
	:		:	R1	:


DWG NO : TD-E-FRW-201  
This drawing is the property of Mc D Built environment research  
laboratory Pvt Ltd, no part of the drawing may be reproduced in  
any manner whatsoever without permission from McD berl Pvt Ltd.



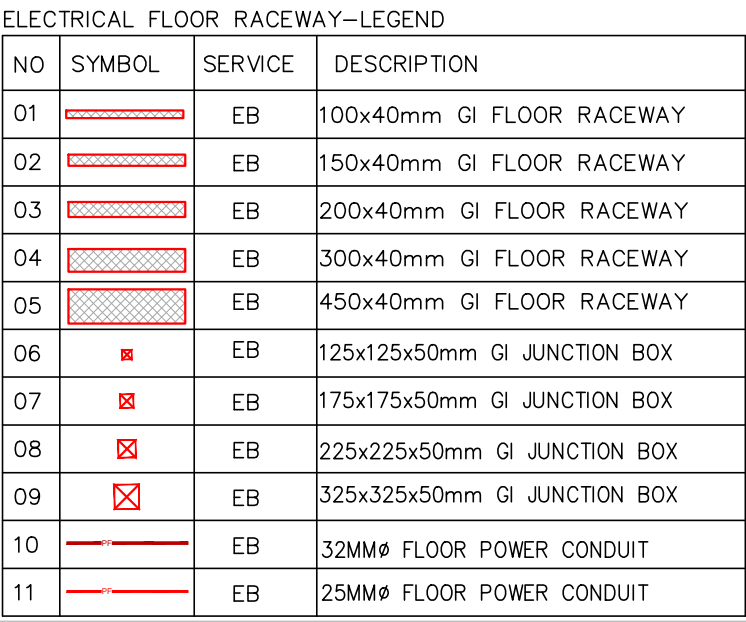

This drawing is the property of Mc D Built environment research laboratory Pvt Ltd, no part of the drawing may be reproduced in any manner whatsoever without permission from McD berl Pvt Ltd



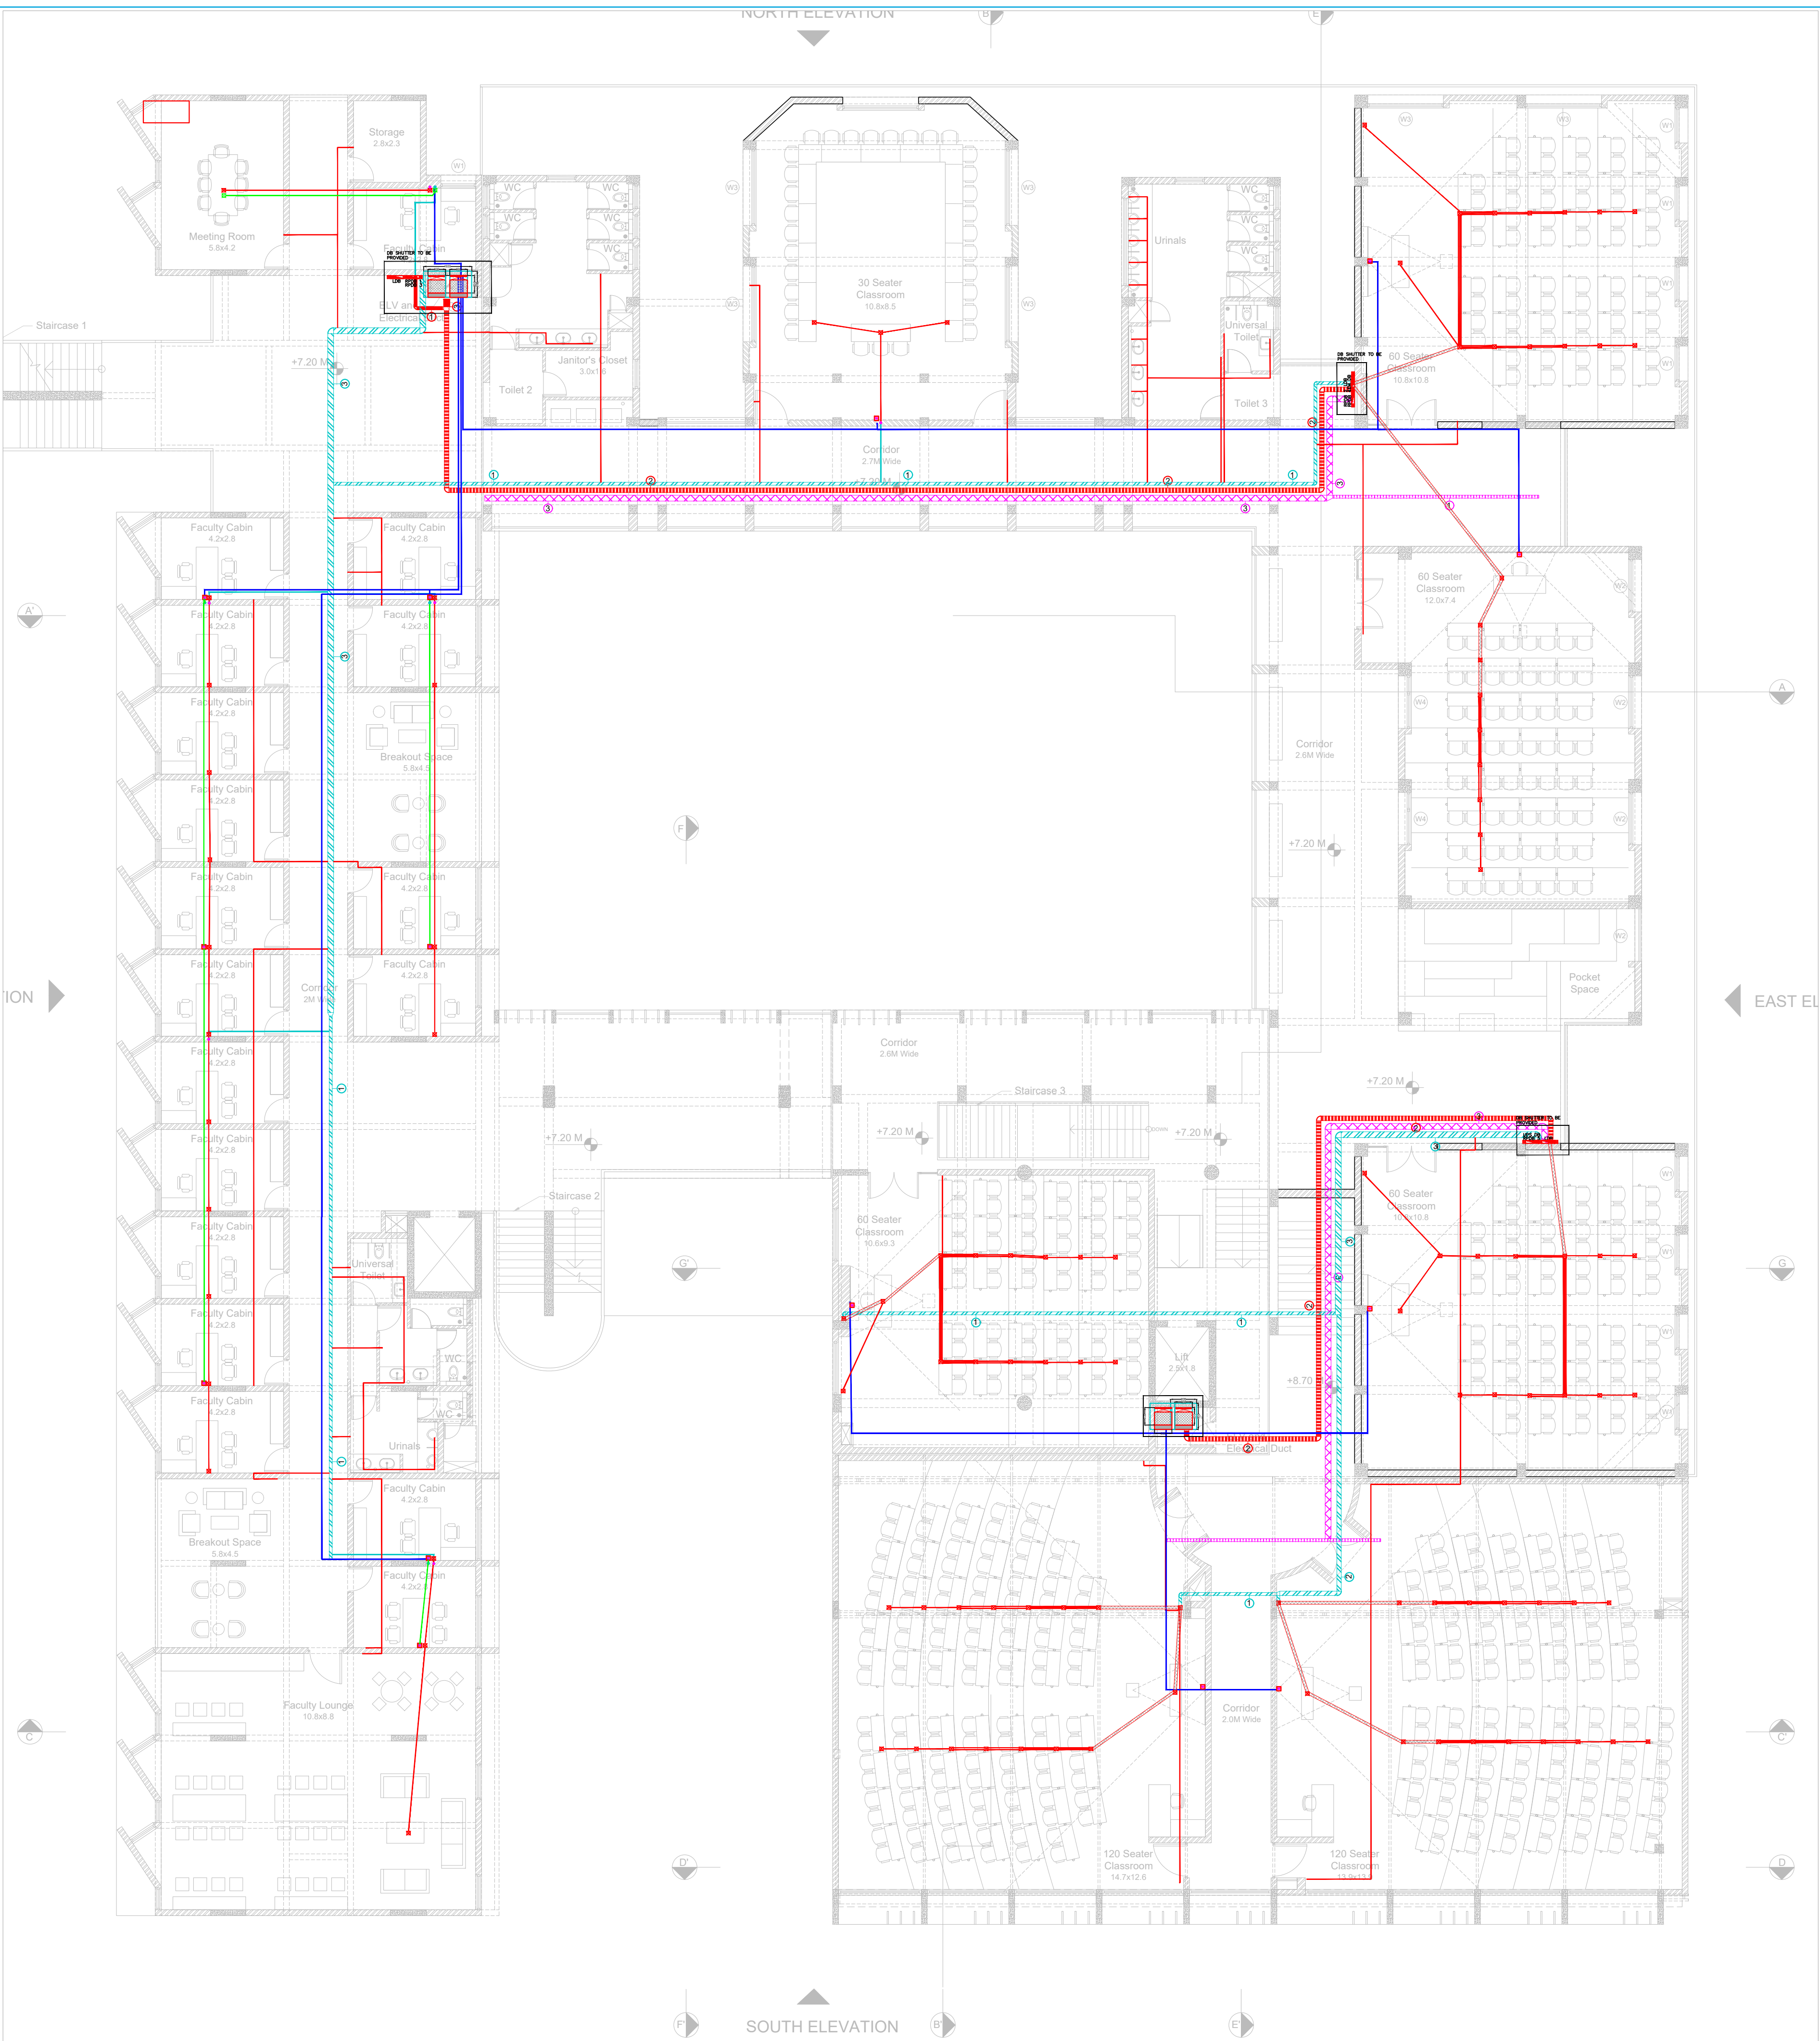

DATA FLOOR RACEWAY-LEGEND		
NO	SYMBOL	SERVICE DESCRIPTION
01		DATA 100x40mm GI FLOOR RACEWAY
02		DATA 150x40mm GI FLOOR RACEWAY
03		DATA 200x40mm GI FLOOR RACEWAY
04		DATA 300x40mm GI FLOOR RACEWAY
05		DATA 450x40mm GI FLOOR RACEWAY
06		DATA 125x125x50mm GI JUNCTION BOX
07		DATA 175x175x50mm GI JUNCTION BOX
08		DATA 225x225x50mm GI JUNCTION BOX
09		DATA 325x325x50mm GI JUNCTION BOX
10		DATA 32MM# FLOOR DATA CONDUIT
11		DATA 25MM# FLOOR DATA CONDUIT

ELECTRICAL FLOOR RACEWAY-LEGEND		
NO	SYMBOL	SERVICE DESCRIPTION
01		EB 100x40mm GI FLOOR RACEWAY
02		EB 150x40mm GI FLOOR RACEWAY
03		EB 200x40mm GI FLOOR RACEWAY
04		EB 300x40mm GI FLOOR RACEWAY
05		EB 450x40mm GI FLOOR RACEWAY
06		EB 125x125x50mm GI JUNCTION BOX
07		EB 175x175x50mm GI JUNCTION BOX
08		EB 225x225x50mm GI JUNCTION BOX
09		EB 325x325x50mm GI JUNCTION BOX
10		EB 32MM# FLOOR POWER CONDUIT
11		EB 25MM# FLOOR POWER CONDUIT

KEYPLAN :-

ISSUALS

R0	TENDER STAGE	11.12.2024	RS
REVISIONS			

OWNER'S NAME :-

NLSIU BENGALURU

CLIENT :-

PROJECT ARCHITECT:-

**DCOOP**  
ARCHITECTURE.DESIGN.RESEARCH

UNIT NO. 109, 1ST FLOOR, SWASTIK CHAMBERS,  
SG BARVE ROAD, CHEMBUR, MUMBAI - 400071  
PH: 24706945/46 E-MAIL: mail@dcop.in

OFFICE SEAL :-

MEP & SUSTAINABILITY CONSULTANT :-



Mc D Built Environment Research Laboratory Pvt Ltd,  
Green building,Sustainability and MEP services,  
No 12,Subramanya Arcade, Tower B , Opposite to Jalbhavan, Old  
Gurappanapalya, BTM 1st stage ,Bannerghita road ,Bangalore-560 029.  
Ph:+91 80 41222020,URL: www.mcdberl.com

PROJECT TITLE :-

NLSIU BENGALURU

TENDER STAGE

DRAWING TITLE :-


SECOND FLOOR FLOOR  
RACEWAY LAYOUT

PHASE	:	BLOCK	:	SCALE	:
DESIGNED	:	RS	:	DATE	:
DRAWN	:	RS	:	APPROVED	:
CHECKED	:	MEGHANA	:	SHEET	:
				A1	R1

DWG NO : TD-E-FRW-203

This drawing is the property of Mc D Built environment research  
laboratory Pvt Ltd, no part of the drawing may be reproduced in  
any manner whatsoever without permission from McD berl Pvt Ltd.



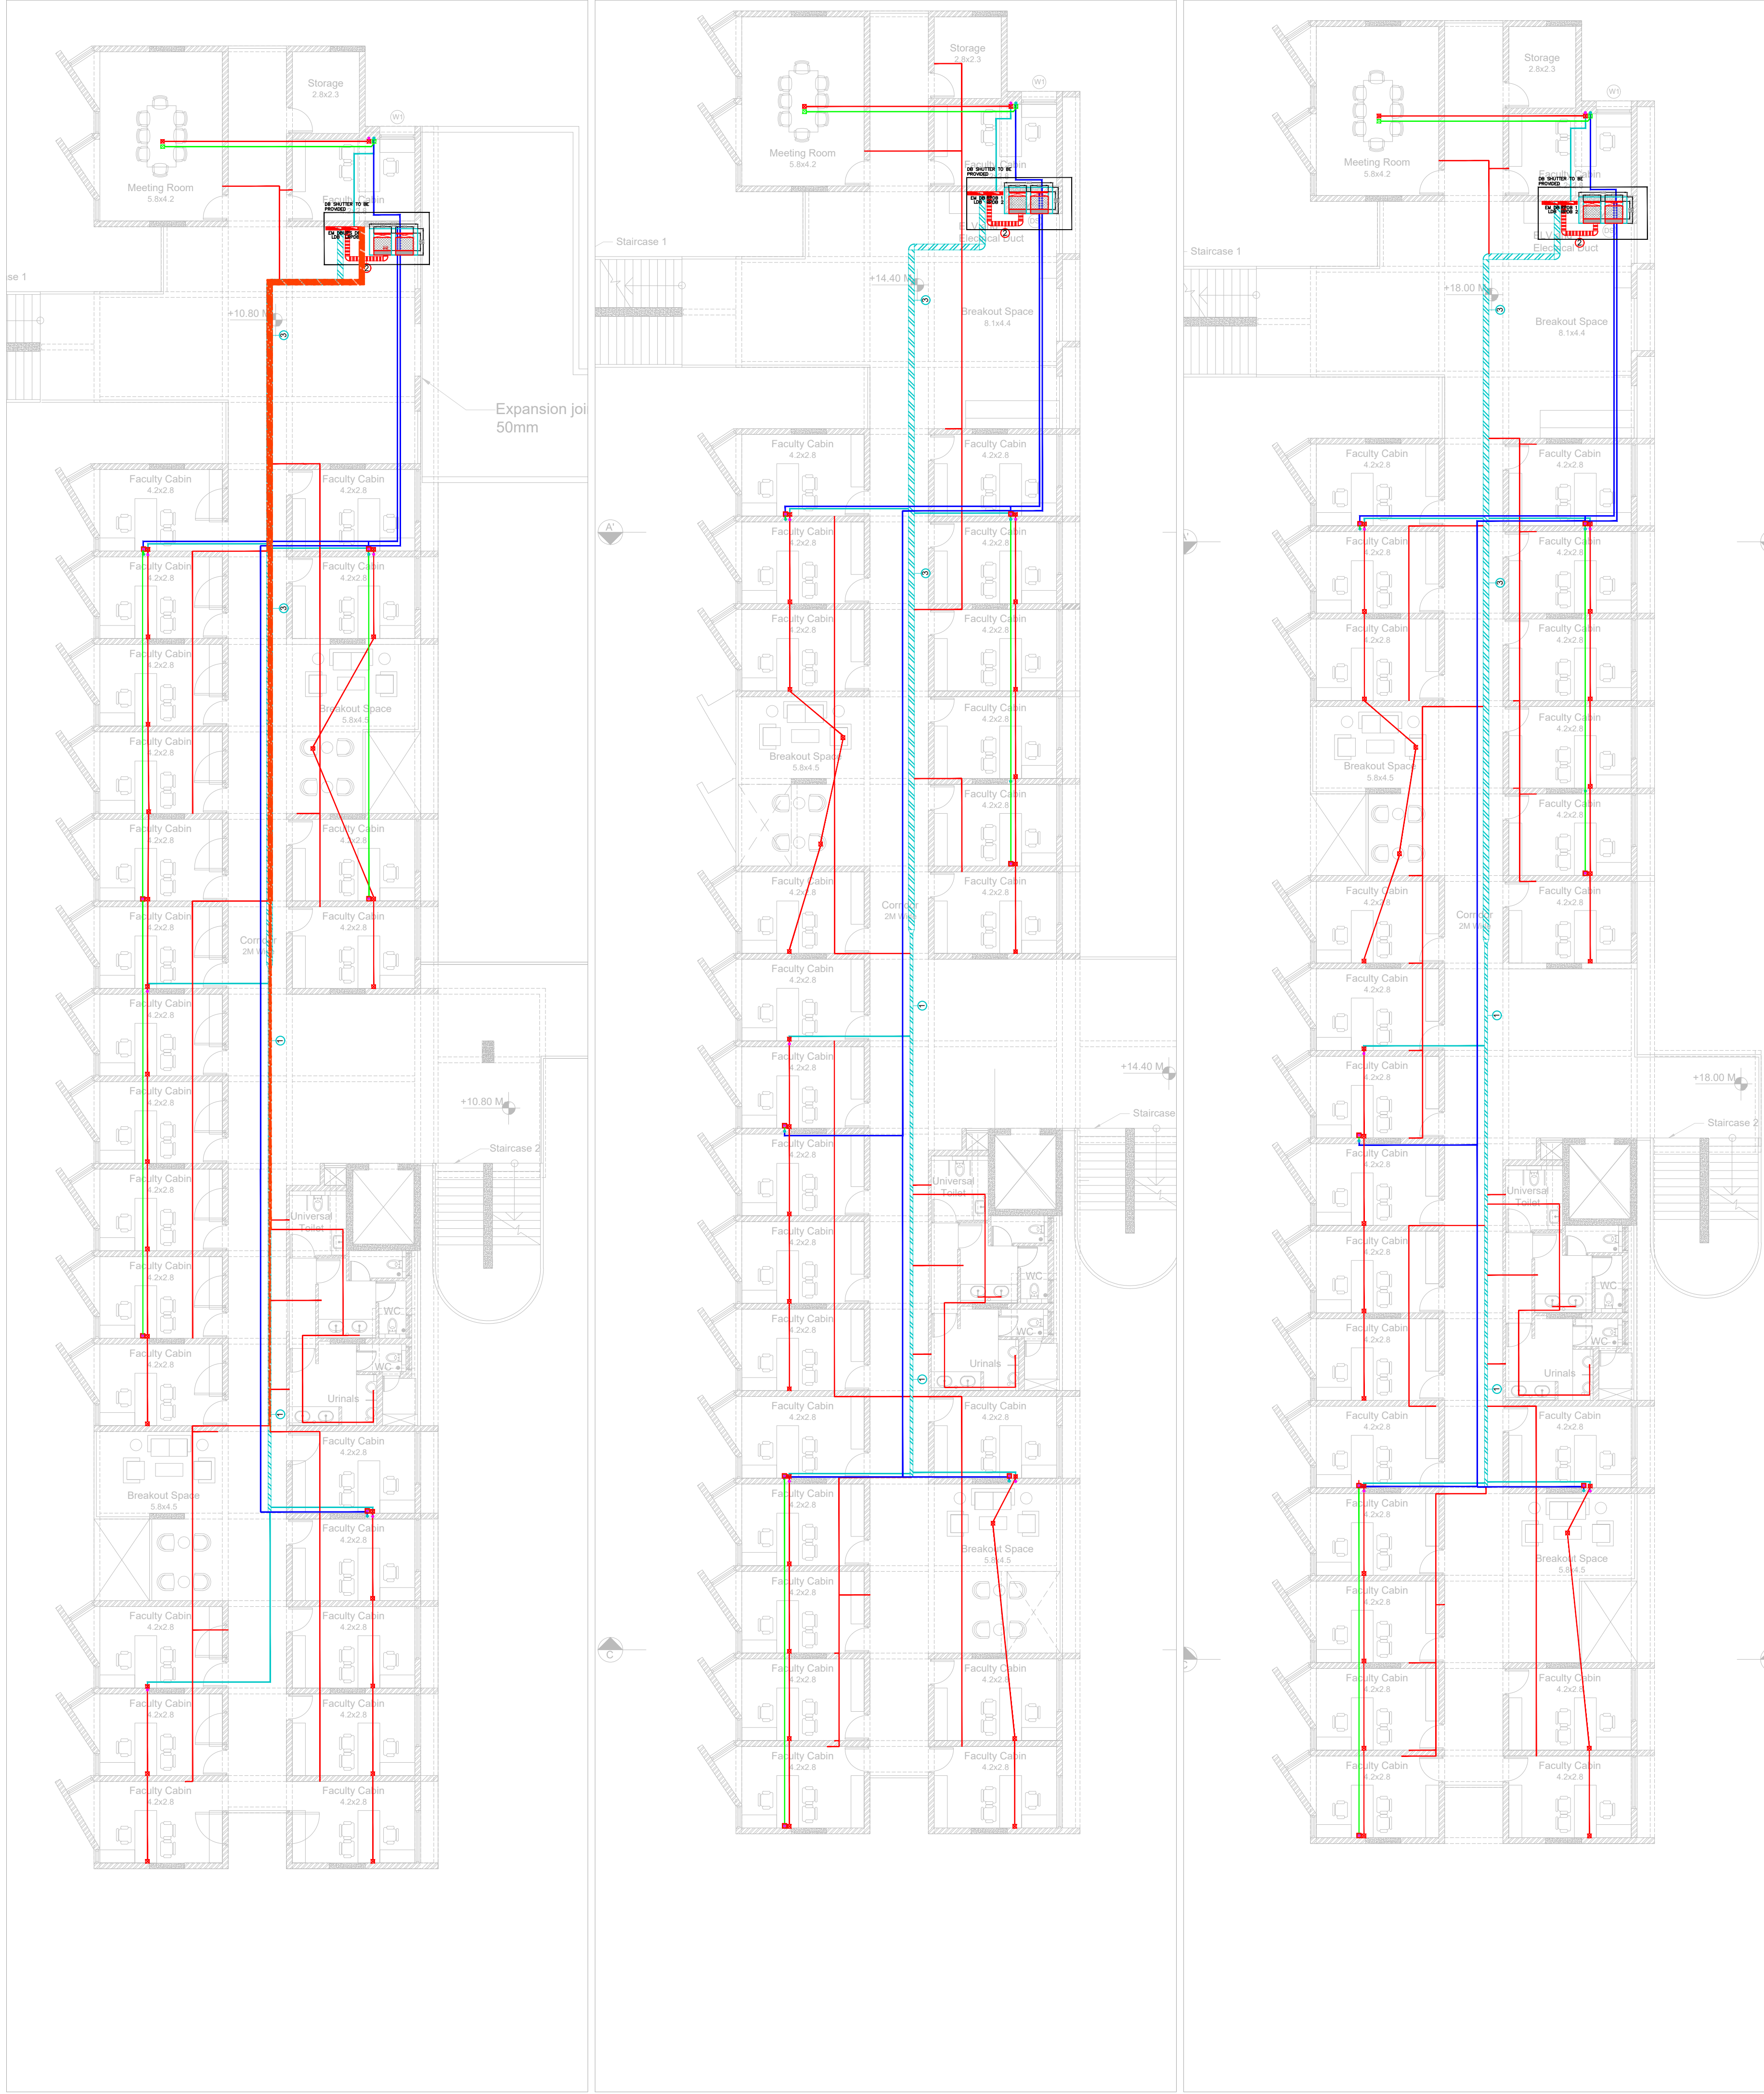

DATA FLOOR RACEWAY-LEGEND			
NO	SYMBOL	SERVICE	DESCRIPTION
01		DATA	100x40mm GI FLOOR RACEWAY
02		DATA	150x40mm GI FLOOR RACEWAY
03		DATA	200x40mm GI FLOOR RACEWAY
04		DATA	300x40mm GI FLOOR RACEWAY
05		DATA	450x40mm GI FLOOR RACEWAY
06		DATA	125x125x50mm GI JUNCTION BOX
07		DATA	175x175x50mm GI JUNCTION BOX
08		DATA	225x225x50mm GI JUNCTION BOX
09		DATA	325x325x50mm GI JUNCTION BOX
10		DATA	32MMø FLOOR DATA CONDUIT
11		DATA	25MMø FLOOR DATA CONDUIT

ELECTRICAL FLOOR RACEWAY-LEGEND			
NO	SYMBOL	SERVICE	DESCRIPTION
01		EB	100x40mm GI FLOOR RACEWAY
02		EB	150x40mm GI FLOOR RACEWAY
03		EB	200x40mm GI FLOOR RACEWAY
04		EB	300x40mm GI FLOOR RACEWAY
05		EB	450x40mm GI FLOOR RACEWAY
06		EB	125x125x50mm GI JUNCTION BOX
07		EB	175x175x50mm GI JUNCTION BOX
08		EB	225x225x50mm GI JUNCTION BOX
09		EB	325x325x50mm GI JUNCTION BOX
10		EB	32MMø FLOOR POWER CONDUIT
11		EB	25MMø FLOOR POWER CONDUIT

KEYPLAN :-

ISSUALS

R0	TENDER STAGE	11.12.2024	RS
REVISIONS			

OWNER'S NAME :-

CLIENT :-

NLSIU BENGALURU

PROJECT ARCHITECT:-

**DCOOP**  
ARCHITECTURE.DESIGN.RESEARCH

UNIT NO. 109, 1ST FLOOR, SWASTIK CHAMBERS,  
SG BARVE ROAD, CHEMBUR, MUMBAI - 400071  
PH: 24706945/46 E-MAIL: mail@dcop.in

OFFICE SEAL :-

MEP & SUSTAINABILITY CONSULTANT :-



Mc D Built Environment Research Laboratory Pvt Ltd,  
Green building,Sustainability and MEP services,  
No 12,Subramanya Arcade, Tower B , Opposite to Jalbhavan, Old  
Gurappanapalya, BTM 1st stage ,Bannerghita road ,Bangalore-560 029.  
Ph:+91 80 41222020,URL: www.mcdberl.com

PROJECT TITLE :-

NLSIU BENGALURU

TENDER STAGE

DRAWING TITLE :-

THIRD,FOURTH,FIFTH FLOOR  
FLOOR RACEWAY LAYOUT

PHASE	:	BLOCK	:	SCALE	:
DESIGNED	:	RS	:	DATE	:
DRAWN	:	RS	:	APPROVED	:
CHECKED	:	MEGHANA	:	SHEET	:
DWG NO	:	TD-E-FRW-204	:	REV NO:	:
					R1

This drawing is the property of Mc D Built environment research laboratory Pvt Ltd, no part of the drawing may be reproduced in any manner whatsoever without permission from McD berl Pvt Ltd.



# **ELECTRICAL TENDER DRAWINGS - CEILING RACEWAY**


**OAB REDEVELOPMENT, NLSIU, BENGALURU**

Dec 2024







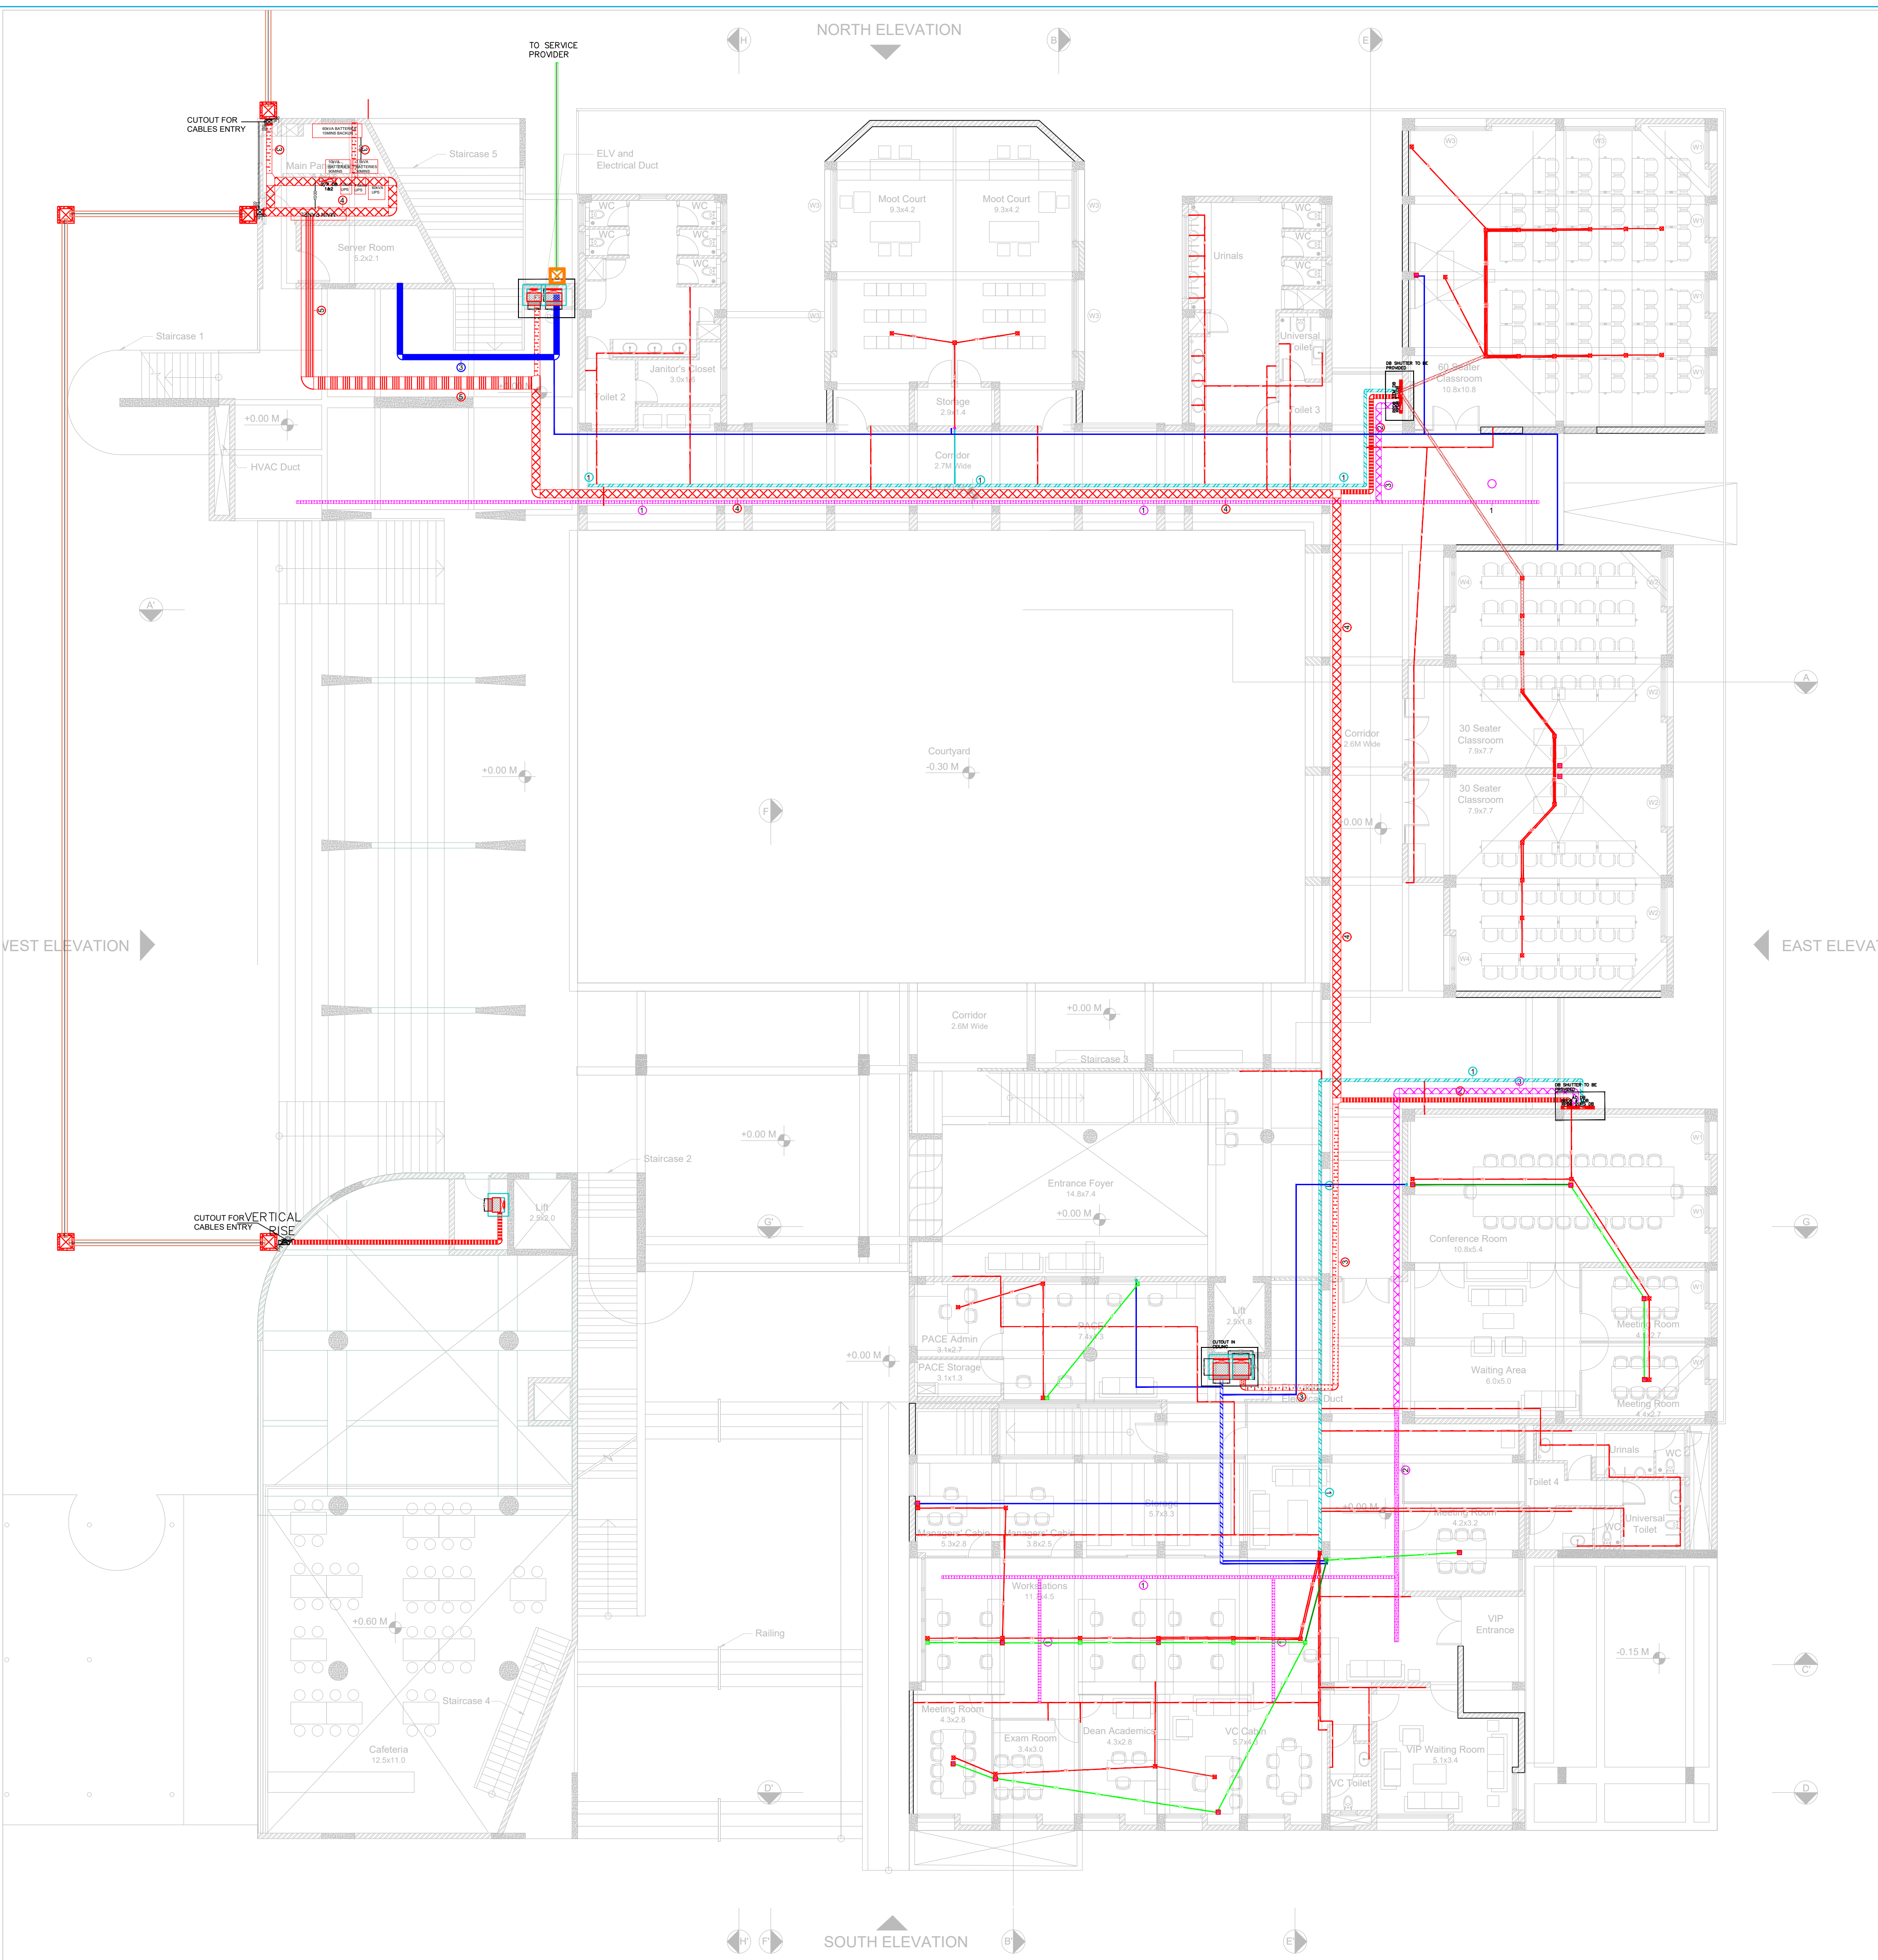

ELECTRICAL CABLE TRAY—LEGEND			
NO	SYMBOL	SERVICE	DESCRIPTION
01		EB	100x50mm PERFORATED TYPE CABLE TRAY
02		EB	150x50mm PERFORATED TYPE CABLE TRAY
03		EB	200x50mm PERFORATED TYPE CABLE TRAY
04		EB	300x50mm PERFORATED TYPE CABLE TRAY
05		EB	450x50mm PERFORATED TYPE CABLE TRAY
06		EB	600x50mm PERFORATED TYPE CABLE TRAY
07		EB	750x50mm PERFORATED TYPE CABLE TRAY

LIGHTING CABLE TRAY—LEGEND			
NO	SYMBOL	SERVICE	DESCRIPTION
01		LIGHTING	100x50mm PERFORATED TYPE CABLE TRAY
02		LIGHTING	150x50mm PERFORATED TYPE CABLE TRAY
03		LIGHTING	200x50mm PERFORATED TYPE CABLE TRAY
04		LIGHTING	300x50mm PERFORATED TYPE CABLE TRAY
05		LIGHTING	450x50mm PERFORATED TYPE CABLE TRAY

ELECTRICAL CEILING RACEWAY—LEGEND			
NO	SYMBOL	SERVICE	DESCRIPTION
01		EB	100x40mm GI CEILING RACEWAY
02		EB	150x40mm GI CEILING RACEWAY
03		EB	200x40mm GI CEILING RACEWAY
04		EB	300x40mm GI CEILING RACEWAY
05		EB	450x40mm GI CEILING RACEWAY
06		EB	32MMØ CEILING POWER CONDUIT
07		EB	25MMØ CEILING POWER CONDUIT

DATA CEILING RACEWAY—LEGEND			
NO	SYMBOL	SERVICE	DESCRIPTION
01		EB	100x40mm GI CEILING RACEWAY
02		EB	150x40mm GI CEILING RACEWAY
03		EB	200x40mm GI CEILING RACEWAY
04		EB	300x40mm GI CEILING RACEWAY
05		EB	450x40mm GI CEILING RACEWAY
06		EB	32MMØ CEILING DATA CONDUIT
07		EB	25MMØ CEILING DATA CONDUIT

KEYPLAN :-

ISSUALS

R0

TENDER STAGE

11.12.2024

RS

REVISIONS

OWNER'S NAME :-

CLIENT :-

NLSIU BENGALURU

PROJECT ARCHITECT:-  
DCOOP  
ARCHITECTURE.DESIGN.RESEARCH  
UNIT NO. 109, 1ST FLOOR, SWASTIK CHAMBERS,  
SG BARVE ROAD, CHEMBUR, MUMBAI - 400071  
PH: 24706945/46 E-MAIL: mail@dcop.in

OFFICE SEAL :-

MEP & SUSTAINABILITY CONSULTANT :-  
  
Mc D Built Environment Research Laboratory Pvt Ltd,  
Green building,Sustainability and MEP services,  
No 12,Subramanya Arcade, Tower B , Opposite to Jalbhavan, Old  
Gurappanapalya, BTM 1st stage ,Bannerghita road ,Bangalore-560 029.  
Ph:+91 80 41222020,URL: www.mcdberl.com

PROJECT TITLE :-

NLSIU BENGALURU

TENDER STAGE

DRAWING TITLE :-


GROUND FLOOR CEILING  
RACEWAY LAYOUT

PHASE	:	BLOCK	:	SCALE	:			
DESIGNED	:	RS	:	DATE	:	11.12.2024	:	1:125
DRAWN	:	RS	:	APPROVED	:	MEGHANA	:	REV NO:
CHECKED	:	MEGHANA	:	SHEET	:	A1	:	R1

DWG NO : TD-E-CRW-202

This drawing is the property of Mc D Built environment research laboratory Pvt Ltd, no part of the drawing may be reproduced in any manner whatsoever without permission from McD berl Pvt Ltd.



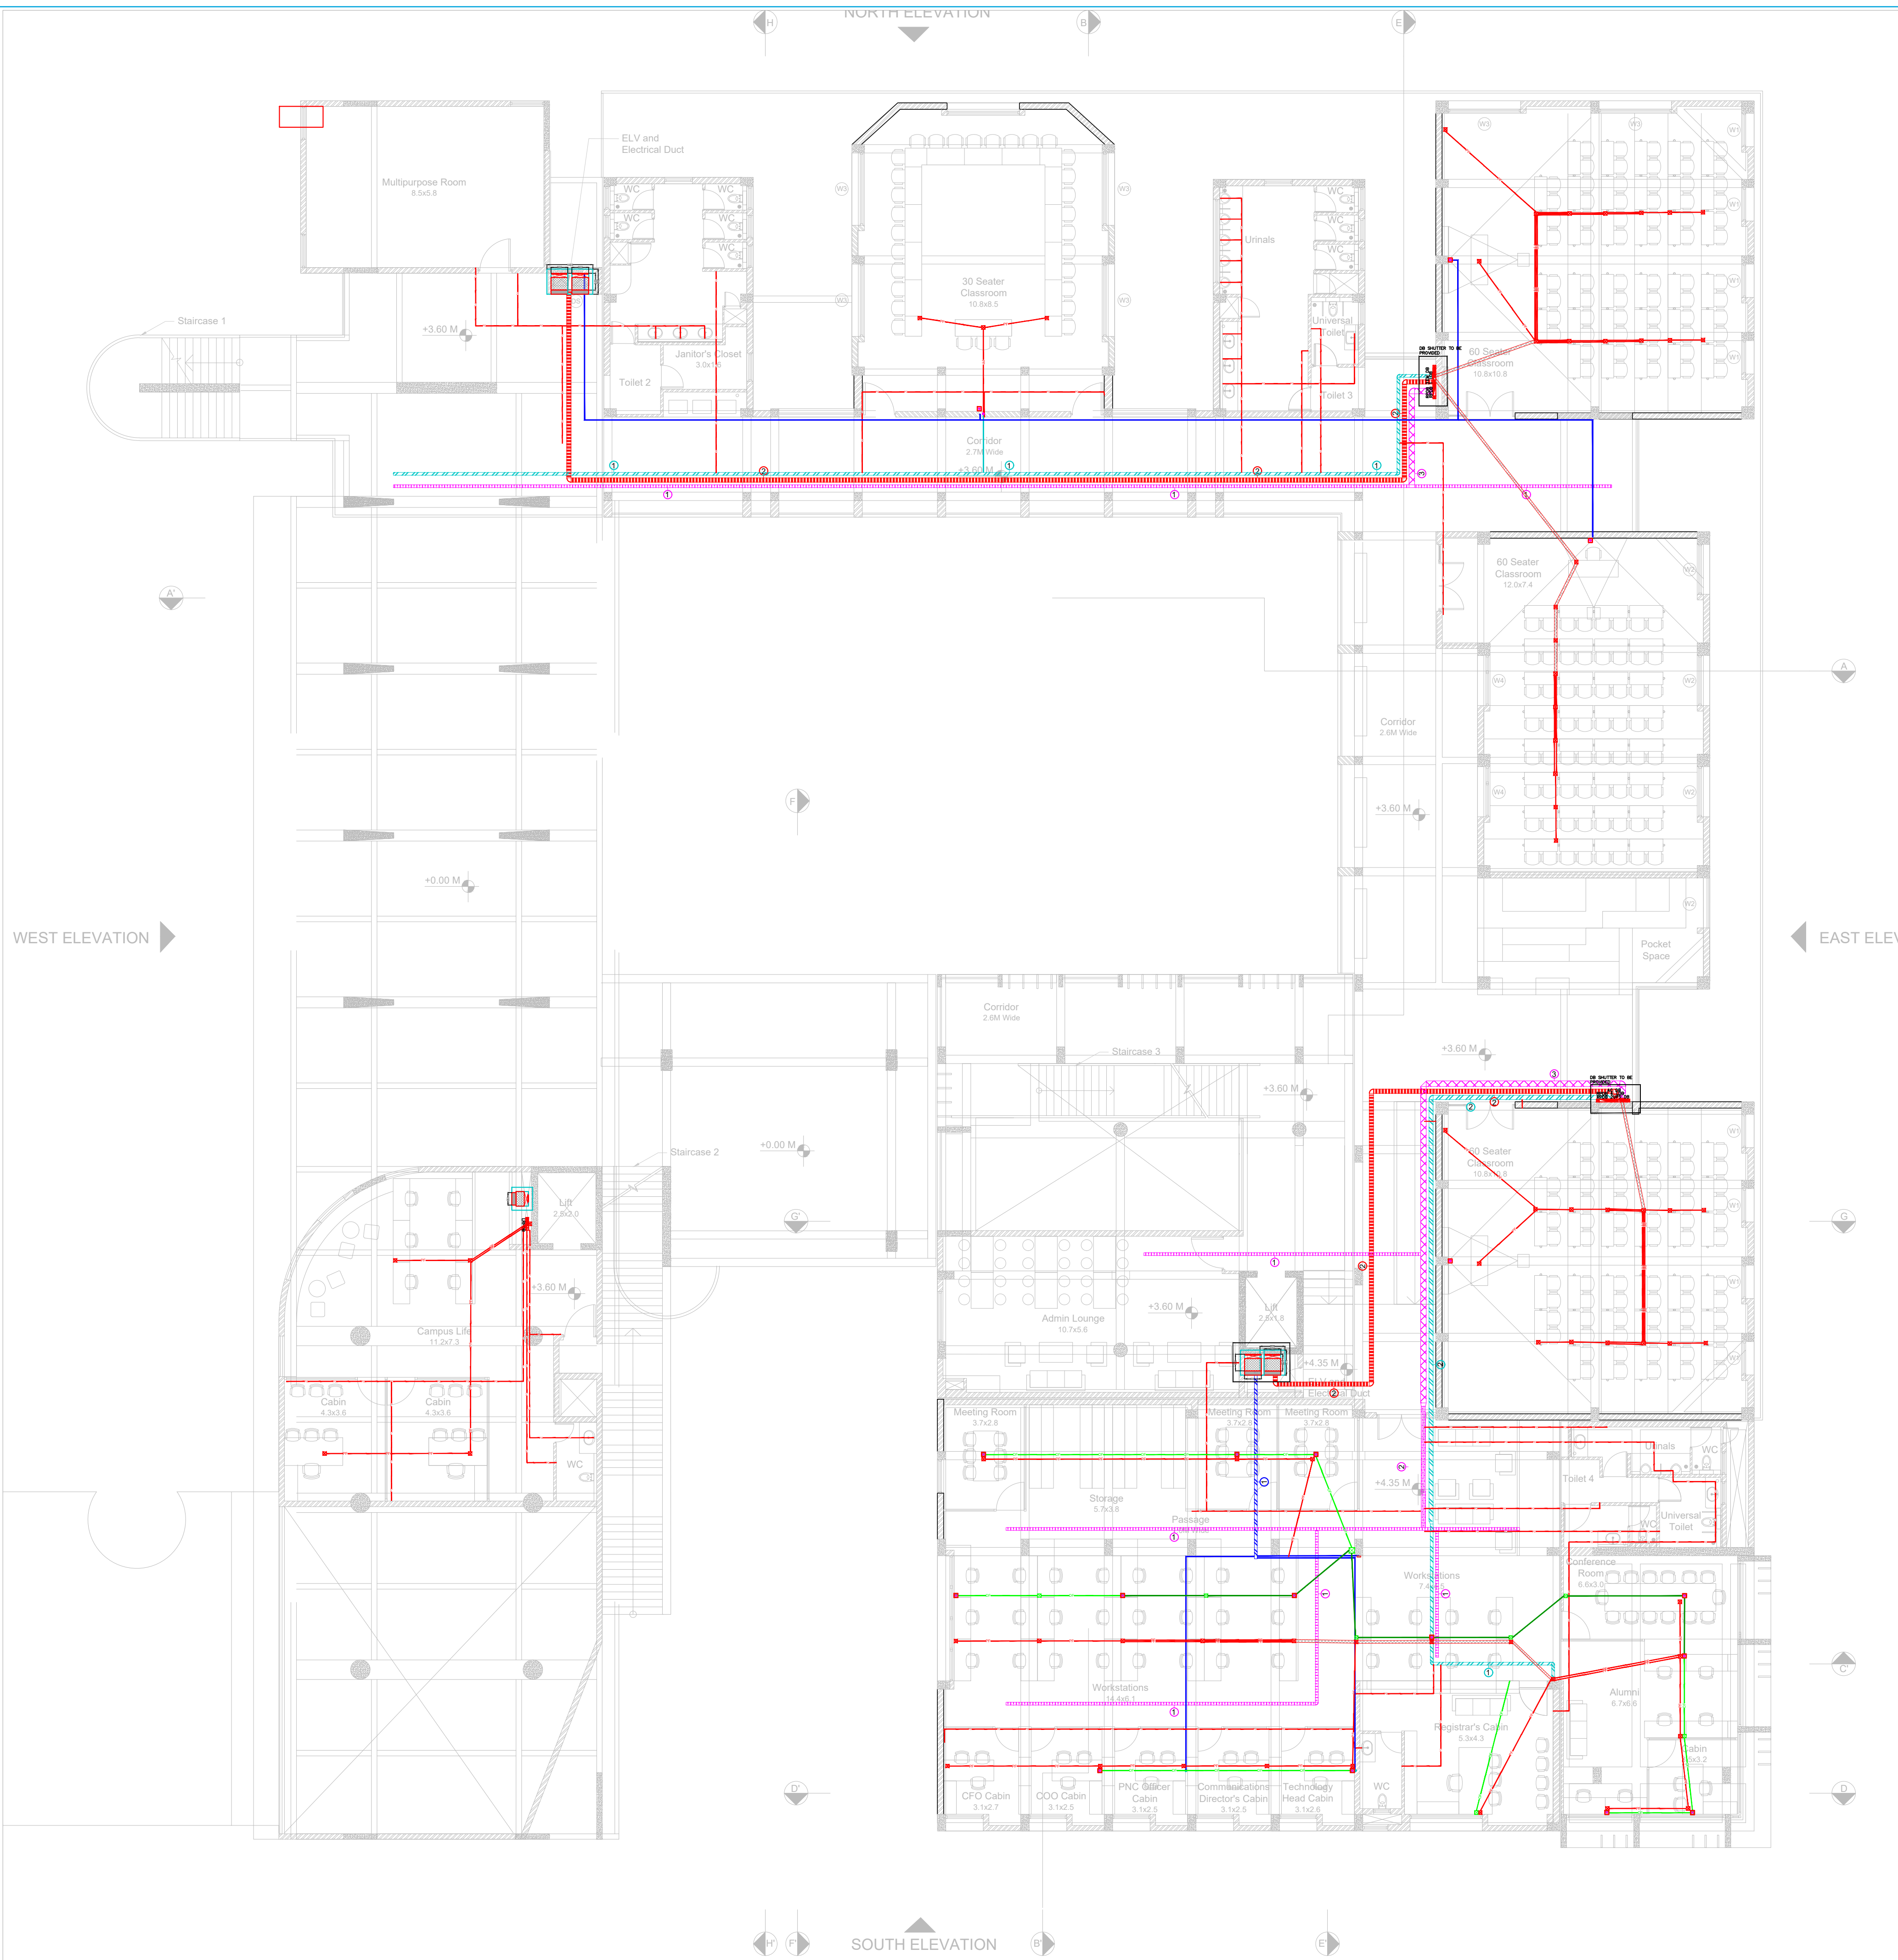

ELECTRICAL CABLE TRAY--LEGEND			
NO	SYMBOL	SERVICE	DESCRIPTION
01		EB	100x50mm PERFORATED TYPE CABLE TRAY
02		EB	150x50mm PERFORATED TYPE CABLE TRAY
03		EB	200x50mm PERFORATED TYPE CABLE TRAY
04		EB	300x50mm PERFORATED TYPE CABLE TRAY
05		EB	450x50mm PERFORATED TYPE CABLE TRAY
06		EB	600x50mm PERFORATED TYPE CABLE TRAY
07		EB	750x50mm PERFORATED TYPE CABLE TRAY

LIGHTING CABLE TRAY--LEGEND			
NO	SYMBOL	SERVICE	DESCRIPTION
01		LIGHTING	100x50mm PERFORATED TYPE CABLE TRAY
02		LIGHTING	150x50mm PERFORATED TYPE CABLE TRAY
03		LIGHTING	200x50mm PERFORATED TYPE CABLE TRAY
04		LIGHTING	300x50mm PERFORATED TYPE CABLE TRAY
05		LIGHTING	450x50mm PERFORATED TYPE CABLE TRAY

ELECTRICAL CEILING RACEWAY--LEGEND		
NO	SYMBOL	SERVICE DESCRIPTION
01		EB 100x40mm GI CEILING RACEWAY
02		EB 150x40mm GI CEILING RACEWAY
03		EB 200x40mm GI CEILING RACEWAY
04		EB 300x40mm GI CEILING RACEWAY
05		EB 450x40mm GI CEILING RACEWAY
06		EB 32MMØ CEILING POWER CONDUIT
07		EB 25MMØ CEILING POWER CONDUIT

DATA CEILING RACEWAY--LEGEND		
NO	SYMBOL	SERVICE DESCRIPTION
01		EB 100x40mm GI CEILING RACEWAY
02		EB 150x40mm GI CEILING RACEWAY
03		EB 200x40mm GI CEILING RACEWAY
04		EB 300x40mm GI CEILING RACEWAY
05		EB 450x40mm GI CEILING RACEWAY
06		EB 32MMØ CEILING DATA CONDUIT
07		EB 25MMØ CEILING DATA CONDUIT

KEYPLAN :-

ISSUALS

R0

TENDER STAGE

11.12.2024

RS

REVISIONS

OWNER'S NAME :-

CLIENT :-

NLSIU BENGALURU

PROJECT ARCHITECT:-  
DCOOP  
ARCHITECTURE.DESIGN.RESEARCH  
UNIT NO. 109, 1ST FLOOR, SWASTIK CHAMBERS,  
SG BARVE ROAD, CHEMBUR, MUMBAI - 400071  
PH: 24706945/46 E-MAIL: mail@dcop.in

OFFICE SEAL :-

MEP & SUSTAINABILITY CONSULTANT :-  
  
Mc D Built Environment Research Laboratory Pvt Ltd,  
Green building,Sustainability and MEP services,  
No 12,Subramanya Arcade, Tower B , Opposite to Jalbhavan, Old  
Gurappanapalya, BTM 1st stage ,Bannerghita road ,Bangalore-560 029.  
Ph:+91 80 41222020,URL: www.mcdberl.com

PROJECT TITLE :-

NLSIU BENGALURU

TENDER STAGE


DRAWING TITLE :-

FIRST FLOOR CEILING RACEWAY  
LAYOUT

PHASE	:	BLOCK	:	SCALE	:			
DESIGNED	:	RS	:	DATE	:	11.12.2024	:	1:125
DRAWN	:	RS	:	APPROVED	:	MEGHANA	:	REV NO:
CHECKED	:	MEGHANA	:	SHEET	:	A1	:	R1

DWG NO : TD-E-CRW-203  
This drawing is the property of Mc D Built environment research laboratory Pvt Ltd, no part of the drawing may be reproduced in any manner whatsoever without permission from McD berl Pvt Ltd.



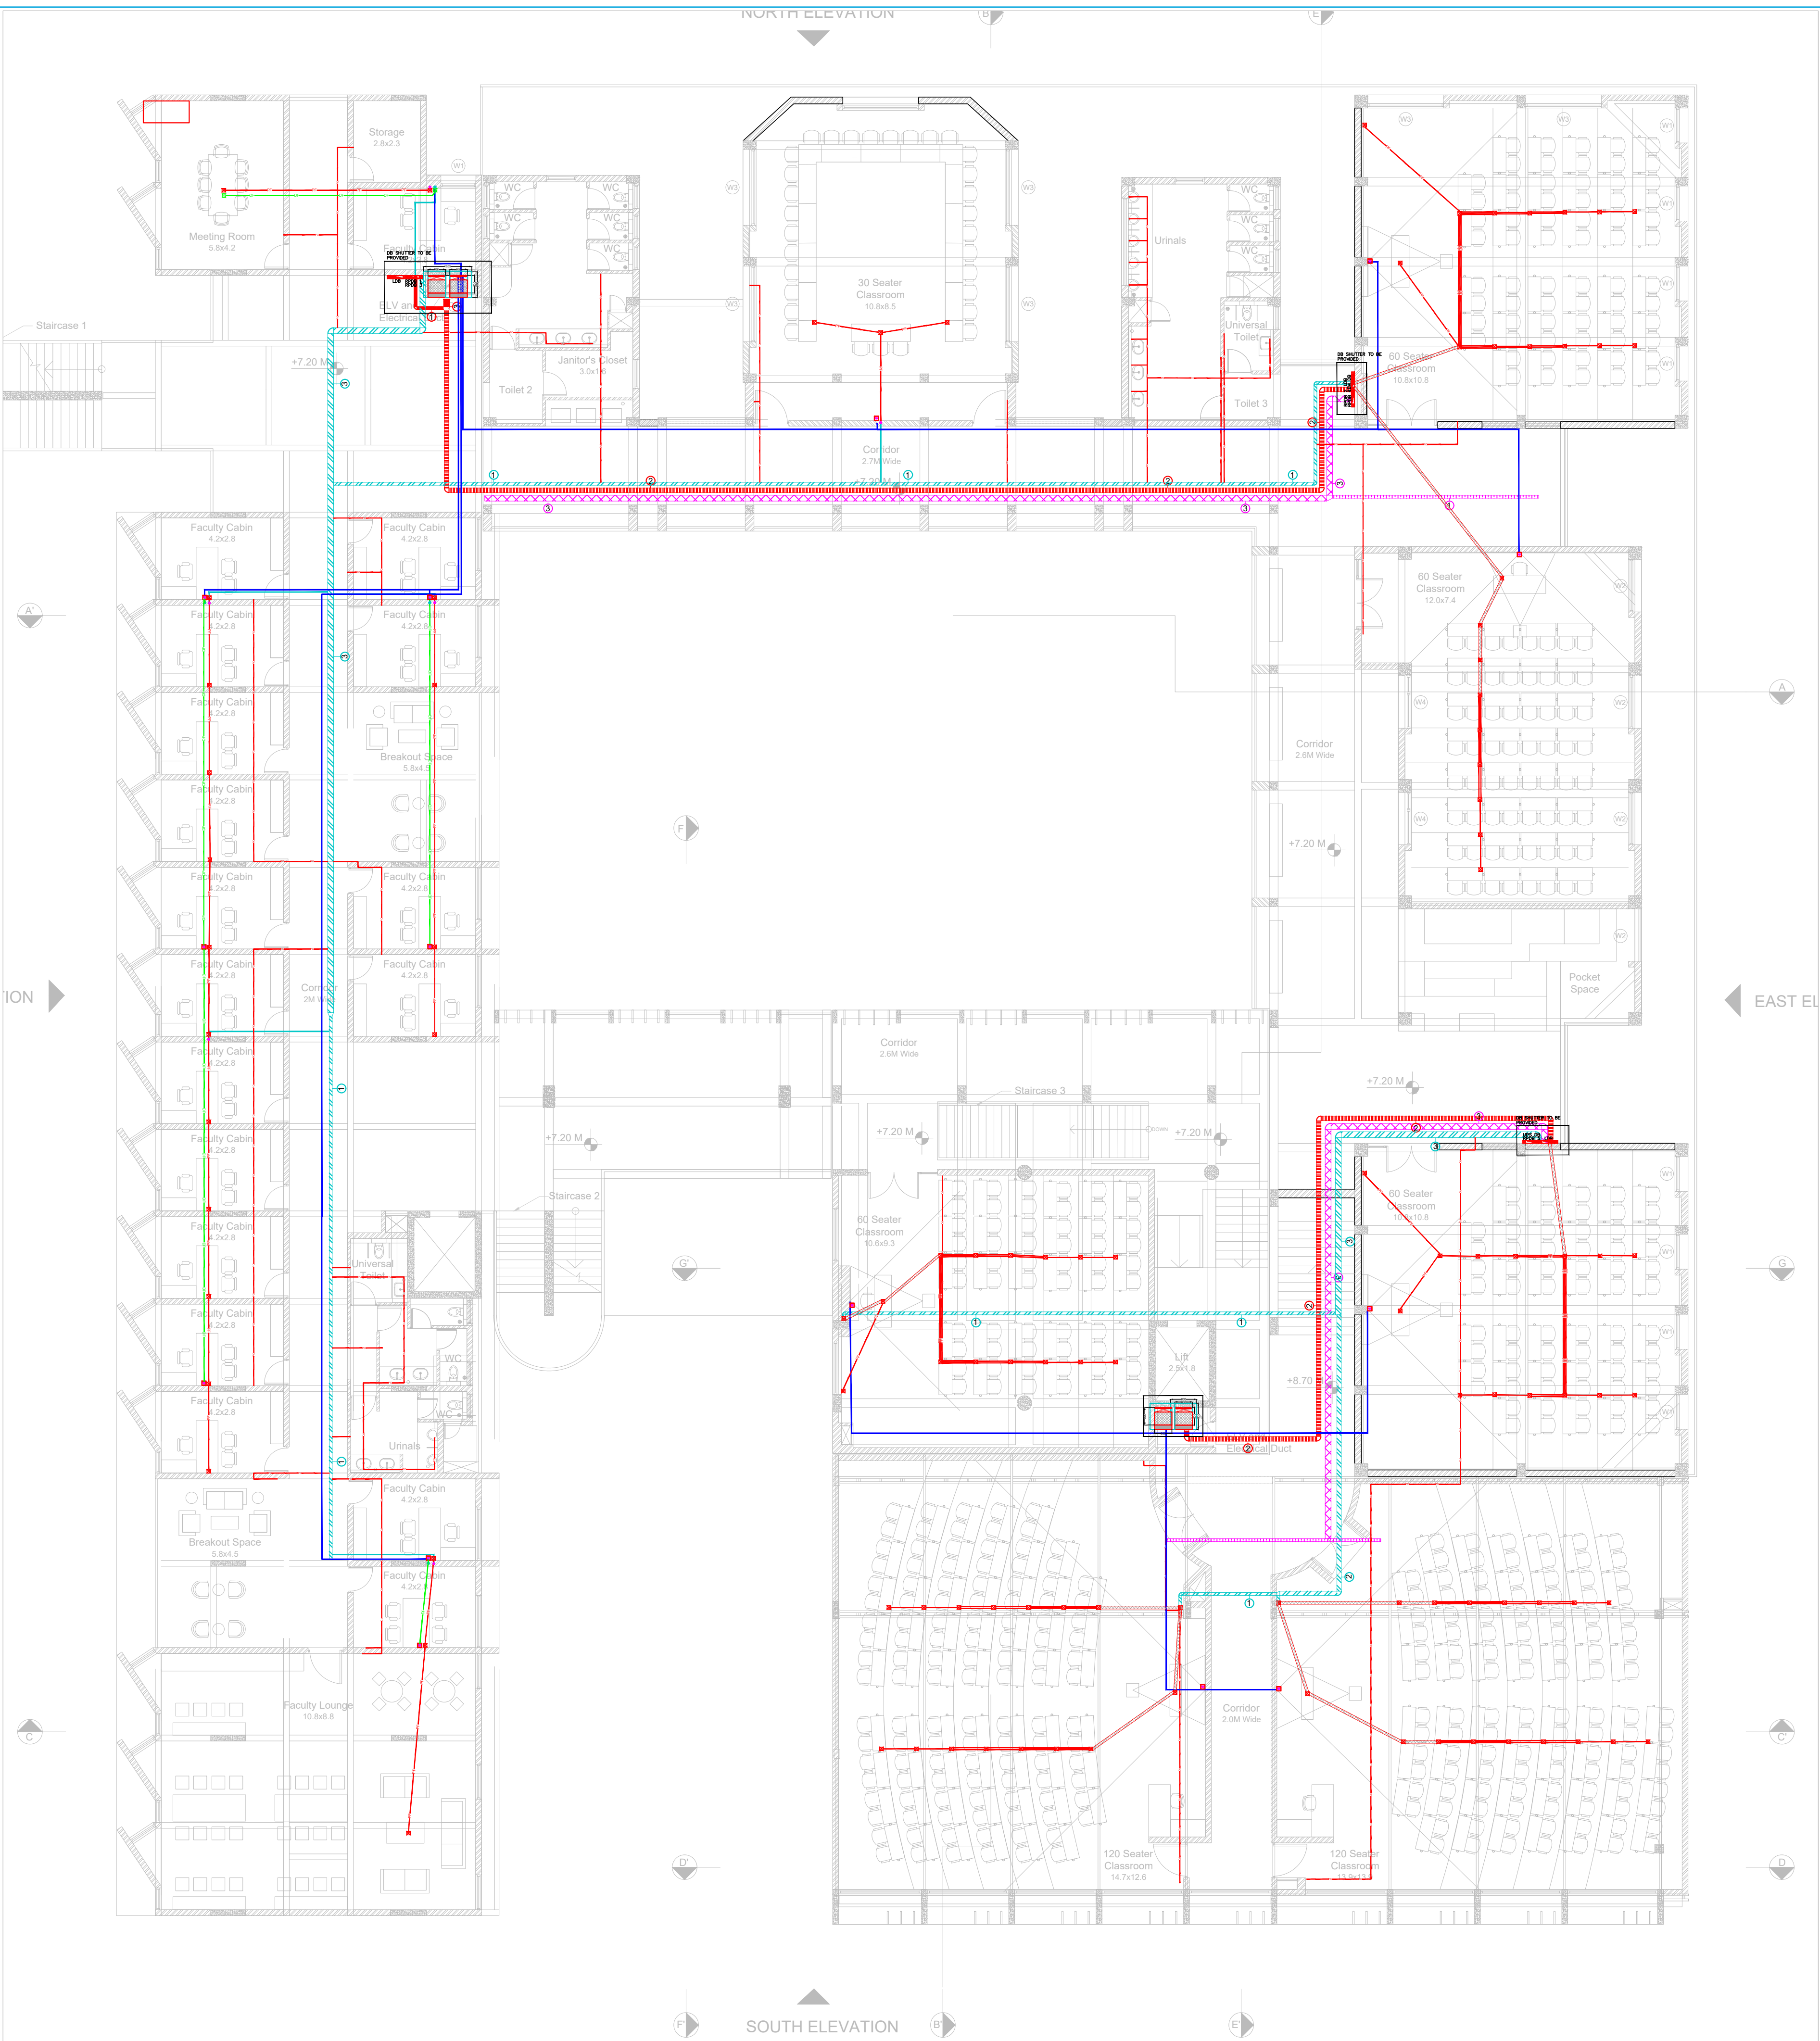

ELECTRICAL CABLE TRAY—LEGEND			
NO	SYMBOL	SERVICE	DESCRIPTION
01		EB	100x50mm PERFORATED TYPE CABLE TRAY
02		EB	150x50mm PERFORATED TYPE CABLE TRAY
03		EB	200x50mm PERFORATED TYPE CABLE TRAY
04		EB	300x50mm PERFORATED TYPE CABLE TRAY
05		EB	450x50mm PERFORATED TYPE CABLE TRAY
06		EB	600x50mm PERFORATED TYPE CABLE TRAY
07		EB	750x50mm PERFORATED TYPE CABLE TRAY

LIGHTING CABLE TRAY—LEGEND			
NO	SYMBOL	SERVICE	DESCRIPTION
01		LIGHTING	100x50mm PERFORATED TYPE CABLE TRAY
02		LIGHTING	150x50mm PERFORATED TYPE CABLE TRAY
03		LIGHTING	200x50mm PERFORATED TYPE CABLE TRAY
04		LIGHTING	300x50mm PERFORATED TYPE CABLE TRAY
05		LIGHTING	450x50mm PERFORATED TYPE CABLE TRAY

ELECTRICAL CEILING RACEWAY—LEGEND			
NO	SYMBOL	SERVICE	DESCRIPTION
01		EB	100x40mm GI CEILING RACEWAY
02		EB	150x40mm GI CEILING RACEWAY
03		EB	200x40mm GI CEILING RACEWAY
04		EB	300x40mm GI CEILING RACEWAY
05		EB	450x40mm GI CEILING RACEWAY
06		EB	32MM# CEILING POWER CONDUIT
07		EB	25MM# CEILING POWER CONDUIT

DATA CEILING RACEWAY—LEGEND			
NO	SYMBOL	SERVICE	DESCRIPTION
01		EB	100x40mm GI CEILING RACEWAY
02		EB	150x40mm GI CEILING RACEWAY
03		EB	200x40mm GI CEILING RACEWAY
04		EB	300x40mm GI CEILING RACEWAY
05		EB	450x40mm GI CEILING RACEWAY
06		EB	32MM# CEILING DATA CONDUIT
07		EB	25MM# CEILING DATA CONDUIT

KEYPLAN :-

ISSUALS

R0	TENDER STAGE	11.12.2024	RS
REVISIONS			

OWNER'S NAME :-

CLIENT :-

NLSIU BENGALURU

PROJECT ARCHITECT:-

**DCOOP**  
ARCHITECTURE.DESIGN.RESEARCH

UNIT NO. 109, 1ST FLOOR, SWASTIK CHAMBERS,  
SG BARVE ROAD, CHEMBUR, MUMBAI - 400071  
PH: 24706945/46 E-MAIL: mail@dcoop.in

OFFICE SEAL :-

MEP & SUSTAINABILITY CONSULTANT :-



Mc D Built Environment Research Laboratory Pvt Ltd,  
Green building,Sustainability and MEP services,  
No 12,Subramanya Arcade, Tower B , Opposite to Jalbhavan, Old  
Gurappanapalya, BTM 1st stage ,Bannerghatta road ,Bangalore-560 029.  
Ph:+91 80 41222020,URL: www.mcdberl.com

PROJECT TITLE :-

NLSIU BENGALURU

TENDER STAGE




DRAWING TITLE :-

SECOND FLOOR CEILING  
RACEWAY LAYOUT

PHASE	:	BLOCK	:	SCALE	:
DESIGNED	:	RS	:	DATE	:
DRAWN	:	RS	:	APPROVED	:
CHECKED	:	MEGHANA	:	SHEET	:
DWG NO	:	TD-E-CRW-204	:	REV NO:	:
				R1	

This drawing is the property of Mc D Built environment research laboratory Pvt Ltd, no part of the drawing may be reproduced in any manner whatsoever without permission from McD berl Pvt Ltd.



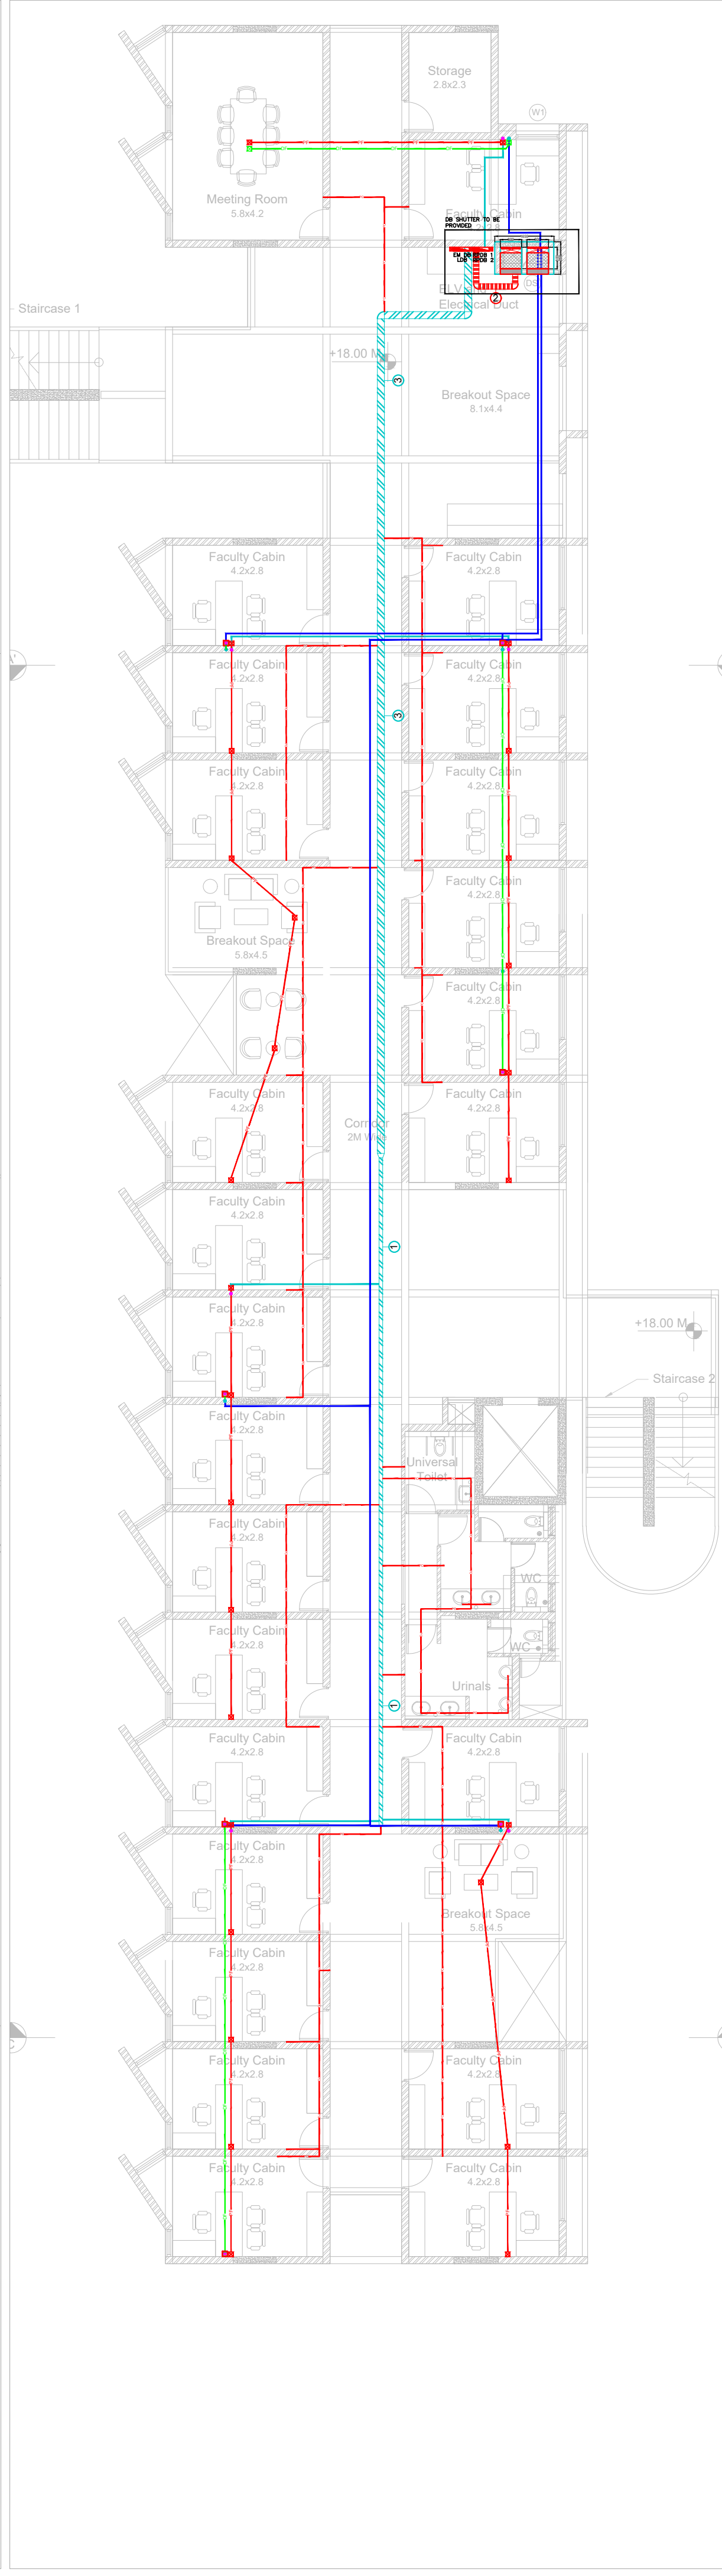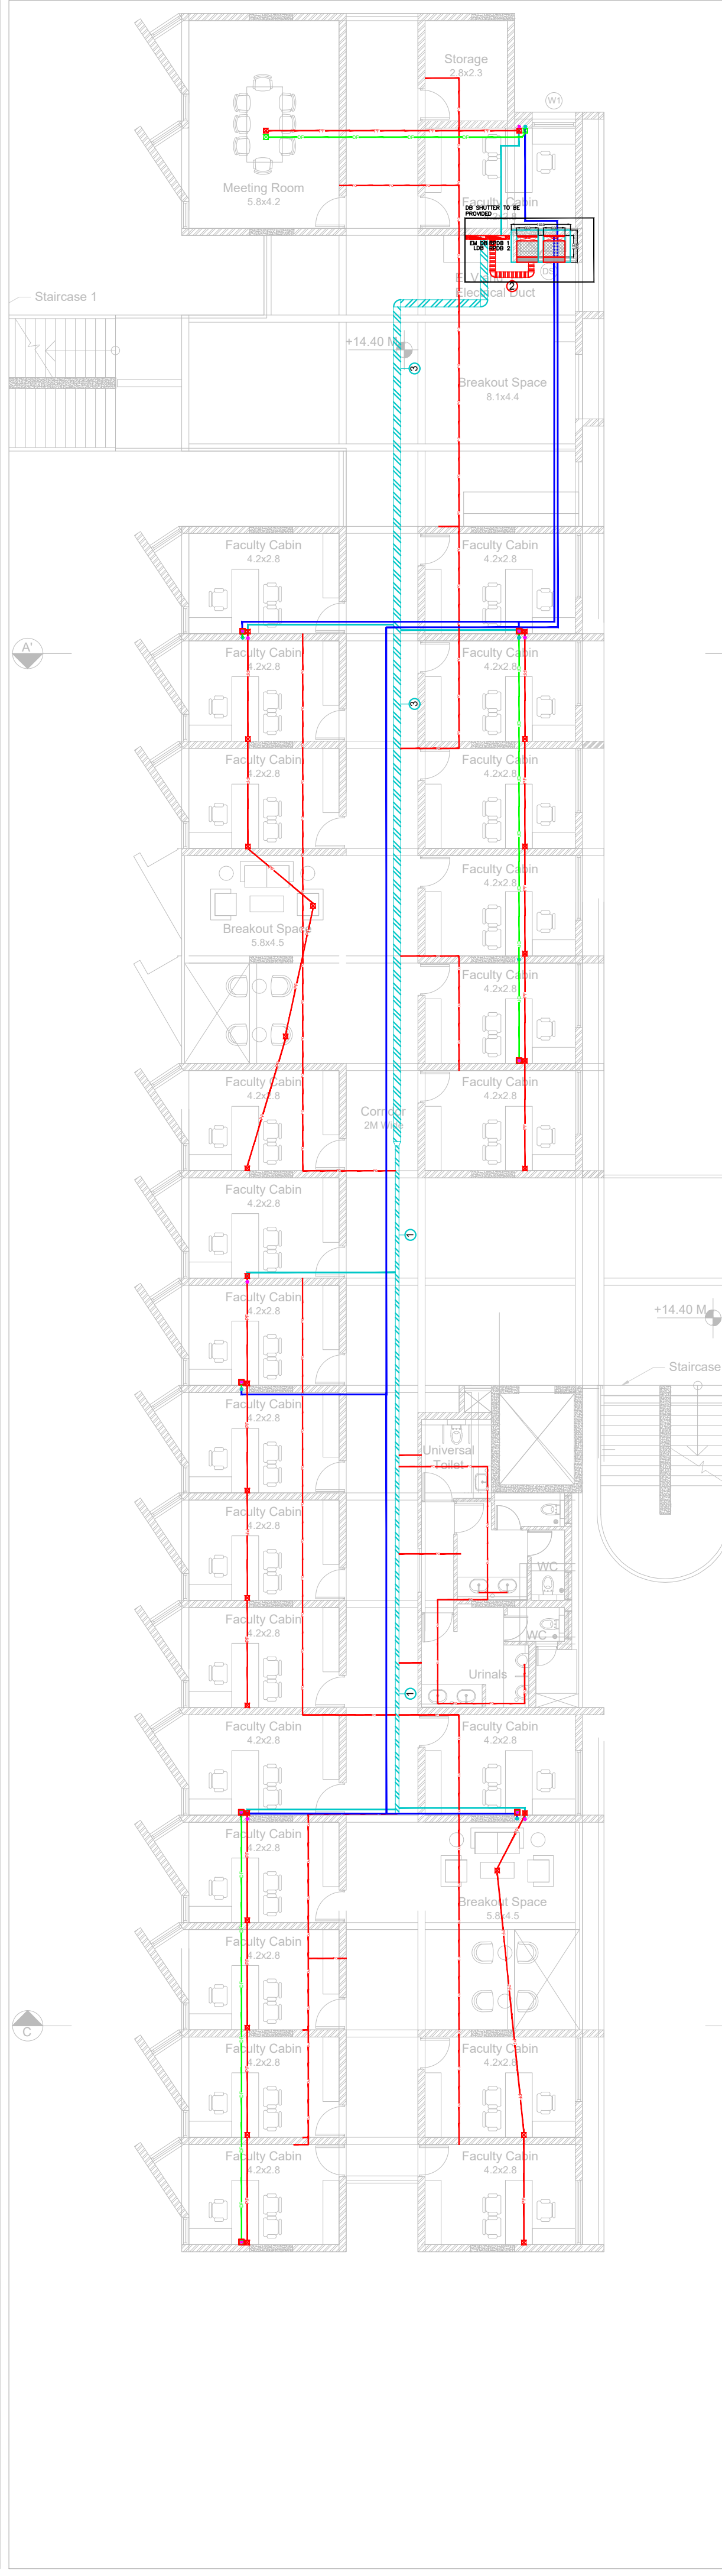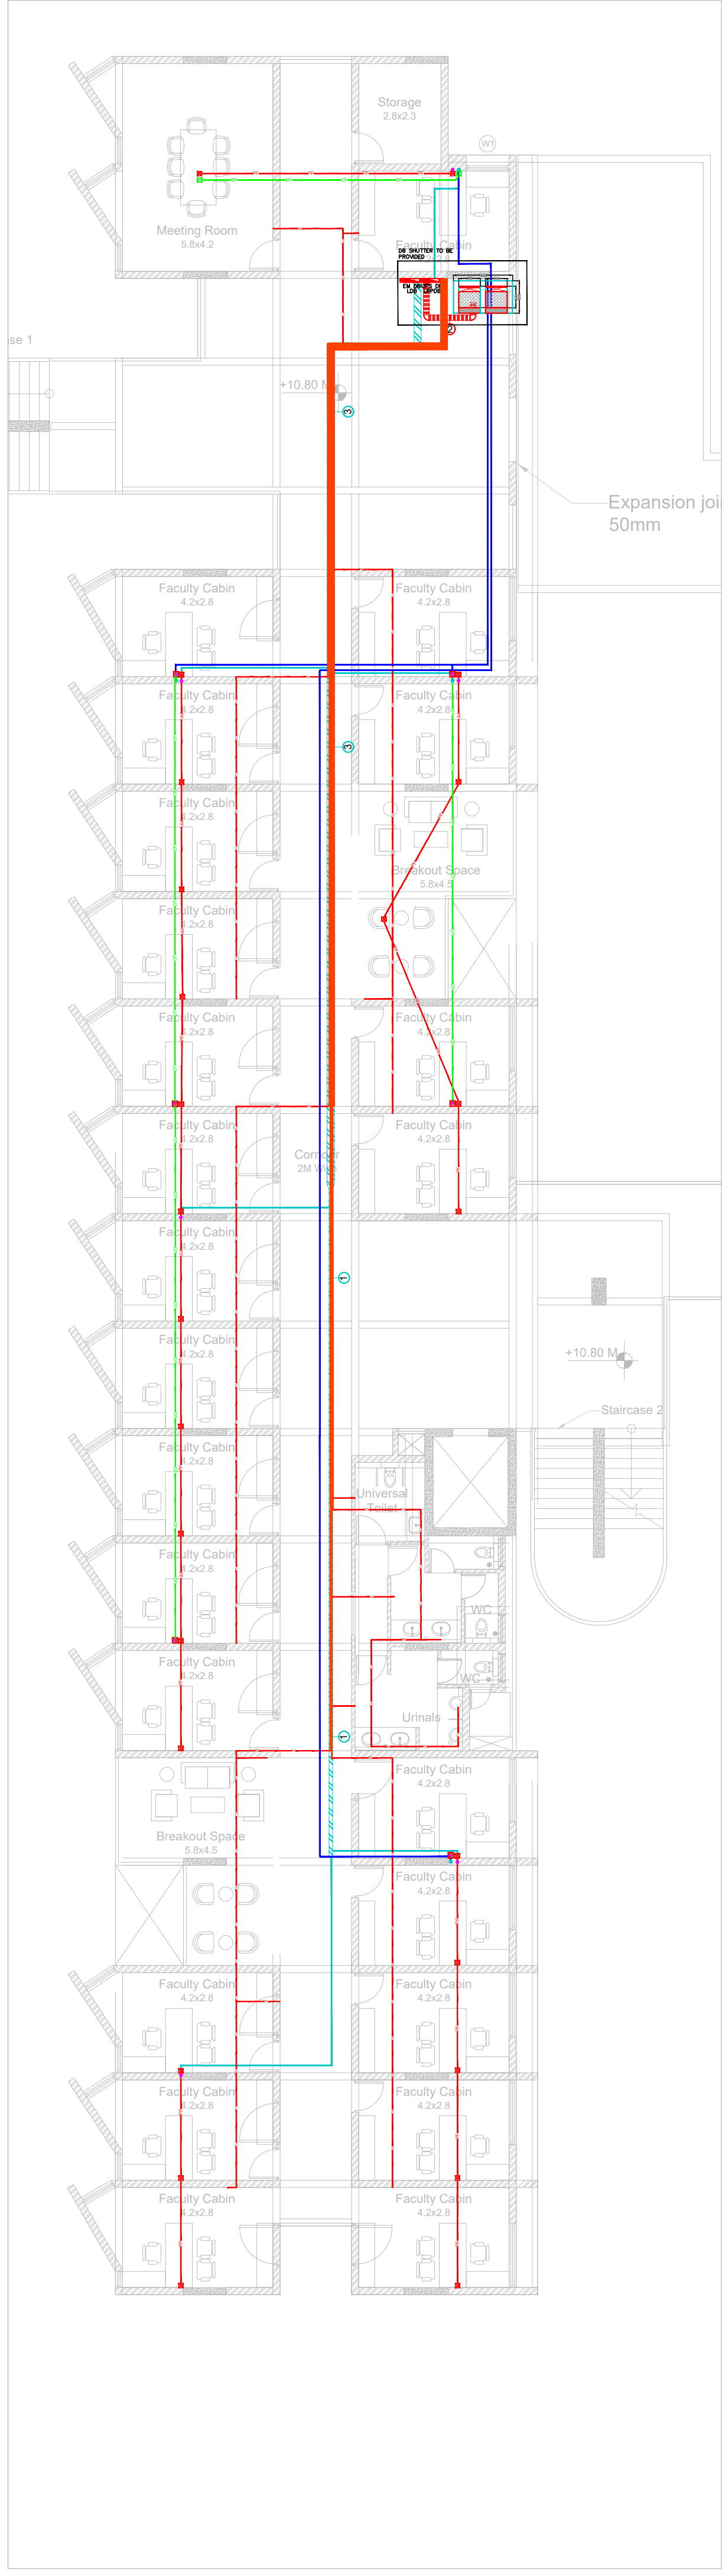

ELECTRICAL CABLE TRAY--LEGEND			
NO	SYMBOL	SERVICE	DESCRIPTION
01		EB	100x50mm PERFORATED TYPE CABLE TRAY
02		EB	150x50mm PERFORATED TYPE CABLE TRAY
03		EB	200x50mm PERFORATED TYPE CABLE TRAY
04		EB	300x50mm PERFORATED TYPE CABLE TRAY
05		EB	450x50mm PERFORATED TYPE CABLE TRAY
06		EB	600x50mm PERFORATED TYPE CABLE TRAY
07		EB	750x50mm PERFORATED TYPE CABLE TRAY

LIGHTING CABLE TRAY--LEGEND			
NO	SYMBOL	SERVICE	DESCRIPTION
01		LIGHTING	100x50mm PERFORATED TYPE CABLE TRAY
02		LIGHTING	150x50mm PERFORATED TYPE CABLE TRAY
03		LIGHTING	200x50mm PERFORATED TYPE CABLE TRAY
04		LIGHTING	300x50mm PERFORATED TYPE CABLE TRAY
05		LIGHTING	450x50mm PERFORATED TYPE CABLE TRAY

ELECTRICAL CEILING RACEWAY--LEGEND			
NO	SYMBOL	SERVICE	DESCRIPTION
01		EB	100x40mm GI CEILING RACEWAY
02		EB	150x40mm GI CEILING RACEWAY
03		EB	200x40mm GI CEILING RACEWAY
04		EB	300x40mm GI CEILING RACEWAY
05		EB	450x40mm GI CEILING RACEWAY
06		EB	32MMØ CEILING POWER CONDUIT
07		EB	25MMØ CEILING POWER CONDUIT

DATA CEILING RACEWAY--LEGEND			
NO	SYMBOL	SERVICE	DESCRIPTION
01		EB	100x40mm GI CEILING RACEWAY
02		EB	150x40mm GI CEILING RACEWAY
03		EB	200x40mm GI CEILING RACEWAY
04		EB	300x40mm GI CEILING RACEWAY
05		EB	450x40mm GI CEILING RACEWAY
06		EB	32MMØ CEILING DATA CONDUIT
07		EB	25MMØ CEILING DATA CONDUIT

KEYPLAN :-

ISSUALS

R0	TENDER STAGE	11.12.2024	RS
REVISIONS			

OWNER'S NAME :-

CLIENT :-

NLSIU BENGALURU

PROJECT ARCHITECT:-

**DCOOP**  
ARCHITECTURE.DESIGN.RESEARCH

UNIT NO. 109, 1ST FLOOR, SWASTIK CHAMBERS,  
SG BARVE ROAD, CHEMBUR, MUMBAI - 400071  
PH: 24706945/46 E-MAIL: mail@dcop.in

OFFICE SEAL :-

MEP & SUSTAINABILITY CONSULTANT :-



Mc D Built Environment Research Laboratory Pvt Ltd,  
Green building,Sustainability and MEP services,  
No 12,Subramanya Arcade, Tower B , Opposite to Jalbhavan, Old  
Gurappanapalya, BTM 1st stage ,Bannerghita road ,Bangalore-560 029.  
Ph:+91 80 41222020,URL: www.mcdberl.com

PROJECT TITLE :-

NLSIU BENGALURU

TENDER STAGE

DRAWING TITLE :-

THIRD,FOURTH,FIFTH FLOOR  
CEILING RACEWAY LAYOUT

PHASE	:	BLOCK	:	SCALE	:
DESIGNED	:	RS	:	DATE	:
DRAWN	:	RS	:	APPROVED	:
CHECKED	:	MEGHANA	:	SHEET	:
DWG NO	:	TD-E-CRW-205	:	REV NO:	:
					R1

This drawing is the property of Mc D Built environment research laboratory Pvt Ltd, no part of the drawing may be reproduced in any manner whatsoever without permission from McD berl Pvt Ltd.




# **ELECTRICAL TENDER DRAWINGS - SOLAR LAYOUT**

**OAB REDEVELOPMENT, NLSIU, BENGALURU**

**Dec 2024**



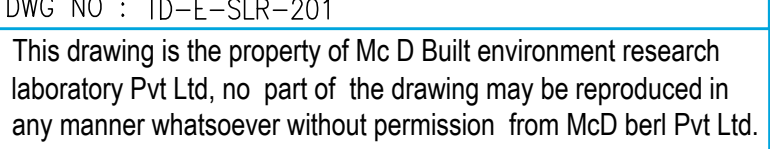



# **ELECTRICAL TENDER DRAWINGS - CCTV LAYOUT**


**OAB REDEVELOPMENT, NLSIU, BENGALURU**




Dec 2024





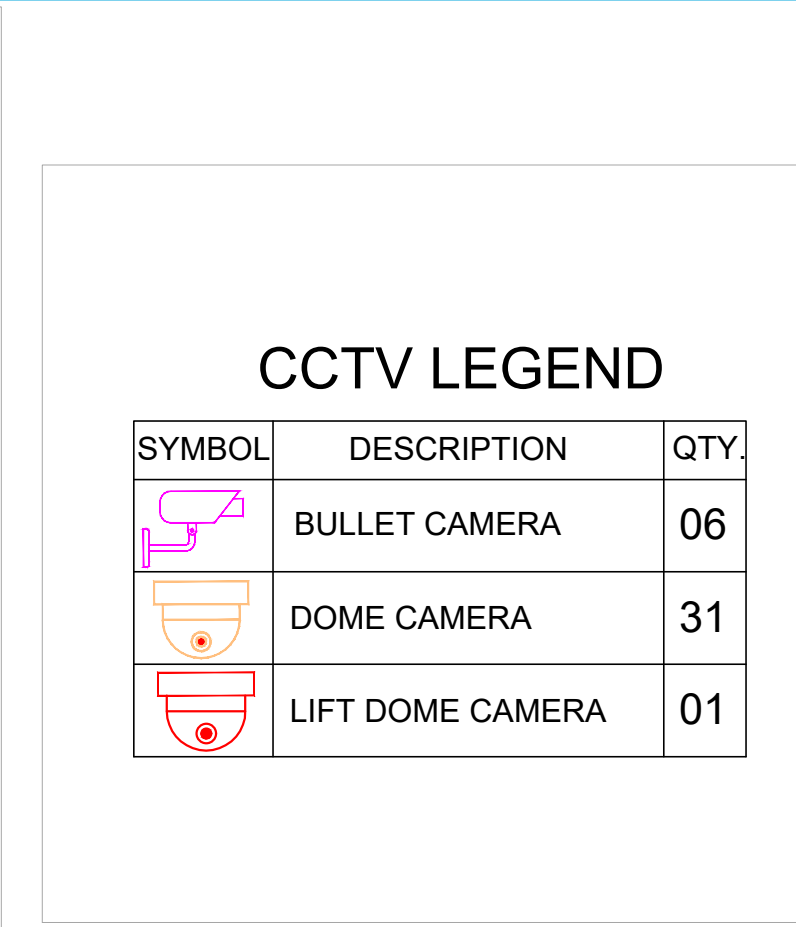



SYMBOL	DESCRIPTION	QTY.
	BULLET CAMERA	06
	DOME CAMERA	31
	LIFT DOME CAMERA	01

KEYPLAN :-

[illegible]

## ISSUALS

R0	TENDER STAGE	11.12.2024	RS

## REVISIONS

OWNER'S NAME :-

CLIENT :-

NLSIU BENGALURU

PROJECT ARCHITECT:-

DCOOP  
ARCHITECTURE.DESIGN.RESEARCH

UNIT NO. 109, 1ST FLOOR, SWASTIK CHAMBERS,  
SG BARVE ROAD, CHEMBUR, MUMBAI - 400071  
PH: 24706945/46 E-MAIL: mail@dcoop.in

OFFICE SEAL :-

MEP & SUSTAINABILITY CONSULTANT :-



**Mc D Built Environment Research Laboratory Pvt Ltd,**  
Green building,Sustainability and MEP services,  
No 12,Subramanya Arcade, Tower B , Opposite to Jalbhavan, Old  
Gurappanapalya, BTM 1st stage ,Bannerghatta road ,Bangalore-560 029.  
Ph:+91 80 41222020,URL: [www.mcdberl.com](http://www.mcdberl.com)

PROJECT TITLE :-

NLSIU BENGALURU

## TENDER STAGE

DRAWING TITLE :-

## GROUND FLOOR CCTV LAYOUT

PHASE :	BLOCK :	SCALE :
DESIGNED : RS	DATE : 11.12.2024	1:125
DRAWN : RS	APPROVED : MEGHANA	REV NO:
CHECKED : MEGHANA	SHEET : A1	R1




DWG NO : TD-E-CCTV-202

This drawing is the property of Mc D Built environment research laboratory Pvt Ltd, no part of the drawing may be reproduced in any manner whatsoever without permission from McD berl Pvt Ltd.



 

### CCTV LEGEND

SYMBOL	DESCRIPTION	QTY.
	BULLET CAMERA	00
	DOME CAMERA	28
	LIFT DOME CAMERA	00

### KEYPLAN :-

### ISSUALS

### REVISIONS

### OWNER'S NAME :-

### CLIENT :-

NLSIU BENGALURU

### PROJECT ARCHITECT:-

**DCOOP**  
ARCHITECTURE DESIGN RESEARCH

UNIT NO. 109, 1ST FLOOR, SWASTIK CHAMBERS,  
SG BARVE ROAD, CHEMBUR, MUMBAI - 400071  
PH: 24706945/46 E-MAIL: mail@dcloop.in

### OFFICE SEAL :-

### MEP & SUSTAINABILITY CONSULTANT :-



Mc D Built Environment Research Laboratory Pvt Ltd,  
Green building,Sustainability and MEP services,  
No 12,Subramanya Arcade, Tower B , Opposite to Jalbhavan, Old  
Gurappanapalya, BTM 1st stage ,Bannerghita road ,Bangalore-560 029.  
Ph:+91 80 41222020,URL: www.mcdberl.com

### PROJECT TITLE :-

NLSIU BENGALURU

TENDER STAGE

### DRAWING TITLE :-


FIRST FLOOR  
CCTV LAYOUT

PHASE :	BLOCK :	SCALE :
DESIGNED : RS	DATE : 11.12.2024	1:125
DRAWN : RS	APPROVED : MEGHANA	REV NO:
CHECKED : MEGHANA	SHEET : A1	R1

DWG NO : TD-E-CCTV-203

This drawing is the property of Mc D Built environment research laboratory Pvt Ltd, no part of the drawing may be reproduced in any manner whatsoever without permission from McD berl Pvt Ltd.



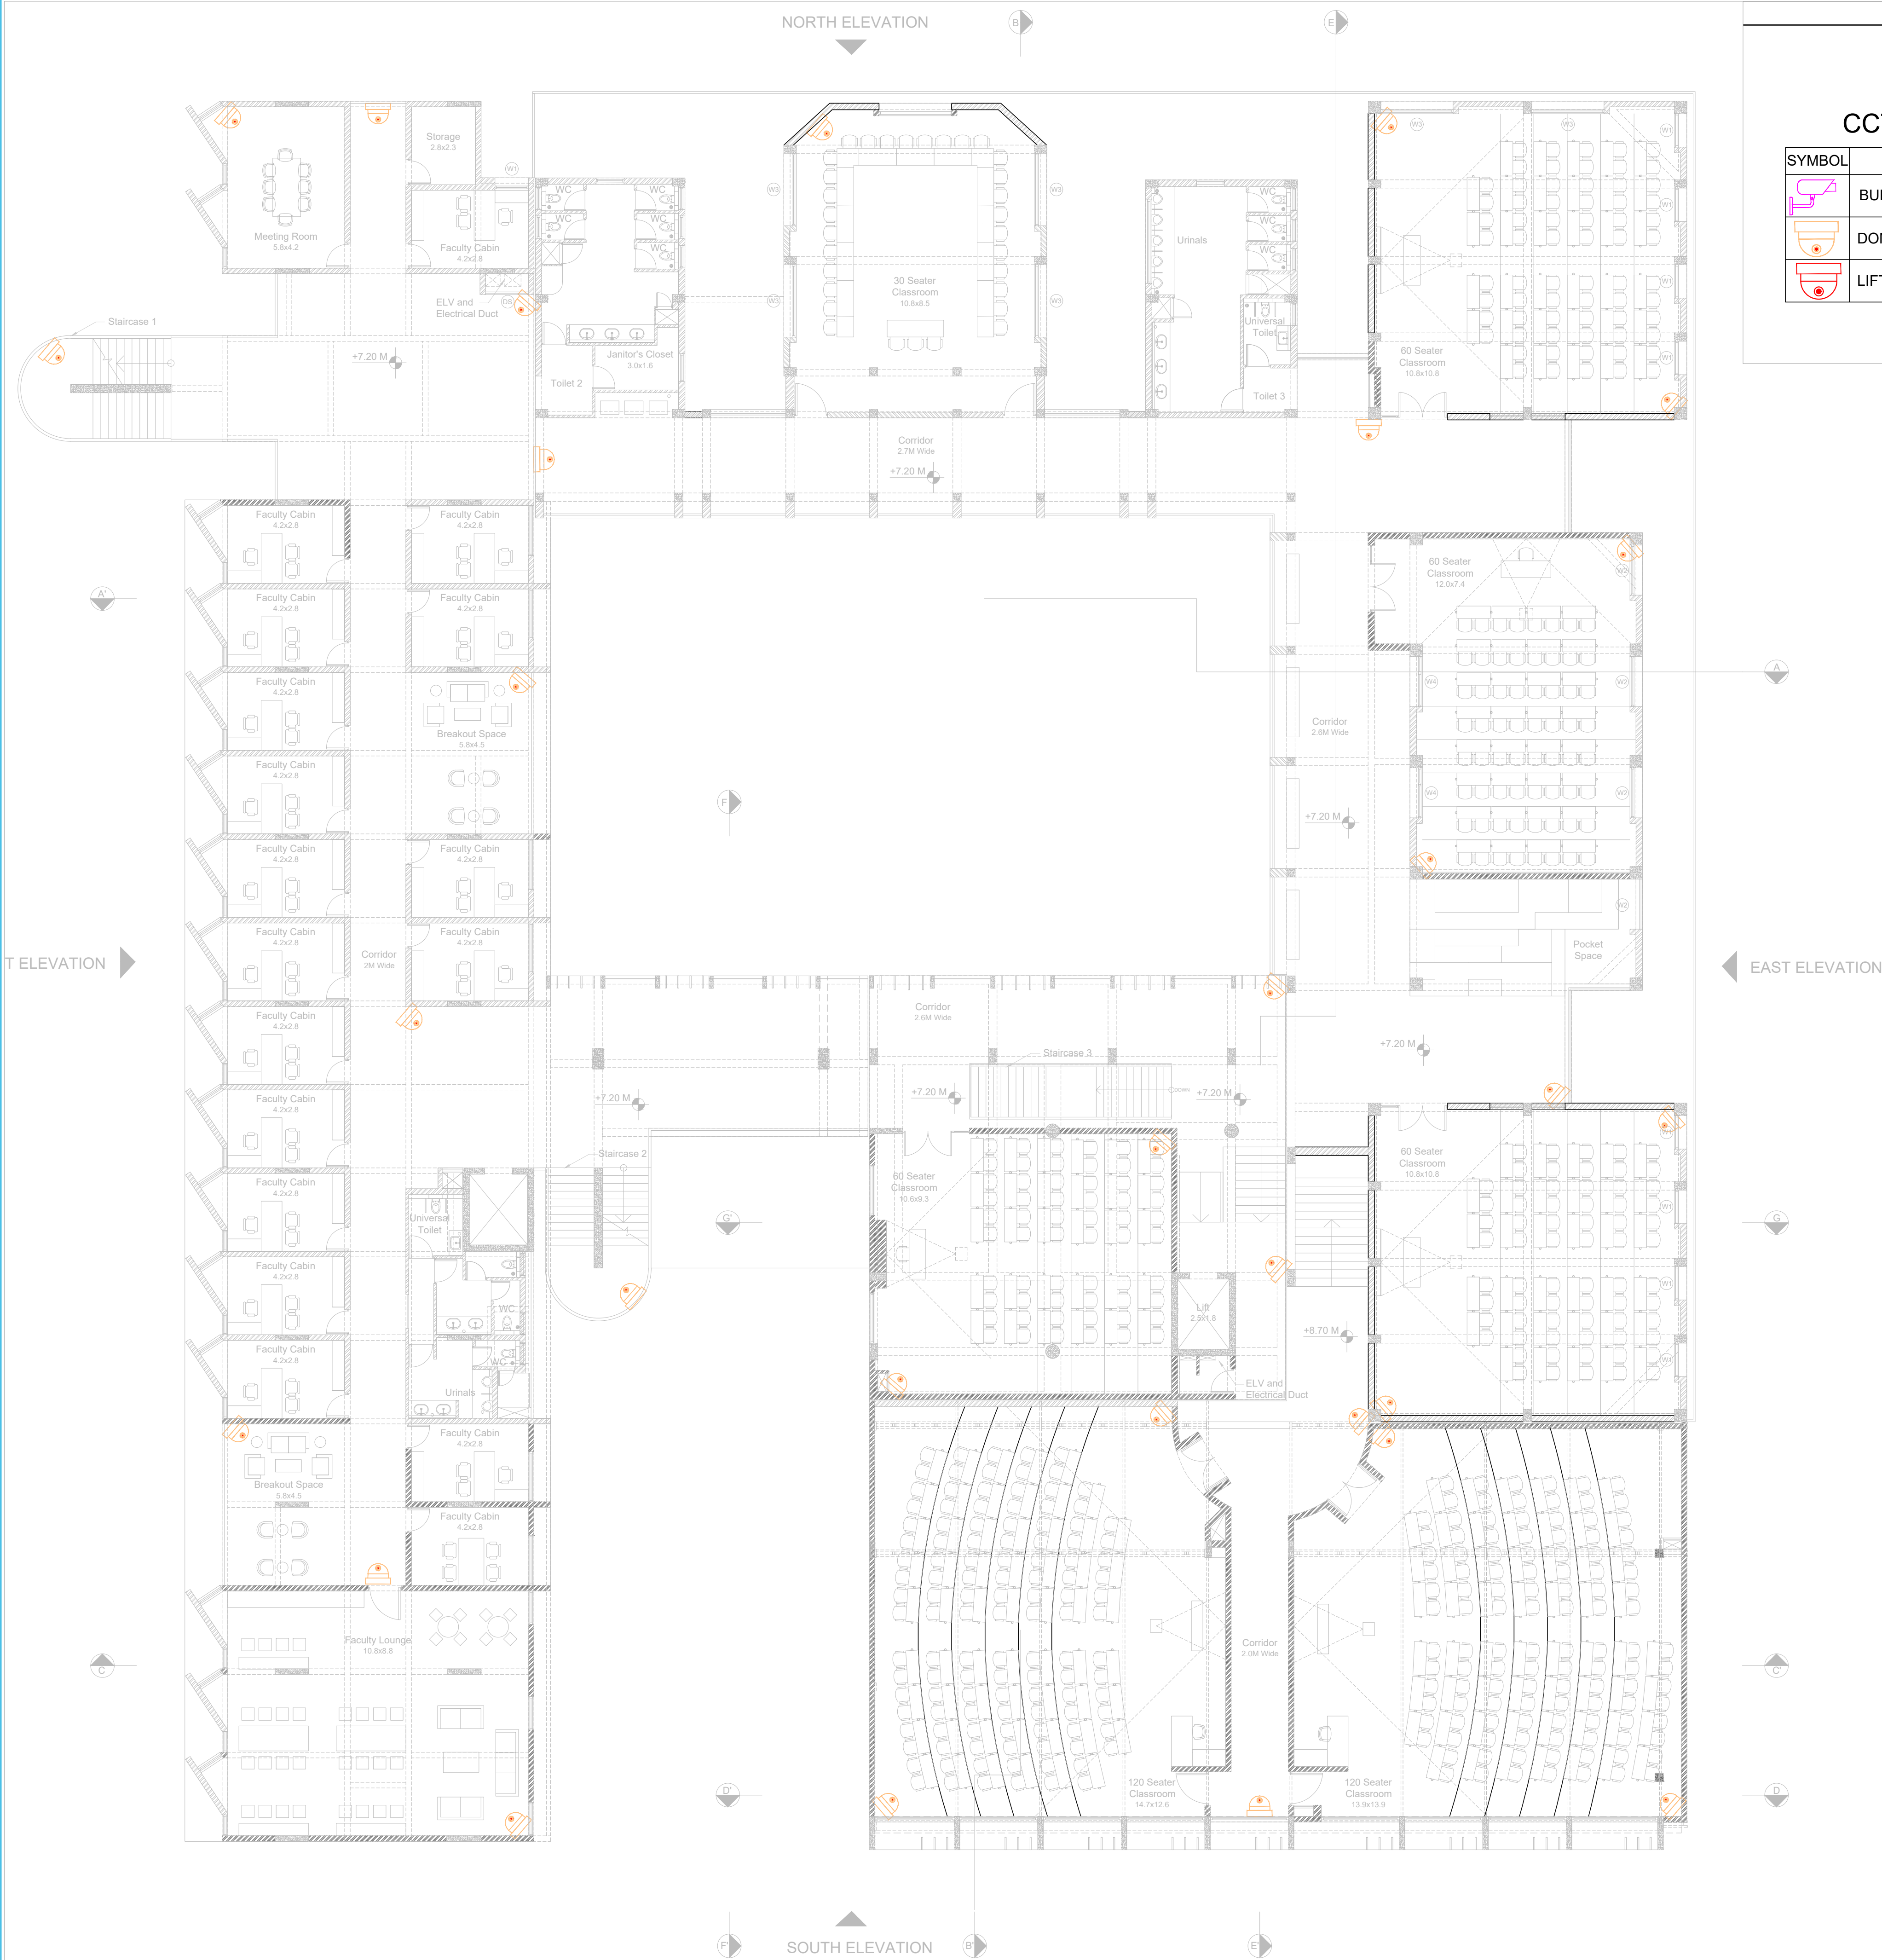

CCTV LEGEND

SYMBOL	DESCRIPTION	QTY.
	BULLET CAMERA	00
	DOME CAMERA	30
	LIFT DOME CAMERA	00

KEYPLAN :-

ISSUALS

R0	TENDER STAGE	11.12.2024	RS
----	--------------	------------	----

REVISIONS

OWNER'S NAME :-

CLIENT :-

NLSIU BENGALURU

PROJECT ARCHITECT:-

**DCOOP**  
ARCHITECTURE DESIGN RESEARCH

UNIT NO. 109, 1ST FLOOR, SWASTIK CHAMBERS,  
SG BARVE ROAD, CHEMBUR, MUMBAI - 400071  
PH: 24706945/46 E-MAIL: mail@dcop.in

OFFICE SEAL :-

MEP & SUSTAINABILITY CONSULTANT :-



Mc D Built Environment Research Laboratory Pvt Ltd,  
Green building Sustainability and MEP services,  
No 12,Subramanya Arcade, Tower B , Opposite to Jalbhavan, Old  
Gurappanapalya, BTM 1st stage ,Bannerghatta road ,Bangalore-560 029.  
Ph:+91 80 41222020,URL: www.mcdberl.com

PROJECT TITLE :-

NLSIU BENGALURU

TENDER STAGE

DRAWING TITLE :-


SECOND FLOOR  
CCTV LAYOUT

PHASE	:	BLOCK	:	SCALE	:
DESIGNED	:	RS	:	DATE	:
DRAWN	:	RS	:	DATE	:
CHECKED	:	MEGHANA	:	APPROVED	:
	:		:	MEGHANA	:
	:		:	SHEET	:
	:		:	A1	:
	:		:	REV NO:	:
	:		:	R1	:

DWG NO : TD-E-CCTV-204

This drawing is the property of Mc D Built environment research  
laboratory Pvt Ltd, no part of the drawing may be reproduced in  
any manner whatsoever without permission from McD berl Pvt Ltd.




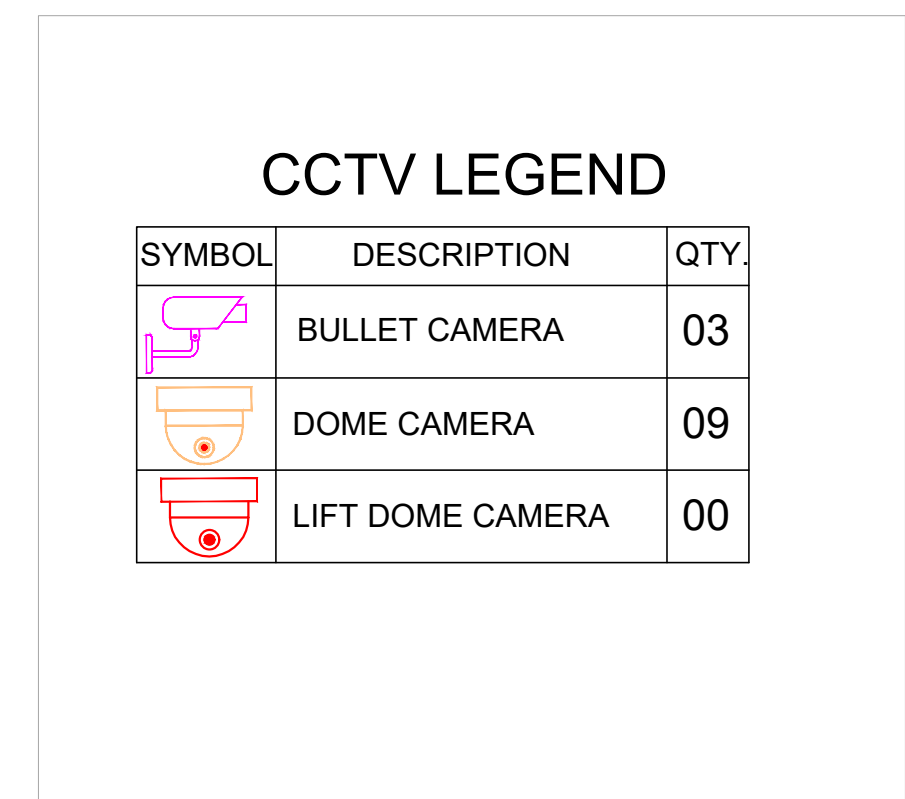

DWG NO : TD-E-CCTV-205


This drawing is the property of Mc D Built environment research laboratory Pvt Ltd, no part of the drawing may be reproduced in any manner whatsoever without permission from McD berl Pvt Ltd.



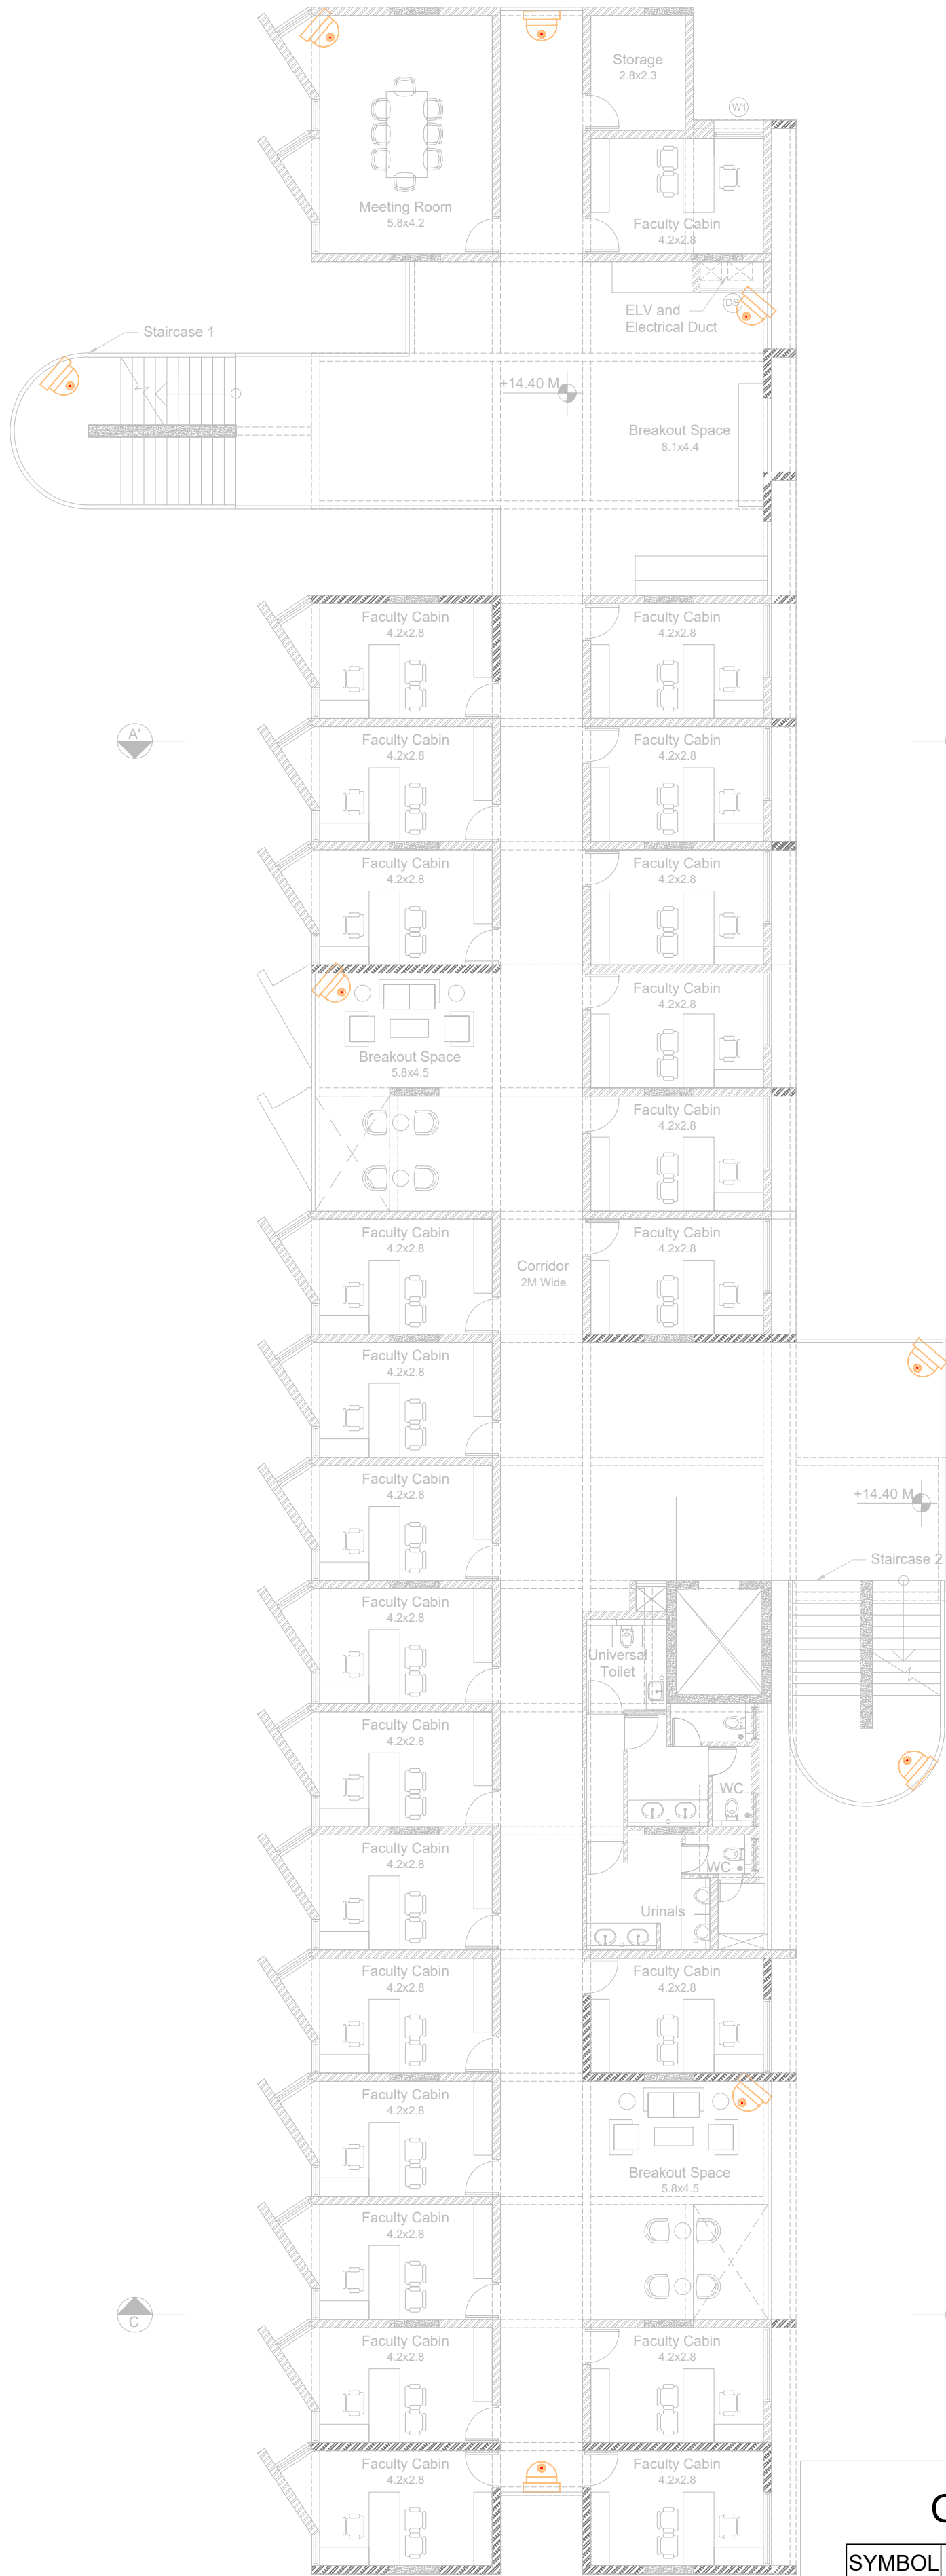


FOURTH FLOOR PLAN - New Faculty Block  
Scale- 1:100

CCTV LEGEND		
SYMBOL	DESCRIPTION	QTY.
	BULLET CAMERA	00
	DOME CAMERA	09
	LIFT DOME CAMERA	00

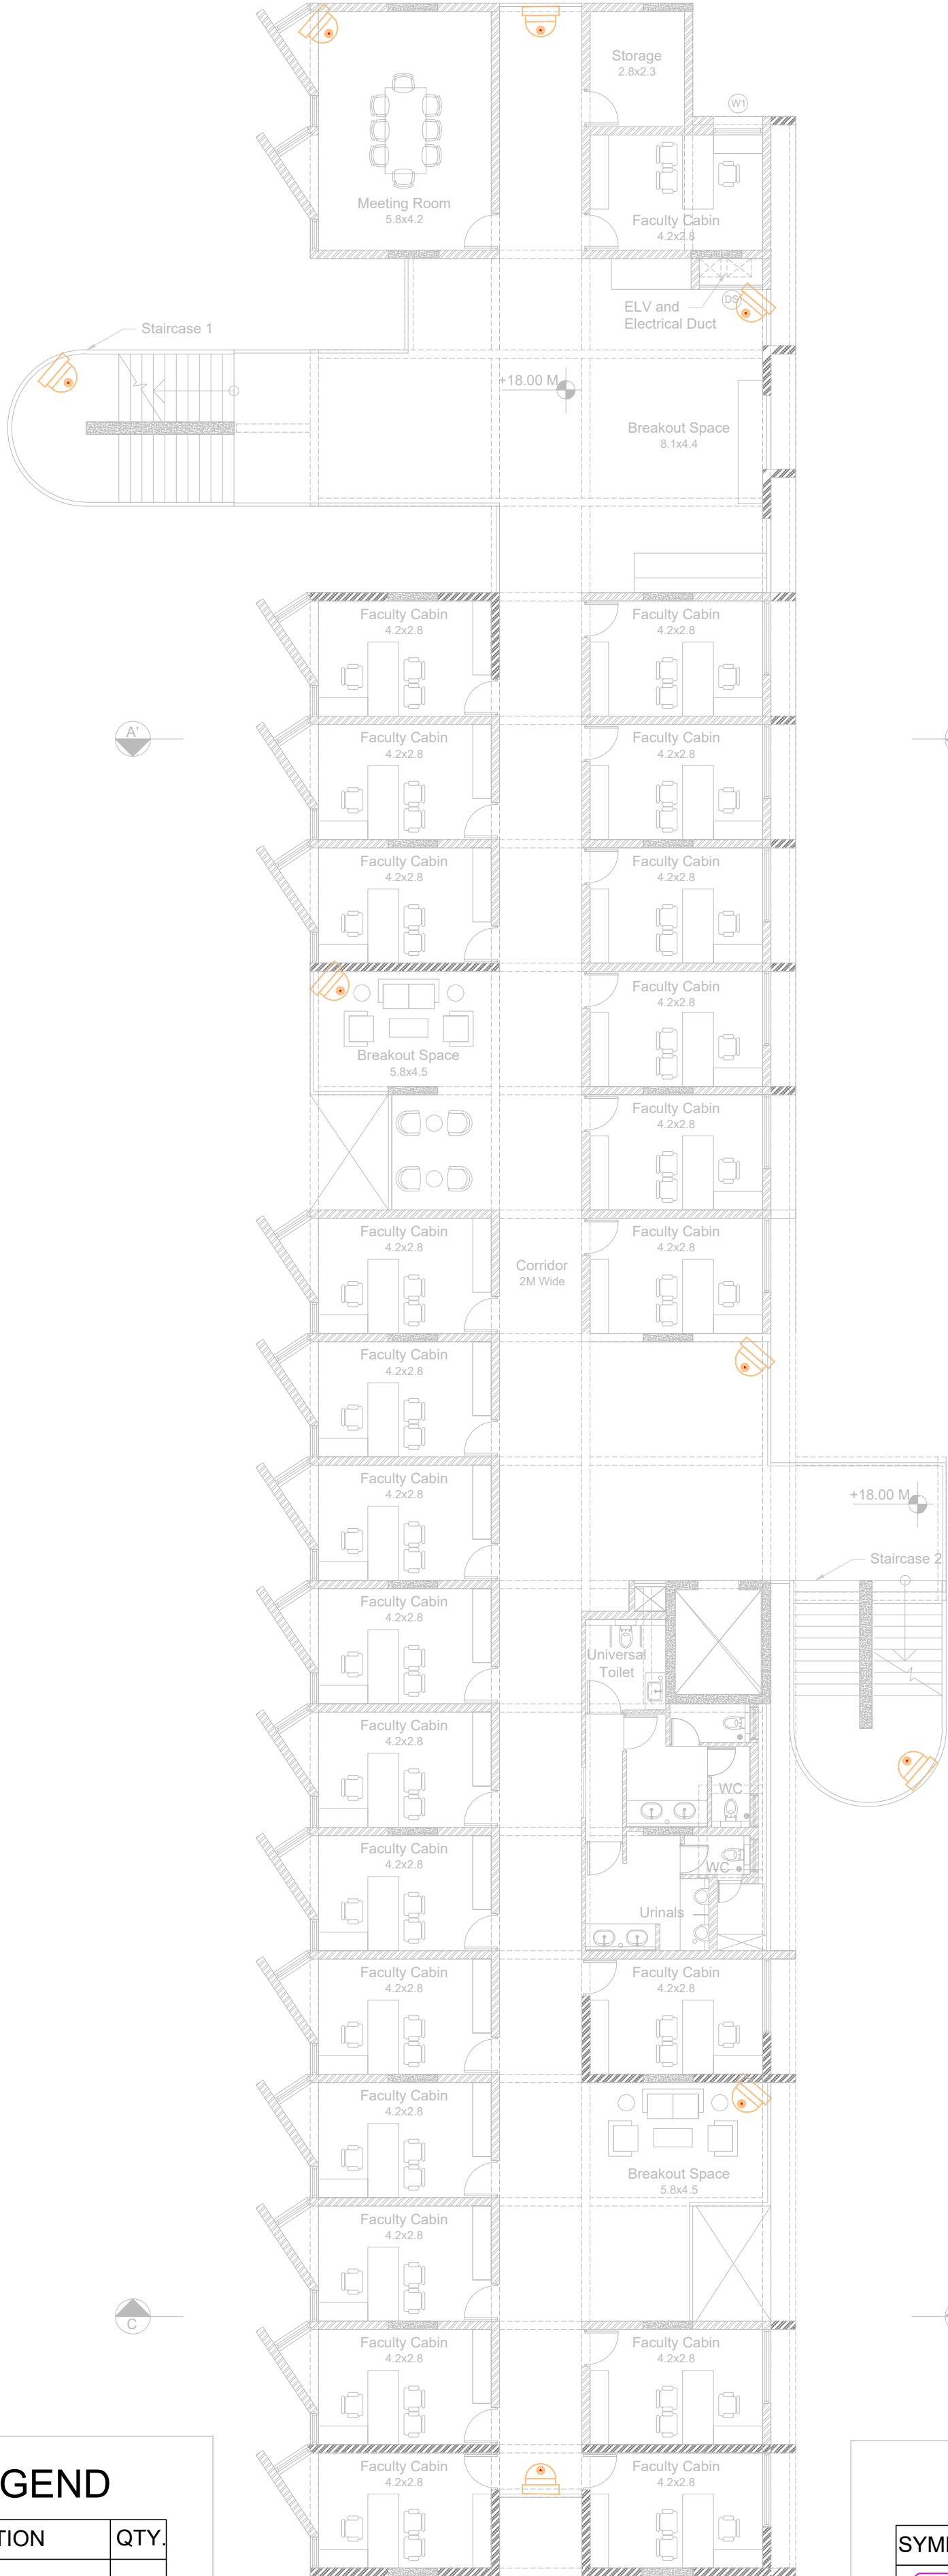

FIFTH FLOOR PLAN - New Faculty Block  
Scale- 1:100

CCTV LEGEND		
SYMBOL	DESCRIPTION	QTY.
	BULLET CAMERA	00
	DOME CAMERA	09
	LIFT DOME CAMERA	00

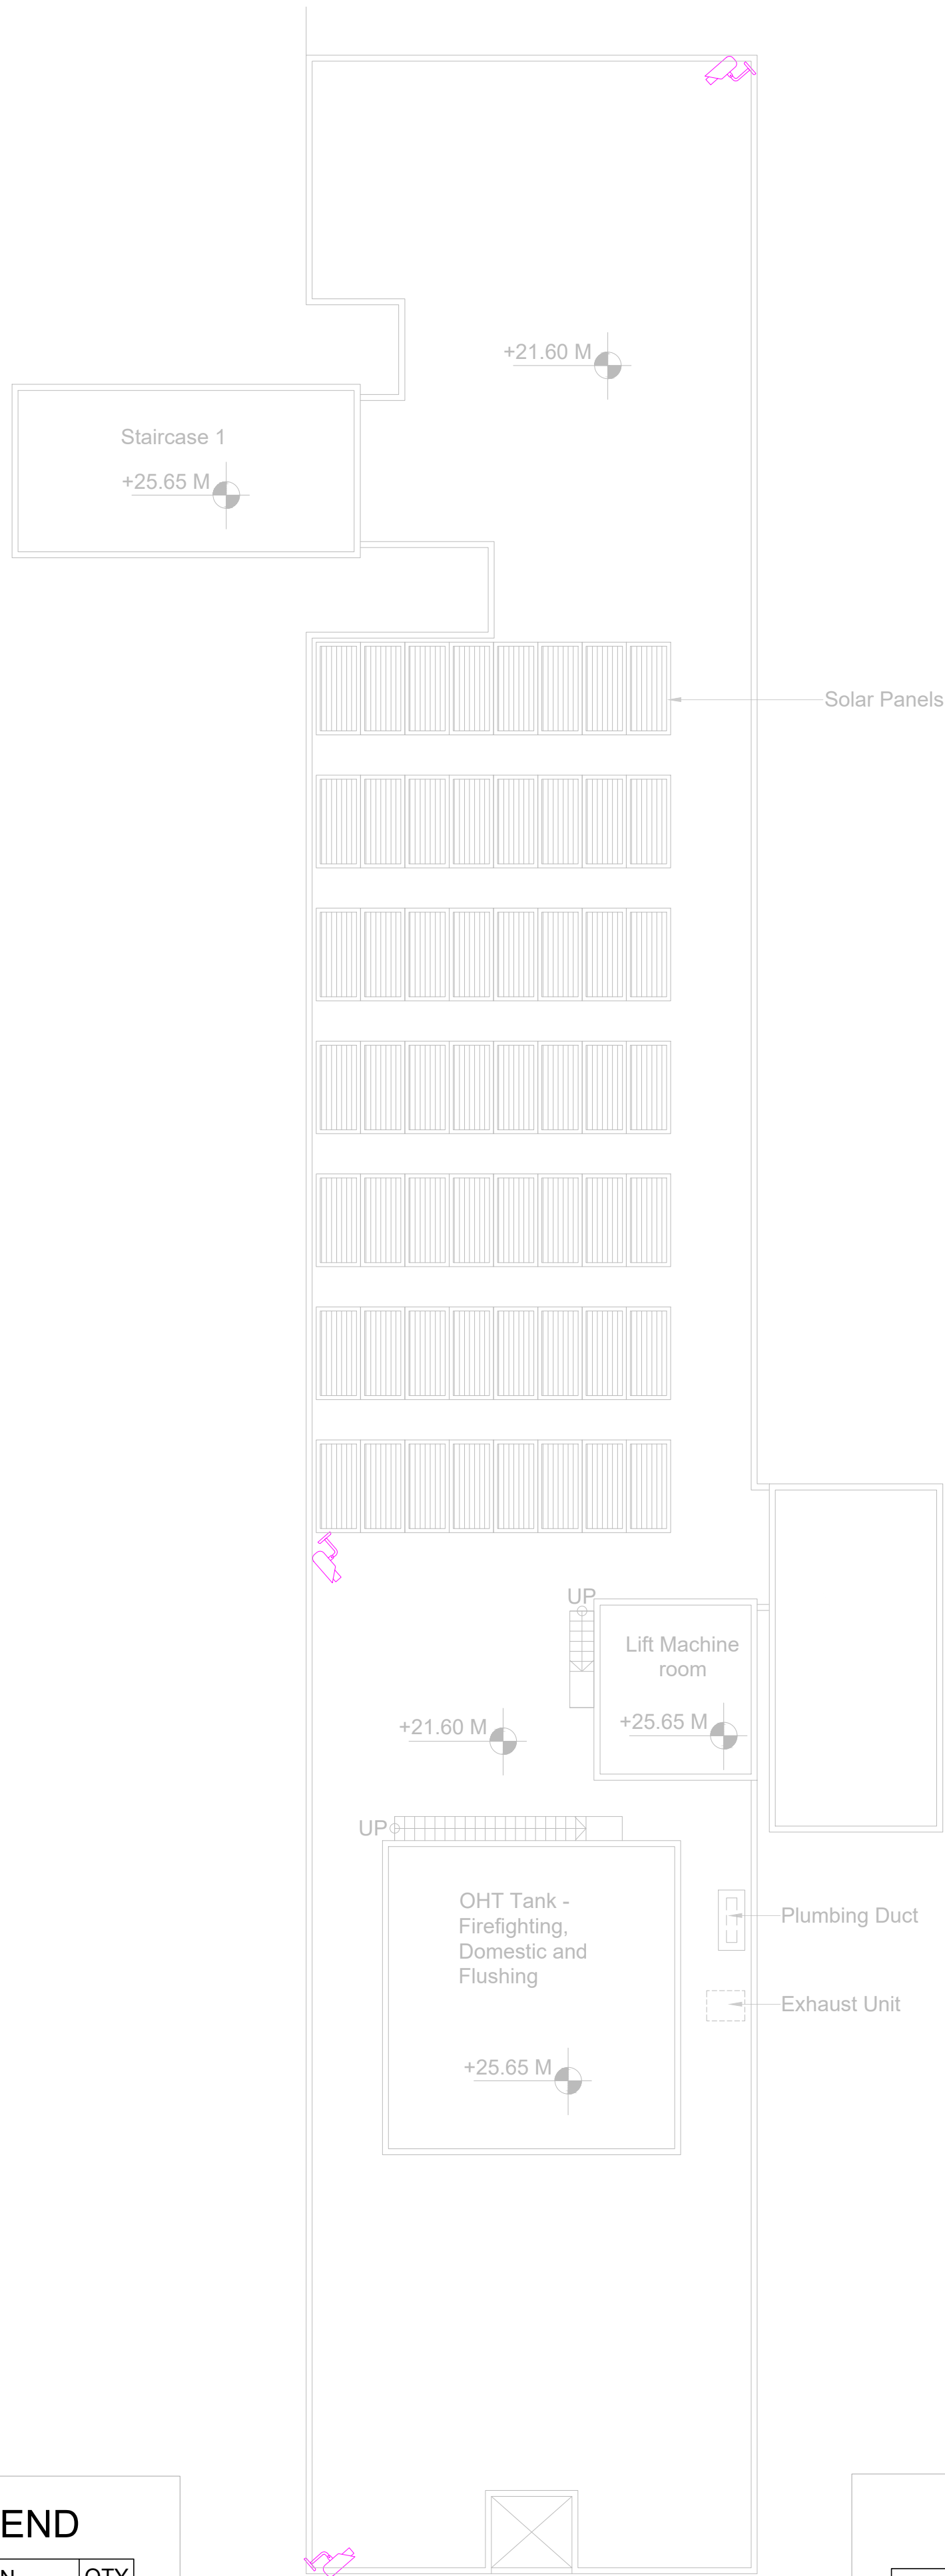

TERRACE FLOOR PLAN - New Faculty Block  
Scale- 1:100

CCTV LEGEND		
SYMBOL	DESCRIPTION	QTY.
	BULLET CAMERA WITH POLE SUPPORT	03
	DOME CAMERA	00
	LIFT DOME CAMERA	00

KEYPLAN :-

ISSUALS

REVISIONS

OWNER'S NAME :-

CLIENT :-

NLSIU BENGALURU

PROJECT ARCHITECT:-

**DCOOP**  
ARCHITECTURE DESIGN RESEARCH

UNIT NO. 109, 1ST FLOOR, SWASTIK CHAMBERS,  
SG BARVE ROAD, CHEMBUR, MUMBAI - 400071  
PH: 24706945/46 E-MAIL: mail@dcoop.in

OFFICE SEAL :-

MEP & SUSTAINABILITY CONSULTANT :-



Mc D Built Environment Research Laboratory Pvt Ltd,  
Green building,Sustainability and MEP services,  
No 12,Subramanya Arcade, Tower B , Opposite to Jalbhavan, Old  
Gurappanapalya, BTM 1st stage ,Bannerghita road ,Bangalore-560 029.  
Ph:+91 80 41222020,URL: www.mcdberl.com

PROJECT TITLE :-

NLSIU BENGALURU

TENDER STAGE

DRAWING TITLE :-

FOURTH,FIFTH FLOOR &  
TERRACE CCTV LAYOUT

PHASE	:	BLOCK	:	SCALE	:
DESIGNED	:	RS	DATE	:	11.12.2024 1:125
DRAWN	:	RS	APPROVED	:	MEGHANA REV NO:
CHECKED	:	MEGHANA	SHEET	:	A1 R1

DWG NO : TD--E--CCTV--206

This drawing is the property of Mc D Built environment research  
laboratory Pvt Ltd, no part of the drawing may be reproduced in  
any manner whatsoever without permission from McD berl Pvt Ltd.