







FIRE ALARM SYSTEM

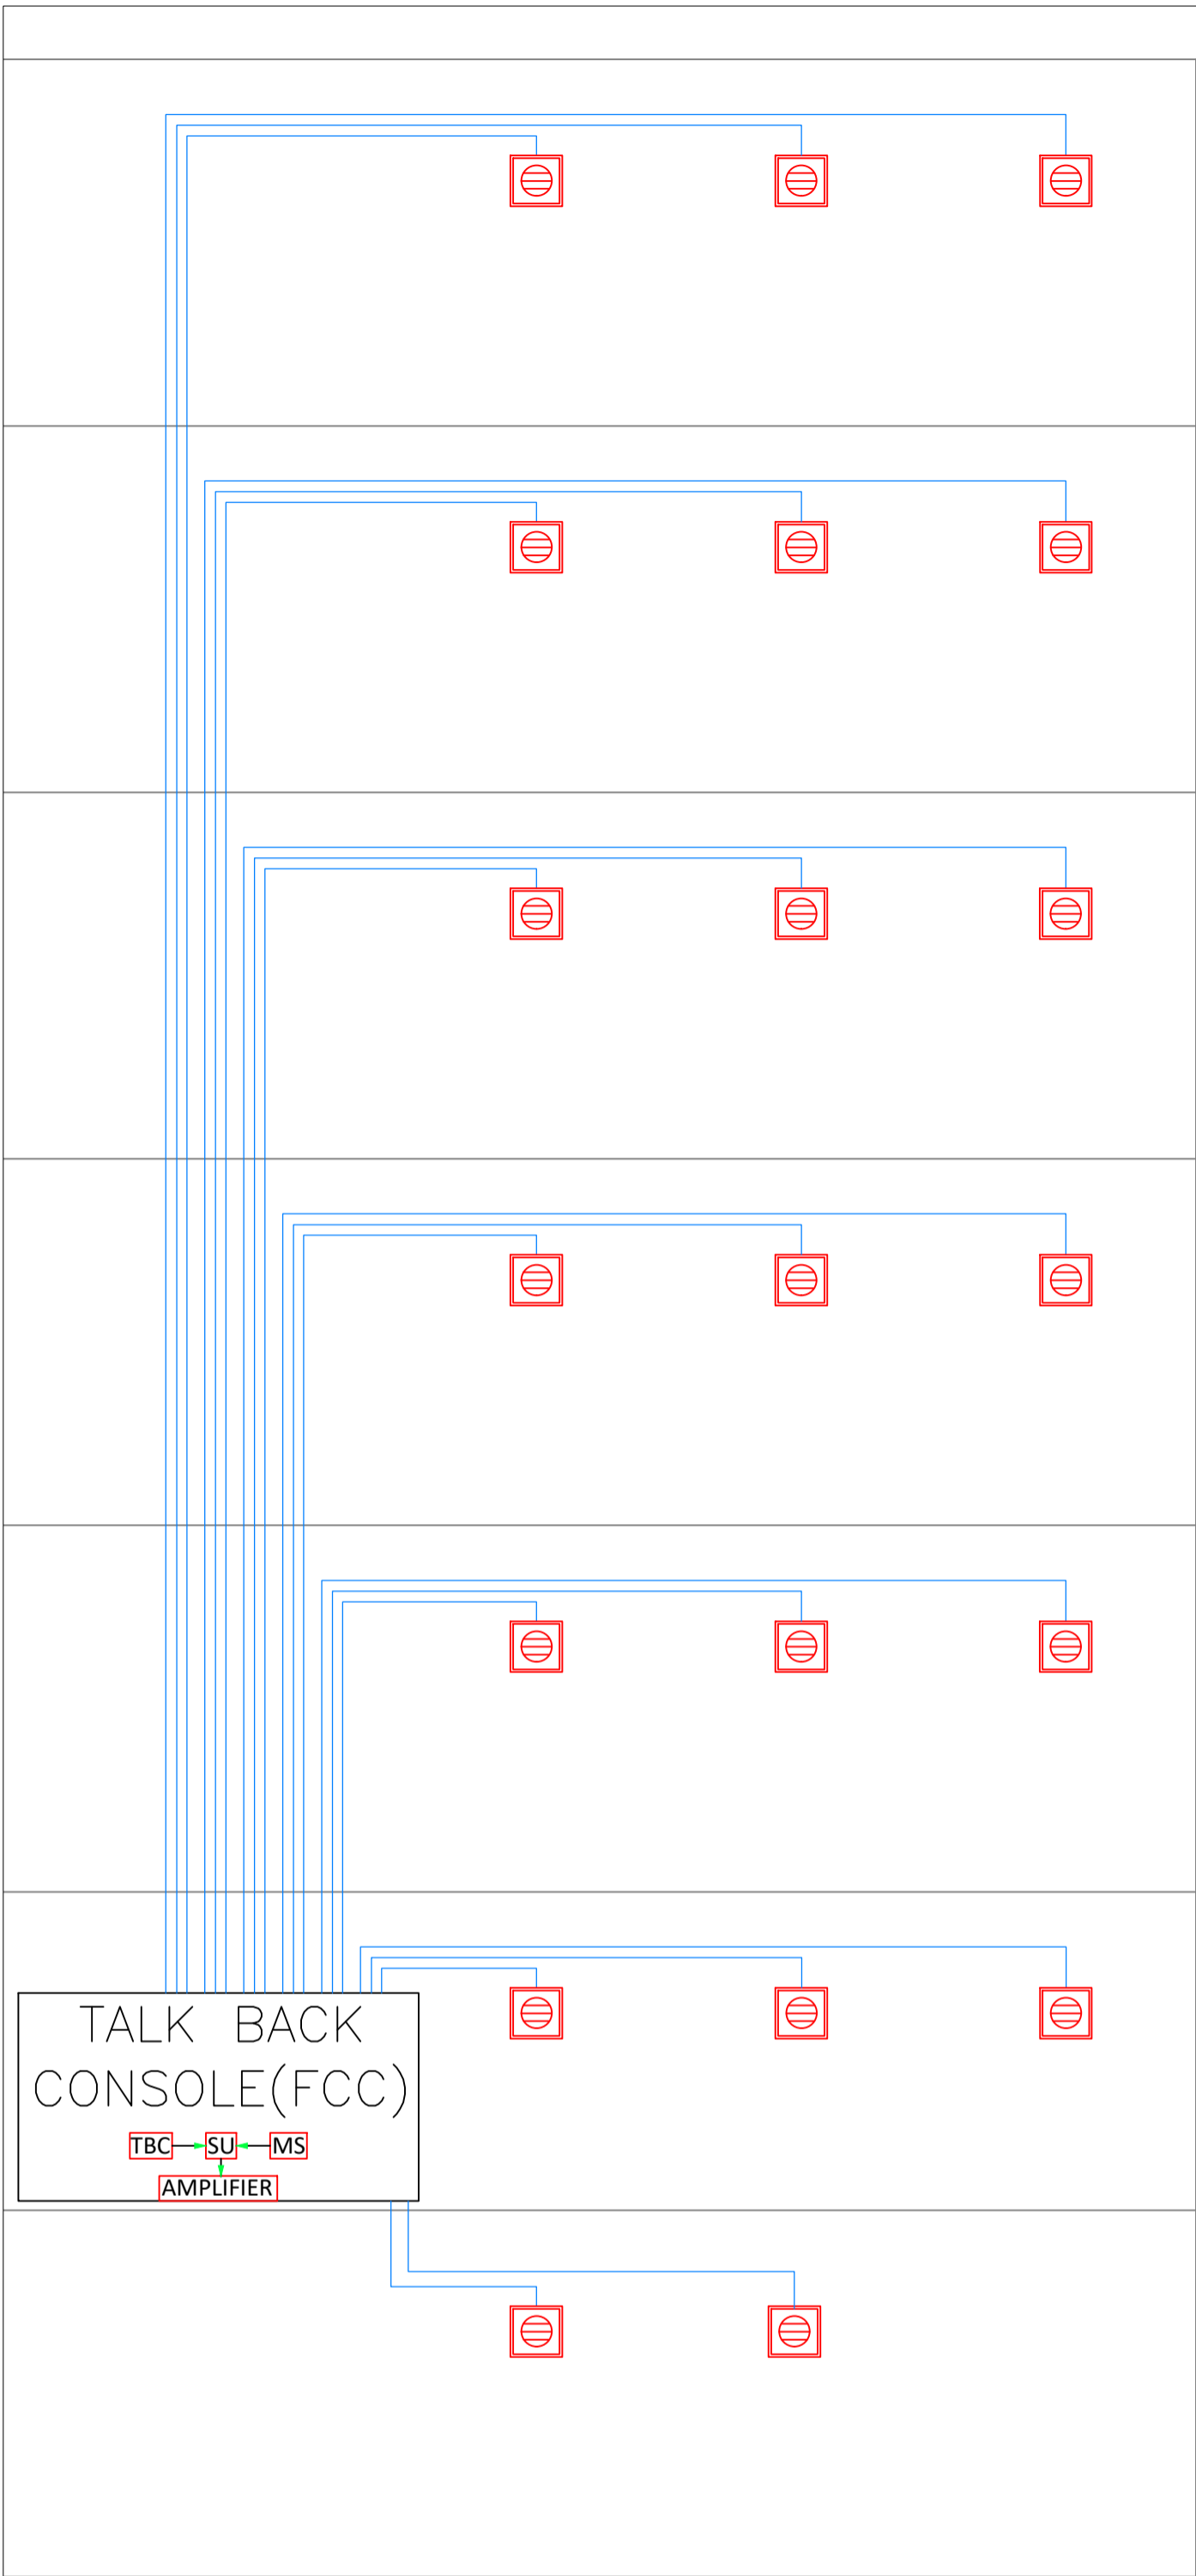

TALK-BACK SYSTEM



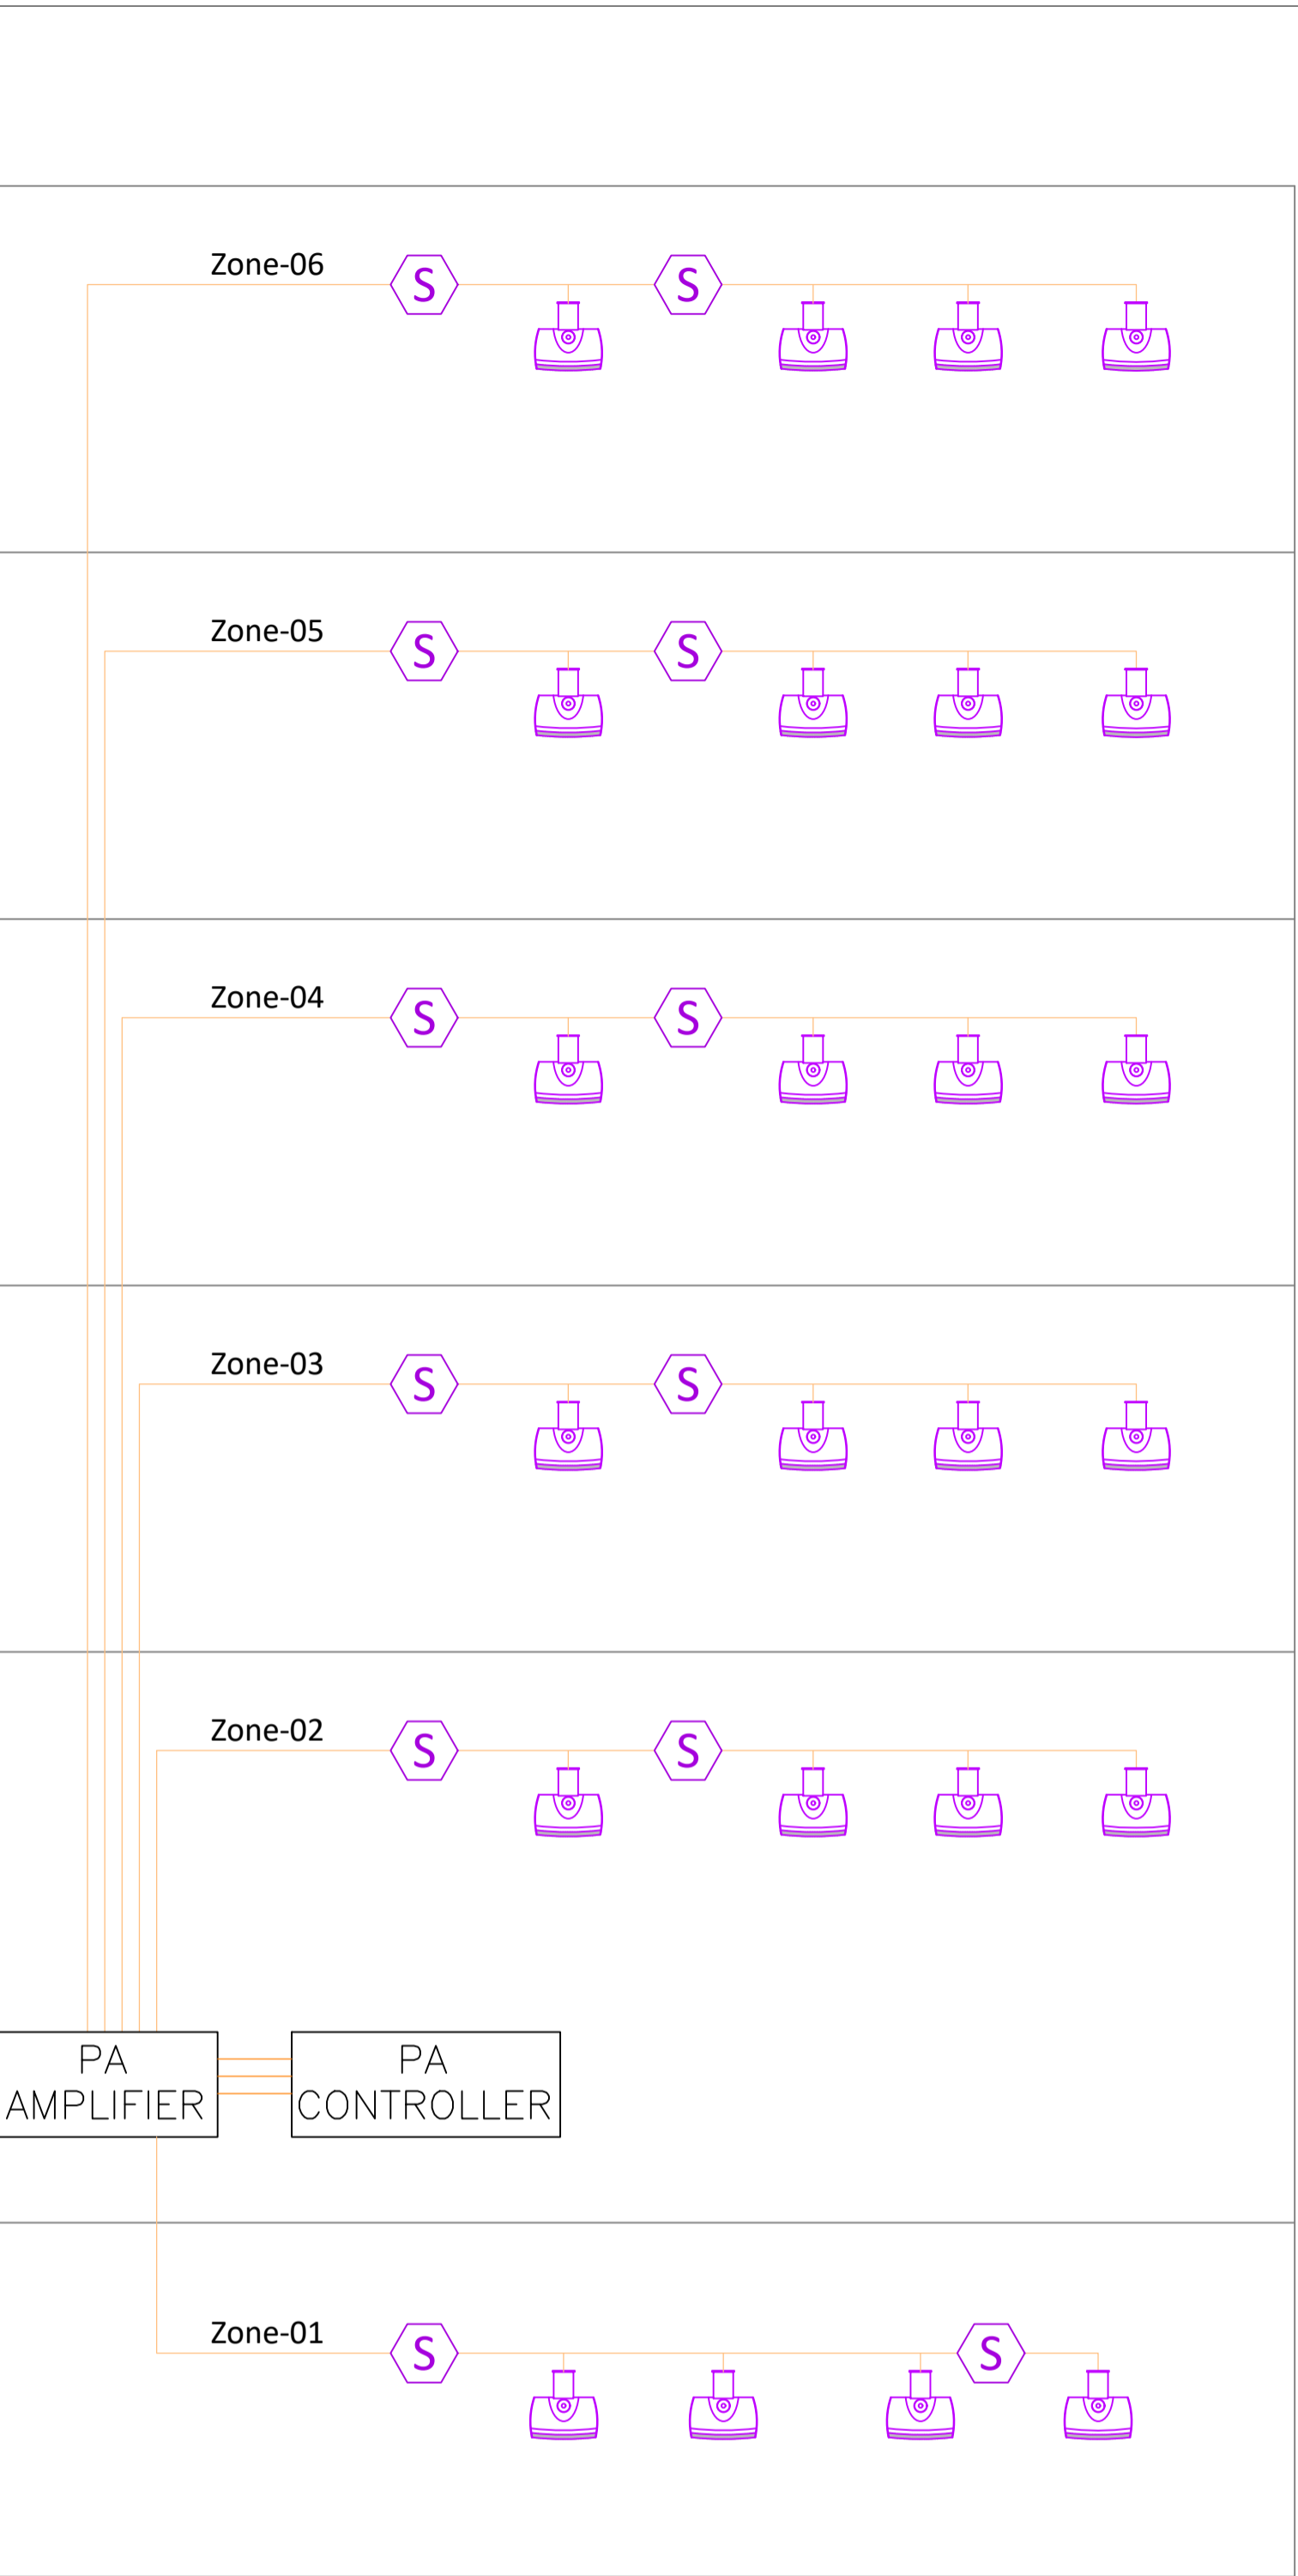


FIRE ALARM SYSTEM

SYMBOL	DESCRIPTION
	FIRE ALARM PANEL
	MANUAL CALL POINT
	HOOTER
	2Cx1.5 SQ. MM PVC INSULATED, FRLS, MULTI STRAND, FLEXIBLE COPPER CONDUCTORS (WIRES)




PUBLIC ADDRESS SYSTEM

PUBLIC ADDRESS SYSTEM

SYMBOL	DESCRIPTION
	PA CONSOLE
	PA AMPLIFIER
	WALL MOUNTED PA SPEAKER
	CEILING MOUNTED SPEAKER
	2Cx1.0 Sq.mm FRLS PVC INSULATED ARMoured CABLE

KEY PLAN

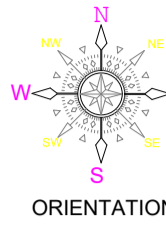

GEENERAL NOTES:

- THIS DRAWING SHALL BE READ IN CONJUNCTION WITH ALL RELEVANT ARCHITECTURAL, STRUCTURAL AND OTHER SERVICES DRAWINGS.
- ANY DISCREPANCY NOTICED SHALL BE BROUGHT TO THE ATTENTION OF THE CONSULTANTS AND RESOLVED PRIOR TO PROCUREMENT / EXECUTION OF WORKS.
- ALL DIMENSIONS ARE IN MILLIMETERS AND ALL LEVELS ARE IN METERS UNLESS OTHERWISE INDICATED.
- FOLLOW WRITTEN DIMENSIONS ONLY, DO NOT SCALE THE DRAWING.

REV. NO.	REVISION DESCRIPTION	DATE
R0	ISSUED FOR TENDER	07.02.2025
R1	REVISED AS PER ARCH DRAWINGS & SCHEME	05.03.2025
R2		
R3		
R4		
R5		
R6		

PROJECT

JSW ACADEMIC BLOCK - NLSIU  
NEW ACADEMIC BLOCK Gnana Bharathi  
Main Rd, Teachers Colony, Naagarabhaavi,  
Bengaluru, Karnataka 560072

CLIENT

NATIONAL LAW SCHOOL OF  
INDIA UNIVERSITY  
Gnana Bharathi Main Rd, Teachers  
Colony, Naagarabhaavi, Bengaluru,  
Karnataka 560072

ARCHITECT

**HUNDREDHANDS**  
9/2, Madras Bank Road,  
Shanthala Nagar, Ashok Nagar, Bengaluru,  
Karnataka 560001

STRUCTURAL

**RAYS CONSULTING ENGINEERS**  
#30, 1st Main, 6th Cross,  
UAS layout, Sanjay Nagar,  
Bangalore - 560094

MEPF AND IBMS CONSULTANTS

**LEAD** LEAD CONSULTANCY & ENGINEERING  
SERVICES (INDIA) Pvt. Ltd.  
No.2729, 1st FLOOR, 80 FEET ROAD,  
INDIRA NAGAR III STAGE, BENGALURU-560038, KARNATAKA,  
Phone: +91 80 42980111, Web: lcasind.org  
India: Bengaluru| Mumbai | Pune| Gurgaon| Chennai| Hyderabad| Kolkata

DRAWING TITLE

**FIRE ALARM ,TWO WAY TALK BACK &  
PUBLIC ADDRESS SYSTEM SYSTEMS  
SCHEMATIC LAYOUT**

DRAWN BY	YTM	DRAWING NUMBER	SCALE
CHECKED	YTM	LCES-NLS-FAPA-SCH-03	1:150
APPROVED	SURESH	REVISION - R1	SHEET SIZE
		DATE	05.03.2025

DRAWING ISSUED FOR

TENDER

THIS DRAWING IS SOLE PROPERTY OF **LEAD CONSULTANCY**  
USE OF THIS DRAWING FOR ANY PURPOSE OTHER THAN THAT  
MENTIONED TO BE DONE ONLY AFTER THEIR PRIOR APPROVAL.