

GENERAL NOTES:

1. THIS DRAWING SHALL BE READ IN CONJUNCTION WITH ALL RELEVANT ARCHITECTURAL, STRUCTURAL AND OTHER SERVICES DRAWINGS.
2. ANY DISCREPANCY NOTICED SHALL BE BROUGHT TO THE ATTENTION OF THE CONSULTANTS AND RESOLVED PRIOR TO PROCUREMENT / EXECUTION OF WORKS.
3. ALL DIMENSIONS ARE IN MILLIMETERS AND ALL LEVELS ARE IN METERS UNLESS OTHERWISE INDICATED.
4. FOLLOW WRITTEN DIMENSIONS ONLY, DO NOT SCALE THE DRAWING.

LIGHT FIXTURE LEGEND:

SNO	SYMBOL	DESCRIPTION
1	●	10W RECESSED MOUNTED DOWN LIGHT FIXTURE FOR MEETING ROOM
2	●	10W RECESSED MOUNTED DOWN LIGHT FIXTURE FOR TOILET AREA
3	Ⓢ	20W LED RECESSED MOUNTED DOWN LIGHT
4	●	30W LED SURFACE MOUNTED DOWN LIGHT FOR CORRIDOR AREA
5	—	LED 20W SUSPENDED MOUNTED BATTEN LIGHT FIXTURE FOR CLASS ROOM
6	—	LED 20W SUSPENDED MOUNTED BATTEN LIGHT FIXTURE DIMMABLE FOR CLASS ROOM
7	—	LED 30W RECESSED MOUNTED BATTEN LIGHT FIXTURE DIMMABLE FOR CLASS ROOM
8	—	LED 30W RECESSED MOUNTED BATTEN LIGHT FIXTURE DIMMABLE FOR CLASS ROOM
9	—	LED 40W SUSPENDED MOUNTED BATTEN LIGHT FIXTURE
10	—	LED 40W SUSPENDED MOUNTED BATTEN LIGHT FIXTURE DIMMABLE
11	Ⓢ	DAY LIGHT SENSOR
12	Ⓢ	OCCUPANCY SENSOR
13	Ⓢ	SINGLE POLE SWITCH FOR LIGHTING
14	Ⓢ	FAN REGULATOR
15	Ⓢ	10W LED BULK HEAD LIGHT FIXTURE FOR
16	Ⓢ	10W WALL MOUNTED MIRROR LIGHT FIXTURE FOR TOILET
17	Ⓢ	120W WALL MOUNTED BULB CEILING FAN WITH REGULATOR
18	Ⓢ	40W 4 FT SUSPENDED LINEAR LIGHT FIXTURE FOR SERVICE ROOM
19	Ⓢ	10W LED SURFACE MOUNTED CIRCULAR LIGHT FIXTURE FOR STAIRCASE AREA
20	Ⓢ	STEP LAMP
21	Ⓢ	SURFACE / WALL MOUNTED LINEAR LIGHT FIXTURE SUITABLE FOR 40W LED
22	Ⓢ	BRIGHT MOUNTED LIGHT FIXTURE DIMMABLE LED

REV. NO.	REVISION DESCRIPTION	DATE
R0	ISSUED FOR TENDER	11.02.2025
R1		
R2		
R3		
R4		
R5		
R6		

PROJECT

JSW ACADEMIC BLOCK - NLSIU
NEW ACADEMIC BLOCK Gnaa Bharathi
Main Rd, Teachers Colony, Naagarabhaavi,
Bengaluru, Karnataka 560072

CLIENT

NATIONAL LAW SCHOOL OF
INDIA UNIVERSITY
Gnaa Bharathi Main Rd, Teachers
Colony, Naagarabhaavi, Bengaluru,
Karnataka 560072

ARCHITECT



HUNDREDHANDS
9/2, Madras Bank Road,
Shanthala Nagar, Ashok Nagar, Bengaluru,
Karnataka 560001

MEPF AND IBMS CONSULTANTS



LEAD CONSULTANCY & ENGINEERING
SERVICES (INDIA) Pvt.Ltd.

No.2779, 1st FLOOR, 80 FEET ROAD
INDIRA NAGAR B STAGE, BENGALURU-560038, KARNATAKA.
Phone: +91 80 42980111, Web: lcsindia.org
India: Bengaluru| Mumbai | Pune| Gurgaon | Chennai | Hyderabad | Kolkata

DRAWING TITLE


BASEMENT LIGHTING LAYOUT

DRAWN BY	HMD	DRAWING NUMBER	SCALE	1:150
CHECKED	SSK	LCES-NLS-E-101	SHEET SIZE	A1
APPROVED	PD	REV - R0	DATE	11.02.2025

DRAWING ISSUED FOR

TENDER

THIS DRAWING IS SOLE PROPERTY OF LEAD CONSULTANCY
USE OF THIS DRAWING FOR ANY PURPOSE OTHER THAN THAT
MENTIONED TO BE DONE ONLY AFTER THEIR PRIOR APPROVAL.

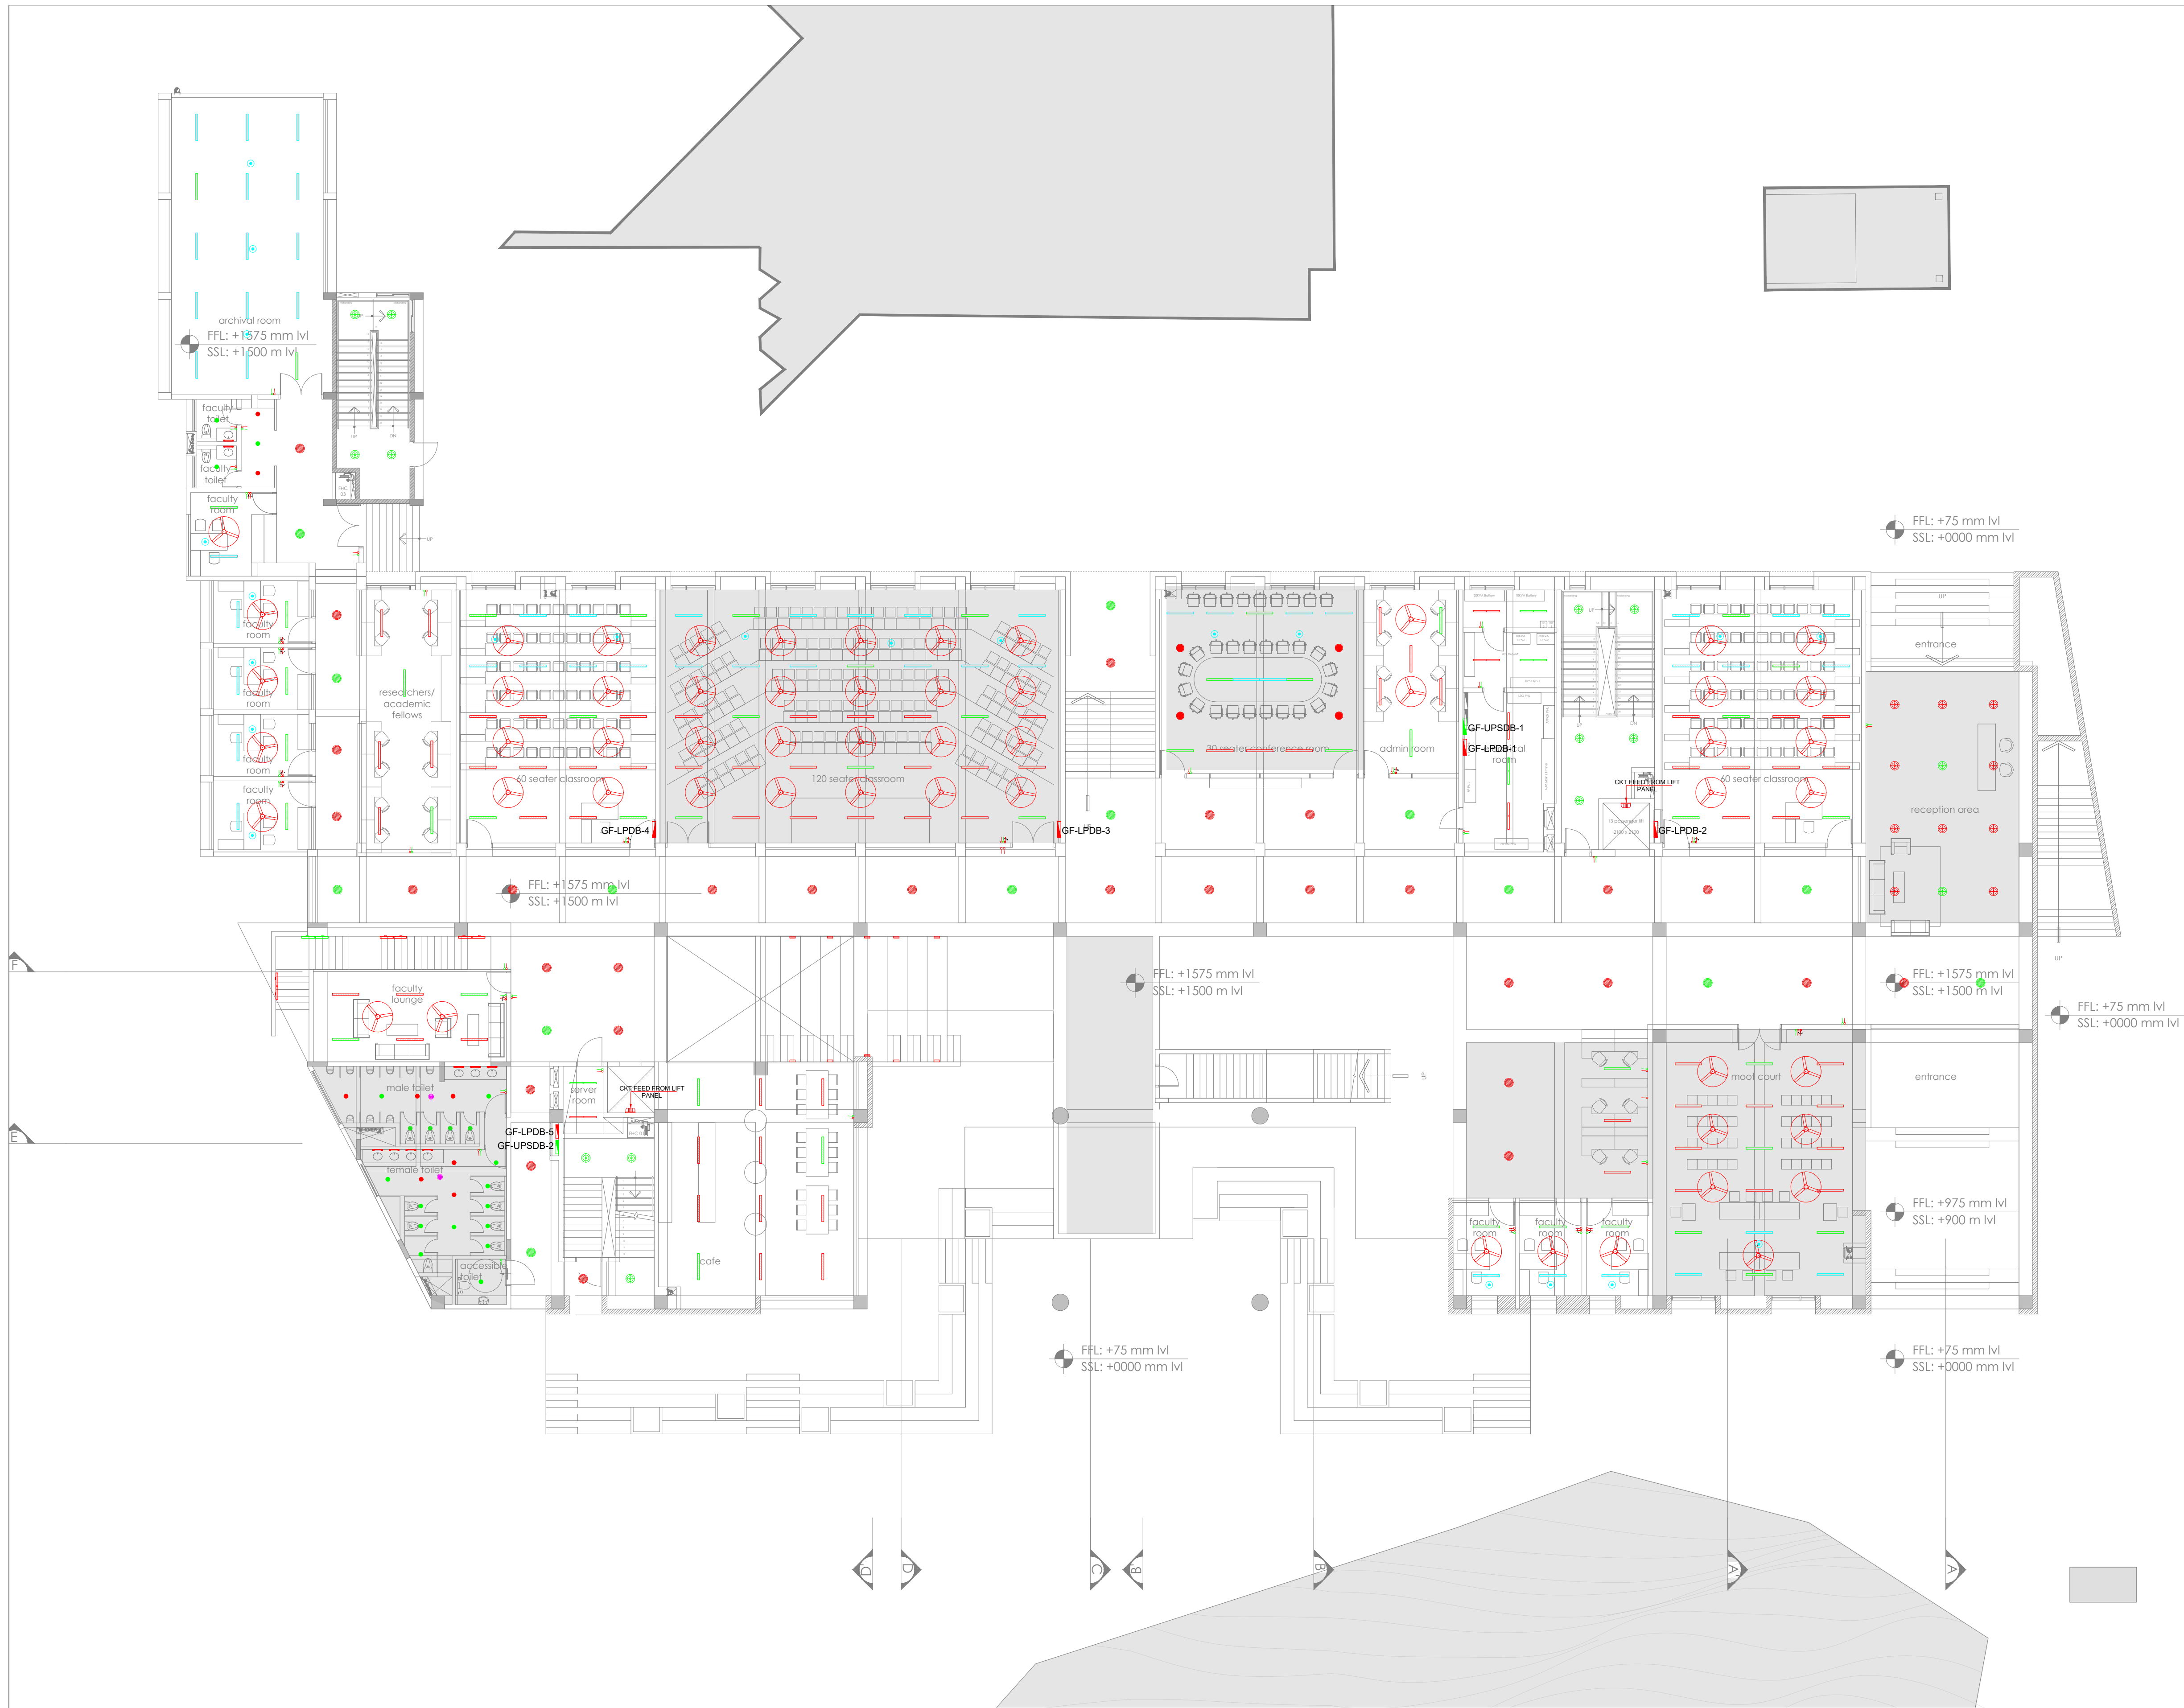

- GENERAL NOTES:**
- THIS DRAWING SHALL BE READ IN CONJUNCTION WITH ALL RELEVANT ARCHITECTURAL, STRUCTURAL AND OTHER SERVICES DRAWINGS.
 - ANY DISCREPANCY NOTICED SHALL BE BROUGHT TO THE ATTENTION OF THE CONSULTANTS AND RESOLVED PRIOR TO PROCUREMENT / EXECUTION OF WORKS.
 - ALL DIMENSIONS ARE IN MILLIMETERS AND ALL LEVELS ARE IN METERS UNLESS OTHERWISE INDICATED.
 - FOLLOW WRITTEN DIMENSIONS ONLY, DO NOT SCALE THE DRAWING.

LIGHT FIXTURE LEGEND:		
SNO	SYMS	DESCRIPTION
1	●	10W RECESSED MOUNTED DOWN LIGHT FIXTURE FOR MEETING ROOM
2	●	10W RECESSED MOUNTED DOWN LIGHT FIXTURE FOR TOILET AREA
3	●	20W LED RECESSED MOUNTED DOWN LIGHT
4	●	30W LED SURFACE MOUNTED DOWN LIGHT FOR CORRIDOR AREA
5	●	LED 20W SUSPENDED MOUNTED BATTEN LIGHT FIXTURE FOR CLASS ROOM
6	●	LED 20W SUSPENDED MOUNTED BATTEN LIGHT FIXTURE DIMMABLE FOR CLASS ROOM
7	●	LED 30W RECESSED MOUNTED BATTEN LIGHT FIXTURE FOR CLASS ROOM
8	●	LED 30W RECESSED MOUNTED BATTEN LIGHT FIXTURE DIMMABLE FOR CLASS ROOM
9	●	LED 40W SUSPENDED MOUNTED BATTEN LIGHT FIXTURE
10	●	LED 40W SUSPENDED MOUNTED BATTEN LIGHT FIXTURE DIMMABLE
11	●	DAY LIGHT SENSOR
12	●	OCCUPANCY SENSOR
13	●	SINGLE POLE SWITCH FOR LIGHTING
14	●	FAN REGULATOR
15	●	10W LED BULK HEAD LIGHT FIXTURE FOR
16	●	10W WALL MOUNTED MIRROR LIGHT FIXTURE FOR TOILET
17	●	120W WALL MOUNTED BLOC CEILING FAN WITH REGULATOR
18	●	40W 4 FT SUSPENDED LINEAR LIGHT FIXTURE FOR SERVICE ROOM
19	●	10W LED SURFACE MOUNTED CIRCULAR LIGHT FIXTURE FOR STAIRCASE AREA
20	●	STEP LAMP
21	●	SURFACE / WALL MOUNTED LINEAR LIGHT FIXTURE SUITABLE FOR 40W LED

REV. NO.	REVISION DESCRIPTION	DATE
R0	ISSUED FOR TENDER	11.02.2025
R1		
R2		
R3		
R4		
R5		
R6		

PROJECT

JSW ACADEMIC BLOCK - NLSIU
NEW ACADEMIC BLOCK Gnan Bharathi Main Rd, Teachers Colony, Naagarabhaavi, Bengaluru, Karnataka 560072

CLIENT

NATIONAL LAW SCHOOL OF INDIA UNIVERSITY
Gnan Bharathi Main Rd, Teachers Colony, Naagarabhaavi, Bengaluru, Karnataka 560072

ARCHITECT

HUNDREDHANDS
9/2, Madras Bank Road, Shanthala Nagar, Ashok Nagar, Bengaluru, Karnataka 560001

MEPF AND IBMS CONSULTANTS


LEAD LEAD CONSULTANCY & ENGINEERING SERVICES (INDIA) Pvt.Ltd.
No.2729, 1st FLOOR, 80 FEET ROAD, INDRA NAGAR B STAGE, BENGALURU-560038, KARNATAKA.
Phone: +91 80 42980111, Web: lcsindia.org
India: Bengaluru | Mumbai | Pune | Gurgaon | Chennai | Hyderabad | Kolkata

DRAWING TITLE			
GF LIGHTING LAYOUT			
DRAWN BY	HMD	DRAWING NUMBER	SCALE
CHECKED	SSK	LCES-NLS-E-102	1:150
APPROVED	PD	REV - R0	SHEET SIZE
			A1
			DATE
			11.02.2025

DRAWING ISSUED FOR

TENDER

THIS DRAWING IS SOLE PROPERTY OF **LEAD CONSULTANCY**
USE OF THIS DRAWING FOR ANY PURPOSE OTHER THAN THAT MENTIONED TO BE DONE ONLY AFTER THEIR PRIOR APPROVAL.

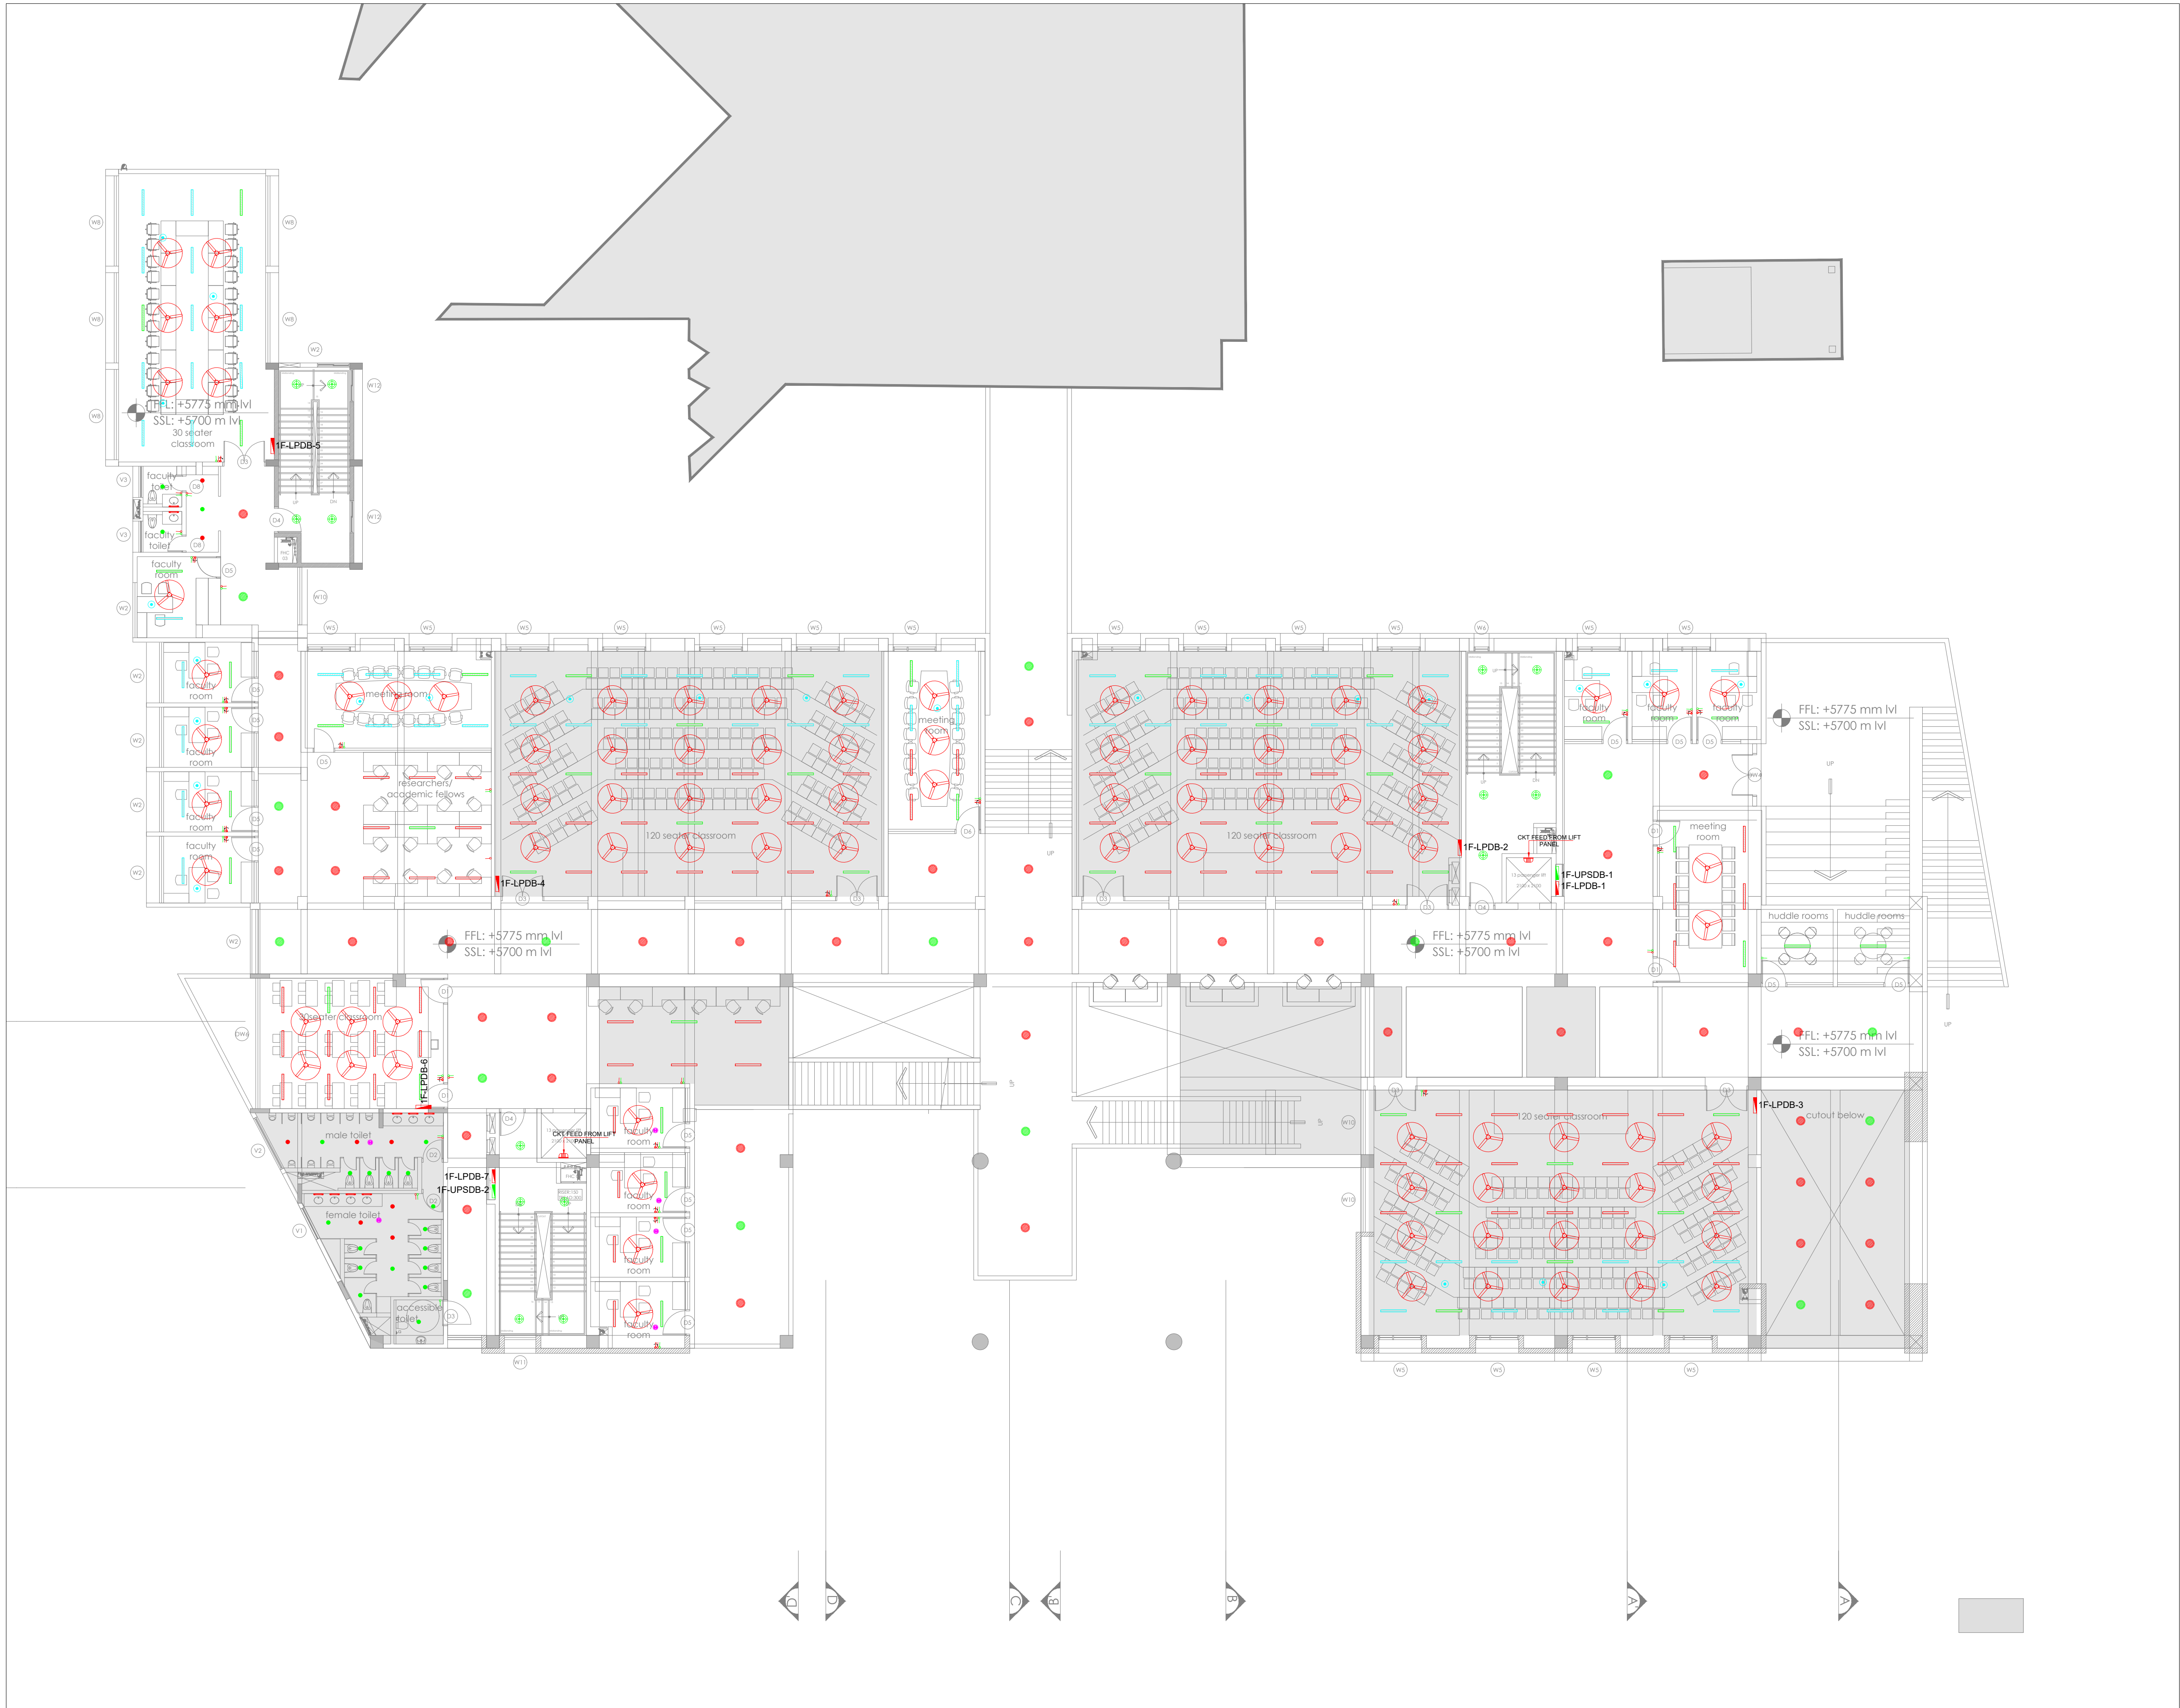

- GENERAL NOTES:**
1. THIS DRAWING SHALL BE READ IN CONJUNCTION WITH ALL RELEVANT ARCHITECTURAL, STRUCTURAL AND OTHER SERVICES DRAWINGS.
 2. ANY DISCREPANCY NOTICED SHALL BE BROUGHT TO THE ATTENTION OF THE CONSULTANTS AND RESOLVED PRIOR TO PROCUREMENT / EXECUTION OF WORKS.
 3. ALL DIMENSIONS ARE IN MILLIMETERS AND ALL LEVELS ARE IN METERS UNLESS OTHERWISE INDICATED.
 4. FOLLOW WRITTEN DIMENSIONS ONLY. DO NOT SCALE THE DRAWING.

LIGHT FIXTURE LEGEND:		
SNO	SYMBOL	DESCRIPTION
1		10W RECESSED MOUNTED DOWN LIGHT FIXTURE FOR MEETING ROOM
2		10W RECESSED MOUNTED DOWN LIGHT FIXTURE FOR TOILET AREA
3		20W LED RECESSED MOUNTED DOWN LIGHT
4		10W LED SURFACE MOUNTED DOWN LIGHT FOR COMMON AREA
5		LED 20W SUSPENDED MOUNTED BATTEN LIGHT FIXTURE FOR CLASS ROOM
6		LED 20W SUSPENDED MOUNTED BATTEN LIGHT FIXTURE DIMMABLE FOR CLASS ROOM
7		LED 20W RECESSED MOUNTED BATTEN LIGHT FIXTURE FOR CLASS ROOM
8		LED 20W RECESSED MOUNTED BATTEN LIGHT FIXTURE DIMMABLE FOR CLASS ROOM
9		LED 20W SUSPENDED MOUNTED BATTEN LIGHT FIXTURE
10		LED 20W SUSPENDED MOUNTED BATTEN LIGHT FIXTURE DIMMABLE
11		DAY LIGHT SENSOR
12		OCCUPANCY SENSOR
13		SINGLE POLE SWITCH FOR LIGHTING
14		FAN REGULATOR
15		10W LED BULK HEAD LIGHT FIXTURE FOR
16		10W WALL MOUNTED MIRROR LIGHT FIXTURE FOR TOILET
17		100W MM SHEET LED CEILING FAN WITH REGULATOR
18		40W 4FT SUSPENDED LINEAR LIGHT FIXTURE FOR SERVICE ROOM
19		10W LED SURFACE MOUNTED CIRCULAR LIGHT FIXTURE FOR STAIRCASE AREA
20		STEP LAMP
21		SURFACE / WALL MOUNTED LINEAR LIGHT FIXTURE SUITABLE FOR 40W LED

REV. NO.	REVISION DESCRIPTION	DATE
R0	ISSUED FOR TENDER	11.02.2025
R1		
R2		
R3		
R4		
R5		
R6		

PROJECT

JSW ACADEMIC BLOCK - NLSIU
NEW ACADEMIC BLOCK Gnaa Bharathi Main Rd, Teachers Colony, Naagarabhaavi, Bengaluru, Karnataka 560072

CLIENT

NATIONAL LAW SCHOOL OF INDIA UNIVERSITY
Gnaa Bharathi Main Rd, Teachers Colony, Naagarabhaavi, Bengaluru, Karnataka 560072

ARCHITECT

HUNDREDHANDS
9/2, Madras Bank Road, Shanthala Nagar, Ashok Nagar, Bengaluru, Karnataka 560001

MEPF AND IBMS CONSULTANTS


LEAD LEAD CONSULTANCY & ENGINEERING SERVICES (INDIA) Pvt.Ltd.
Eco Friendly Solutions
No.2729, 1st FLOOR, 80 FEET ROAD, INDRA NAGAR II STAGE, BENGALURU-560038, KARNATAKA.
Phone: +91 80 42980111, Web: lcsind.org
India: Bengaluru | Mumbai | Pune | Gurgaon | Chennai | Hyderabad | Kolkata

DRAWING TITLE			
1F LIGHTING LAYOUT			
DRAWN BY	HMD	DRAWING NUMBER	SCALE
CHECKED	SSK	LCES-NLS-E-103	1:150
APPROVED	PD	REV - R0	SHEET SIZE
		DATE	A1
			11.02.2025

DRAWING ISSUED FOR

TENDER

THIS DRAWING IS SOLE PROPERTY OF **LEAD CONSULTANCY**
USE OF THIS DRAWING FOR ANY PURPOSE OTHER THAN THAT MENTIONED TO BE DONE ONLY AFTER THEIR PRIOR APPROVAL.

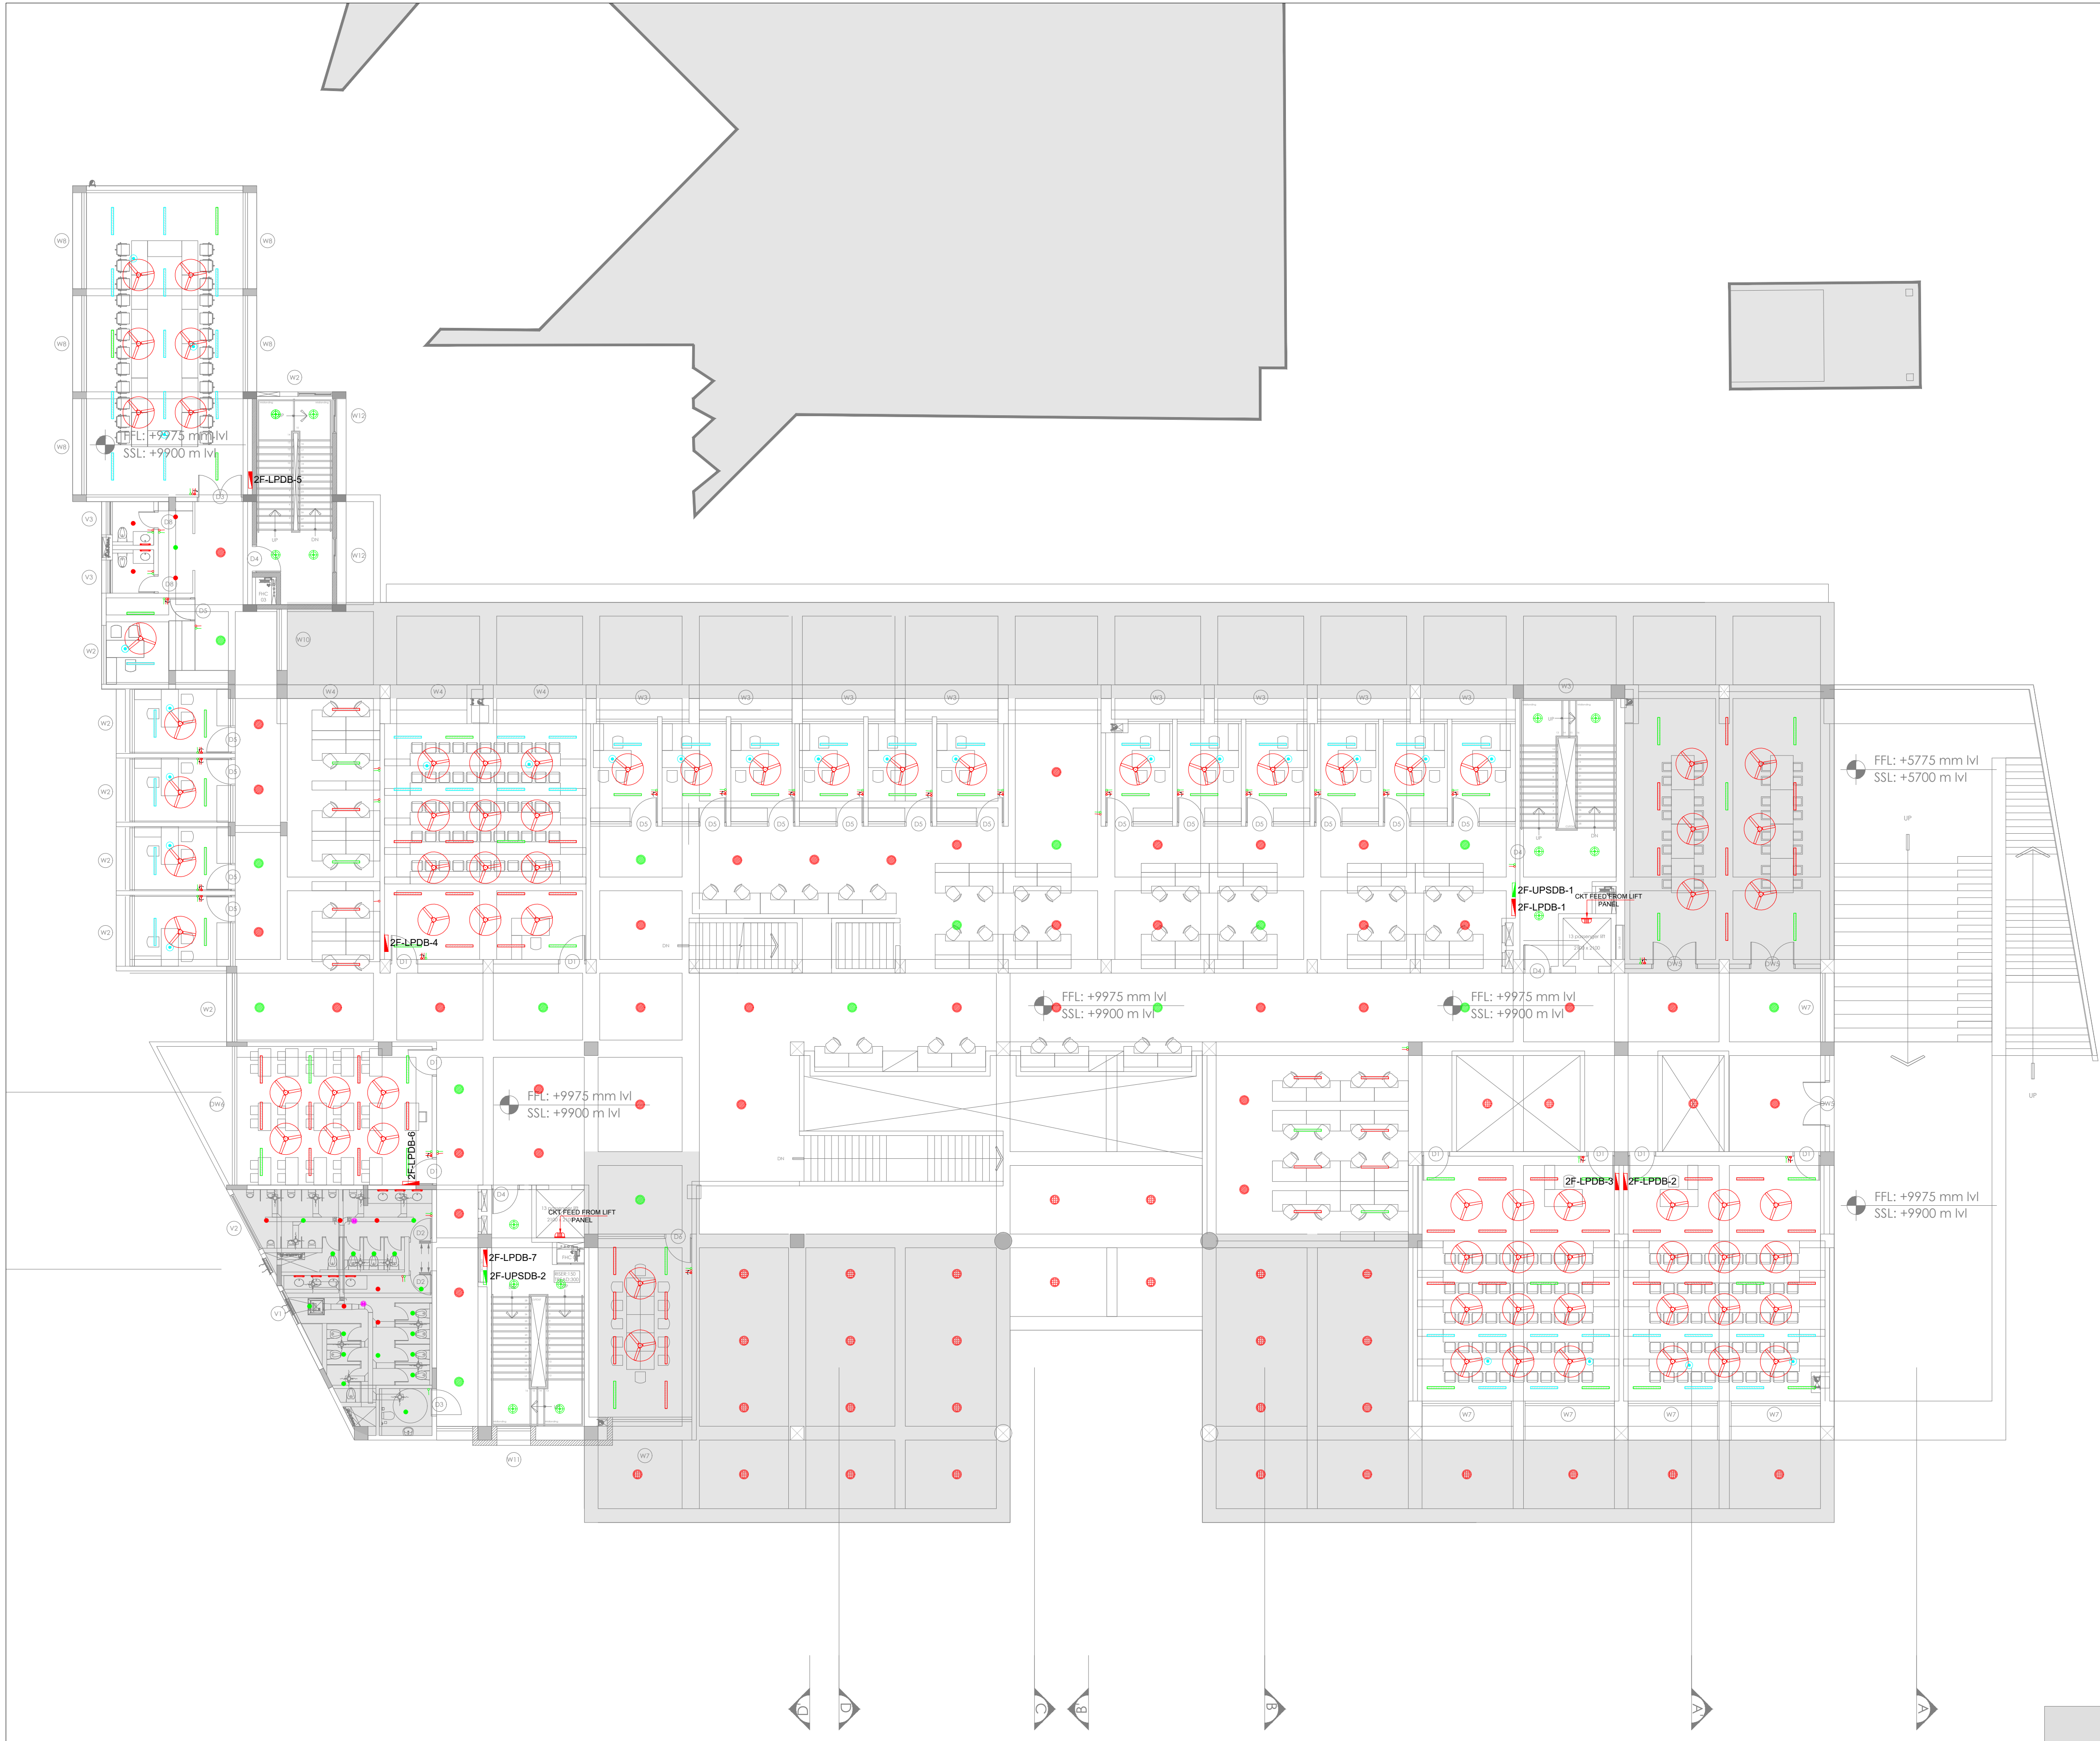

- GENERAL NOTES:**
1. THIS DRAWING SHALL BE READ IN CONJUNCTION WITH ALL RELEVANT ARCHITECTURAL, STRUCTURAL AND OTHER SERVICES DRAWINGS.
 2. ANY DISCREPANCY NOTICED SHALL BE BROUGHT TO THE ATTENTION OF THE CONSULTANTS AND RESOLVED PRIOR TO PROCUREMENT / EXECUTION OF WORKS.
 3. ALL DIMENSIONS ARE IN MILLIMETERS AND ALL LEVELS ARE IN METERS UNLESS OTHERWISE INDICATED.
 4. FOLLOW WRITTEN DIMENSIONS ONLY, DO NOT SCALE THE DRAWING.

LIGHT FIXTURE LEGEND:		
SNO	SYMBOL	DESCRIPTION
1	●	10W RECESSED MOUNTED DOWN LIGHT FIXTURE FOR MEETING ROOM
2	●	10W RECESSED MOUNTED DOWN LIGHT FIXTURE FOR TOILET AREA
3	●	20W LED RECESSED MOUNTED DOWN LIGHT
4	●	30W LED SURFACE MOUNTED DOWN LIGHT FOR CORRIDOR AREA
5	●	LED 20W SUSPENDED MOUNTED BATTEN LIGHT FIXTURE FOR CLASS ROOM
6	●	LED 20W SUSPENDED MOUNTED BATTEN LIGHT FIXTURE DIMMABLE FOR CLASS ROOM
7	●	LED 20W RECESSED MOUNTED BATTEN LIGHT FIXTURE FOR CLASS ROOM
8	●	LED 20W RECESSED MOUNTED BATTEN LIGHT FIXTURE DIMMABLE FOR CLASS ROOM
9	●	LED 40W SUSPENDED MOUNTED BATTEN LIGHT FIXTURE
10	●	LED 40W SUSPENDED MOUNTED BATTEN LIGHT FIXTURE DIMMABLE
11	●	DAY LIGHT SENSOR
12	●	OCCUPANCY SENSOR
13	●	SINGLE POLE SWITCH FOR LIGHTING
14	●	FAN REGULATOR
15	●	10W LED BULK HEAD LIGHT FIXTURE FOR
16	●	10W WALL MOUNTED MIRROR LIGHT FIXTURE FOR TOILET
17	●	120W MA FANPUMP BLDC CEILING FAN WITH REGULATOR
18	●	40W 4'7" SUSPENDED LINEAR LIGHT FIXTURE FOR SERVICE ROOM
19	●	10W SURFACE MOUNTED CIRCULAR LIGHT FIXTURE FOR STAIRCASE AREA
20	●	STEP LAMP
21	●	SURFACE / WALL MOUNTED LINEAR LIGHT FIXTURE SUITABLE FOR 40W LED

REV. NO.	REVISION DESCRIPTION	DATE
R0	ISSUED FOR TENDER	11.02.2025
R1		
R2		
R3		
R4		
R5		
R6		

PROJECT

JSW ACADEMIC BLOCK - NLSIU
NEW ACADEMIC BLOCK Gnanabharathi Main Rd, Teachers Colony, Naagarabhaavi, Bengaluru, Karnataka 560072

CLIENT

NATIONAL LAW SCHOOL OF INDIA UNIVERSITY
Gnanabharathi Main Rd, Teachers Colony, Naagarabhaavi, Bengaluru, Karnataka 560072

ARCHITECT

HUNDREDHANDS
9/2, Madras Bank Road, Shanthala Nagar, Ashok Nagar, Bengaluru, Karnataka 560001

MEPF AND IBMS CONSULTANTS


LEAD CONSULTANCY & ENGINEERING SERVICES (INDIA) Pvt.Ltd.
No.2729, 1st FLOOR, 80 FEET ROAD, HOSUR NAGAR 8 STAGE, BENGALURU-560038, KARNATAKA.
Phone: +91 80 42980111, Web: lcsindia.org
India: Bengaluru | Mumbai | Pune | Gurgaon | Chennai | Hyderabad | Kolkata

DRAWING TITLE			
2F LIGHTING LAYOUT			
DRAWN BY	HMD	DRAWING NUMBER	SCALE
CHECKED	SSK	LCES-NLS-E-104	1:150
APPROVED	PD	REV - R0	SHEET SIZE
			A1
			DATE
			11.02.2025

DRAWING ISSUED FOR

TENDER

THIS DRAWING IS SOLE PROPERTY OF **LEAD CONSULTANCY**.
USE OF THIS DRAWING FOR ANY PURPOSE OTHER THAN THAT MENTIONED TO BE DONE ONLY AFTER THEIR PRIOR APPROVAL.

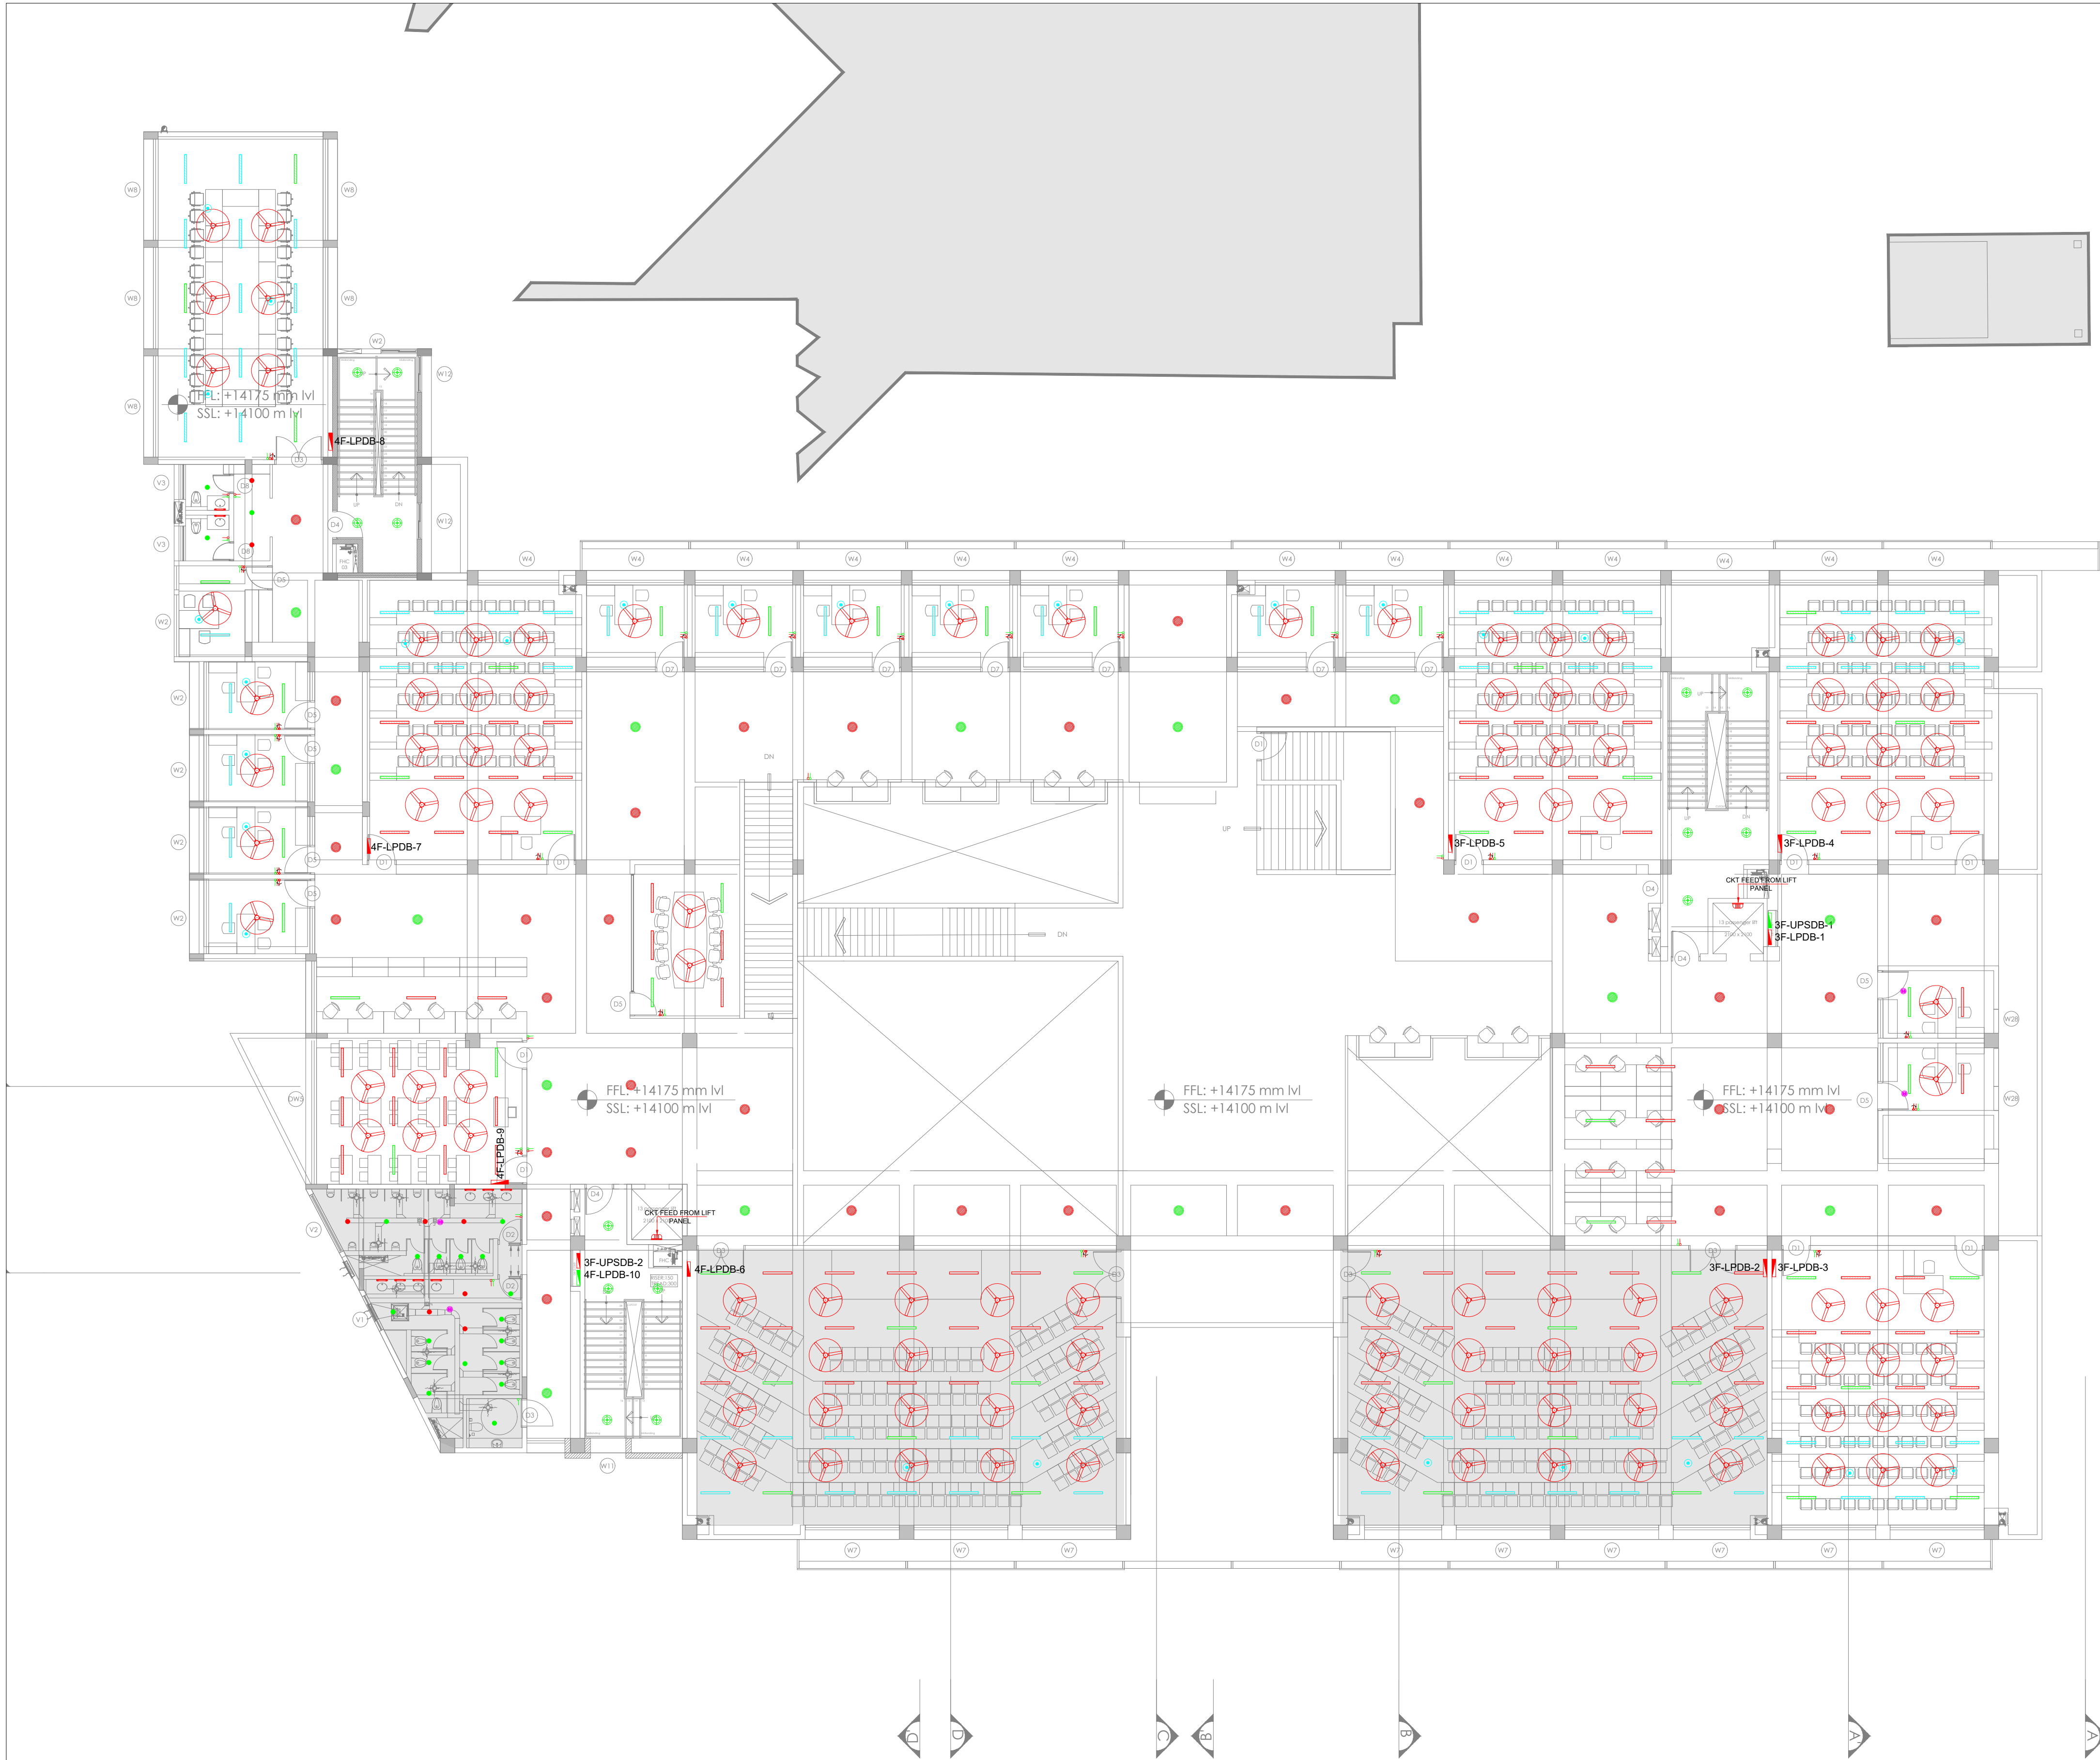

- GENERAL NOTES:**
1. THIS DRAWING SHALL BE READ IN CONJUNCTION WITH ALL RELEVANT ARCHITECTURAL, STRUCTURAL AND OTHER SERVICES DRAWINGS.
 2. ANY DISCREPANCY NOTICED SHALL BE BROUGHT TO THE ATTENTION OF THE CONSULTANTS AND RESOLVED PRIOR TO PROCUREMENT / EXECUTION OF WORKS.
 3. ALL DIMENSIONS ARE IN MILLIMETERS AND ALL LEVELS ARE IN METERS UNLESS OTHERWISE INDICATED.
 4. FOLLOW WRITTEN DIMENSIONS ONLY, DO NOT SCALE THE DRAWING.

LIGHT FIXTURE LEGEND:		
NO	SYMBOL	DESCRIPTION
1	●	10W RECESSED MOUNTED DOWN LIGHT FIXTURE FOR MEETING ROOM
2	●	10W RECESSED MOUNTED DOWN LIGHT FIXTURE FOR TOILET AREA
3	●	20W LED RECESSED MOUNTED DOWN LIGHT
4	●	30W LED SURFACE MOUNTED DOWN LIGHT FOR CORRIDOR AREA
5	—	LED 20W SUSPENDED MOUNTED BATTEN LIGHT FIXTURE FOR CLASS ROOM
6	—	LED 20W SUSPENDED MOUNTED BATTEN LIGHT FIXTURE FOR CLASS ROOM
7	—	LED 20W RECESSED MOUNTED BATTEN LIGHT FIXTURE FOR CLASS ROOM
8	—	LED 20W RECESSED MOUNTED BATTEN LIGHT FIXTURE DIMMABLE FOR CLASS ROOM
9	—	LED 40W SUSPENDED MOUNTED BATTEN LIGHT FIXTURE
10	—	LED 40W SUSPENDED MOUNTED BATTEN LIGHT FIXTURE DIMMABLE
11	●	DAY LIGHT SENSOR
12	●	OCCUPANCY SENSOR
13	—	SINGLE POLE SWITCH FOR LIGHTING
14	—	FAN REGULATOR
15	—	10W LED BULK HEAD LIGHT FIXTURE FOR
16	—	10W WALL MOUNTED MIRROR LIGHT FIXTURE FOR TOILET
17	—	100W WIRELESS BLUETOOTH CEILING FAN WITH REGULATOR
18	—	40W 8'7" SUSPENDED LINEAR LIGHT FIXTURE FOR SERVICE ROOM
19	—	10W LED SURFACE MOUNTED CIRCULAR LIGHT FIXTURE FOR STAIRCASE AREA
20	—	STEP LAMP
21	—	SURFACE / WALL MOUNTED LINEAR LIGHT FIXTURE SUITABLE FOR 40W LED

REV. NO.	REVISION DESCRIPTION	DATE
R0	ISSUED FOR TENDER	11.02.2025
R1		
R2		
R3		
R4		
R5		
R6		

PROJECT

JSW ACADEMIC BLOCK - NLSIU
NEW ACADEMIC BLOCK Gnanabharathi
Main Rd, Teachers Colony, Naagarabhaavi,
Bengaluru, Karnataka 560072

CLIENT

NATIONAL LAW SCHOOL OF
INDIA UNIVERSITY
Gnanabharathi Main Rd, Teachers
Colony, Naagarabhaavi, Bengaluru,
Karnataka 560072

ARCHITECT

HUNDREDEHANDS
9/2, Madras Bank Road,
Shanthala Nagar, Ashok Nagar, Bengaluru,
Karnataka 560001

MEPP AND IBMS CONSULTANTS

LEAD CONSULTANCY & ENGINEERING
SERVICES (INDIA) Pvt.Ltd.
No.2729, 1st FLOOR, 80 FEET ROAD
INDIRA NAGAR 8 STAGE, BENGALURU-560038, KARNATAKA.
Phone: +91 80 42980111, Web: lcsindia.org
India: Bengaluru | Mumbai | Pune | Gurgaon | Chennai | Hyderabad | Kolkata

DRAWING TITLE			
3F LIGHTING LAYOUT			
DRAWN BY	HMD	DRAWING NUMBER	LCES-NLS-E-105
CHECKED	SSK	SCALE	1:150
APPROVED	PD	REV - R0	DATE
			11.02.2025

DRAWING ISSUED FOR

TENDER

THIS DRAWING IS SOLE PROPERTY OF **LEAD CONSULTANCY**
USE OF THIS DRAWING FOR ANY PURPOSE OTHER THAN THAT
MENTIONED TO BE DONE ONLY AFTER THEIR PRIOR APPROVAL.



- GENERAL NOTES:**
- THIS DRAWING SHALL BE READ IN CONJUNCTION WITH ALL RELEVANT ARCHITECTURAL, STRUCTURAL AND OTHER SERVICES DRAWINGS.
 - ANY DISCREPANCY NOTICED SHALL BE BROUGHT TO THE ATTENTION OF THE CONSULTANTS AND RESOLVED PRIOR TO PROCUREMENT / EXECUTION OF WORKS.
 - ALL DIMENSIONS ARE IN MILLIMETERS AND ALL LEVELS ARE IN METERS UNLESS OTHERWISE INDICATED.
 - FOLLOW WRITTEN DIMENSIONS ONLY, DO NOT SCALE THE DRAWING.

LIGHT FIXTURE LEGEND:		
SNO	SYMBOL	DESCRIPTION
1	●	10W RECESSED MOUNTED DOWN LIGHT FIXTURE FOR MEETING ROOM
2	●	10W RECESSED MOUNTED DOWN LIGHT FIXTURE FOR TOILET AREA
3	●	20W LED RECESSED MOUNTED DOWN LIGHT
4	●	30W LED SURFACE MOUNTED DOWN LIGHT FOR CORRIDOR AREA
5	—	LED 20W SUSPENDED MOUNTED BATTEN LIGHT FIXTURE FOR CLASS ROOM
6	—	LED 20W SUSPENDED MOUNTED BATTEN LIGHT FIXTURE FOR CLASS ROOM
7	—	LED 20W RECESSED MOUNTED BATTEN LIGHT FIXTURE FOR CLASS ROOM
8	—	LED 20W RECESSED MOUNTED BATTEN LIGHT FIXTURE DIMMABLE FOR CLASS ROOM
9	—	LED 40W SUSPENDED MOUNTED BATTEN LIGHT FIXTURE
10	—	LED 40W SUSPENDED MOUNTED BATTEN LIGHT FIXTURE DIMMABLE
11	●	DAY LIGHT SENSOR
12	●	OCCUPANCY SENSOR
13	●	SINGLE POLE SWITCH FOR LIGHTING
14	●	FAN REGULATOR
15	●	10W LED BULK HEAD LIGHT FIXTURE FOR
16	●	10W WALL MOUNTED MIRROR LIGHT FIXTURE FOR TOILET
17	●	100W WALL MOUNTED MIRROR LIGHT FIXTURE FOR TOILET
18	●	40W 4 FT SUSPENDED LINEAR LIGHT FIXTURE FOR SERVICE ROOM
19	●	10W LED SURFACE MOUNTED CIRCULAR LIGHT FIXTURE FOR STAIRCASE AREA
20	●	STEP LAMP
21	●	SURFACE / WALL MOUNTED LINEAR LIGHT FIXTURE SUITABLE FOR 40W LED

REV. NO.	REVISION DESCRIPTION	DATE
R0	ISSUED FOR TENDER	11.02.2025
R1		
R2		
R3		
R4		
R5		
R6		

PROJECT

JSW ACADEMIC BLOCK - NLSIU
NEW ACADEMIC BLOCK Gnanabharathi Main Rd, Teachers Colony, Naagarabhaavi, Bengaluru, Karnataka 560072

CLIENT

NATIONAL LAW SCHOOL OF INDIA UNIVERSITY
Gnanabharathi Main Rd, Teachers Colony, Naagarabhaavi, Bengaluru, Karnataka 560072

ARCHITECT

HUNDREHANDS
9/2, Madras Bank Road, Shanthala Nagar, Ashok Nagar, Bengaluru, Karnataka 560001

MEPF AND IBMS CONSULTANTS


LEAD CONSULTANCY & ENGINEERING SERVICES (INDIA) Pvt.Ltd.
No.2729, 1st FLOOR, 80 FEET ROAD, INDRA NAGAR B STAGE, BEHGALURU-560038, KARNATAKA.
Phone: +91 80 42980111, Web: lcsindia.org
India: Bengaluru | Mumbai | Pune | Gurgaon | Chennai | Hyderabad | Kolkata

DRAWING TITLE			
4F LIGHTING LAYOUT			
DRAWN BY	HMD	DRAWING NUMBER	SCALE
CHECKED	SSK	LCES-NLS-E-106	SHEET SIZE
APPROVED	PD	REV - R0	DATE

DRAWING ISSUED FOR

TENDER

THIS DRAWING IS SOLE PROPERTY OF **LEAD CONSULTANCY**
USE OF THIS DRAWING FOR ANY PURPOSE OTHER THAN THAT MENTIONED TO BE DONE ONLY AFTER THEIR PRIOR APPROVAL.

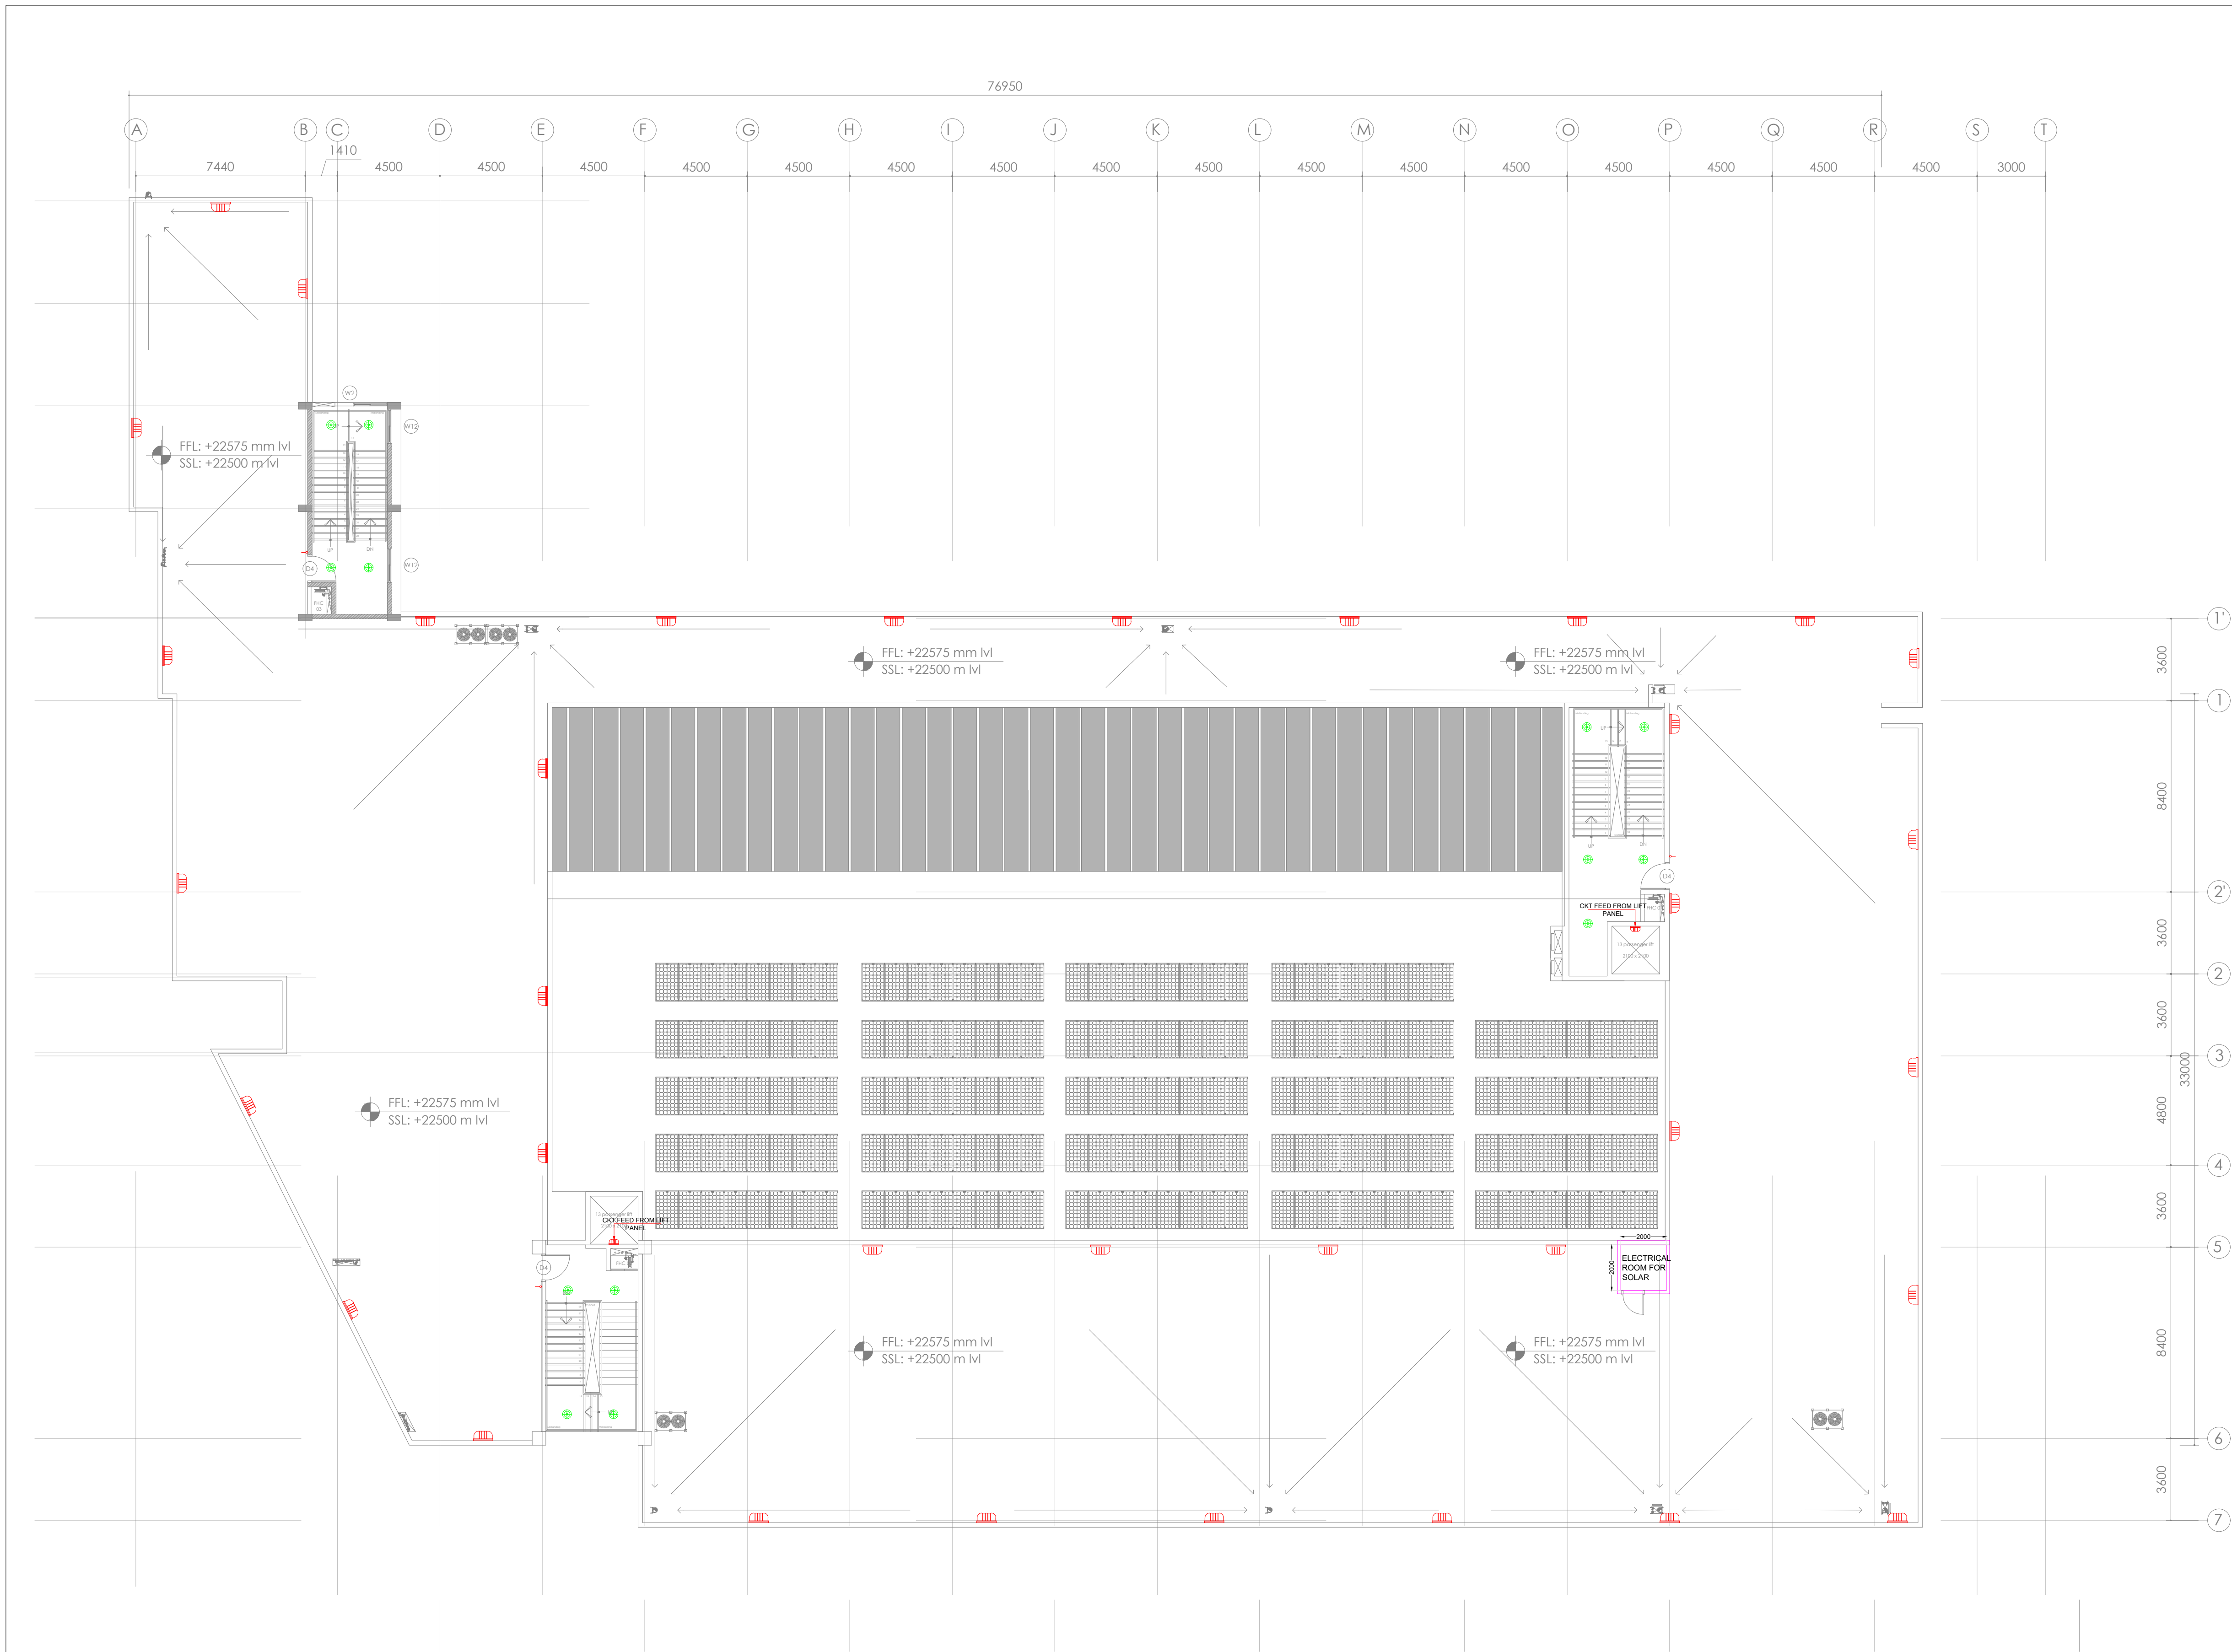

- GENERAL NOTES:**
1. THIS DRAWING SHALL BE READ IN CONJUNCTION WITH ALL RELEVANT ARCHITECTURAL, STRUCTURAL AND OTHER SERVICES DRAWINGS.
 2. ANY DISCREPANCY NOTICED SHALL BE BROUGHT TO THE ATTENTION OF THE CONSULTANTS AND RESOLVED PRIOR TO PROCUREMENT / EXECUTION OF WORKS.
 3. ALL DIMENSIONS ARE IN MILLIMETERS AND ALL LEVELS ARE IN METERS UNLESS OTHERWISE INDICATED.
 4. FOLLOW WRITTEN DIMENSIONS ONLY, DO NOT SCALE THE DRAWING.

LIGHT FIXTURE LEGEND:		
NO	SYMBOL	DESCRIPTION
1	●	10W RECESSED MOUNTED DOWN LIGHT FIXTURE FOR MEETING ROOM
2	●	12W RECESSED MOUNTED DOWN LIGHT FIXTURE FOR TOILET AREA
3	●	20W LED RECESSED MOUNTED DOWN LIGHT
4	●	30W LED SURFACE MOUNTED DOWN LIGHT FOR CORRIDOR AREA
5	—	LED 20W SUSPENDED MOUNTED BATTEN LIGHT FIXTURE FOR CLASS ROOM
6	—	LED 20W SUSPENDED MOUNTED BATTEN LIGHT FIXTURE FOR CLASS ROOM
7	—	LED 30W RECESSED MOUNTED BATTEN LIGHT FIXTURE DIMMABLE FOR CLASS ROOM
8	—	LED 30W RECESSED MOUNTED BATTEN LIGHT FIXTURE DIMMABLE FOR CLASS ROOM
9	—	LED 30W SUSPENDED MOUNTED BATTEN LIGHT FIXTURE
10	—	LED 30W SUSPENDED MOUNTED BATTEN LIGHT FIXTURE DIMMABLE
11	—	DAY LIGHT SENSOR
12	—	OCCUPANCY SENSOR
13	—	SINGLE POLE SWITCH FOR LIGHTING
14	—	FAN REGULATOR
15	—	10W LED BULK HEAD LIGHT FIXTURE FOR
16	—	10W WALL MOUNTED MIRROR LIGHT FIXTURE FOR TOILET
17	—	120W WALL MOUNTED BLOC CEILING FAN WITH REGULATOR
18	—	30W 8 FT SUSPENDED LINEAR LIGHT FIXTURE FOR SERVICE ROOM
19	—	10W LED SURFACE MOUNTED CIRCULAR LIGHT FIXTURE FOR STAIRCASE AREA
20	—	STEP LAMP
21	—	SURFACE / WALL MOUNTED LINEAR LIGHT FIXTURE SUITABLE FOR 30W LED
22	—	BRIGHT MOUNTED LIGHT FIXTURE BRIGHT LED

REV. NO.	REVISION DESCRIPTION	DATE
R0	ISSUED FOR TENDER	11.02.2025
R1		
R2		
R3		
R4		
R5		
R6		

PROJECT

JSW ACADEMIC BLOCK - NLSIU
NEW ACADEMIC BLOCK Gnanabharathi Main Rd, Teachers Colony, Naagarabhaavi, Bengaluru, Karnataka 560072

CLIENT

NATIONAL LAW SCHOOL OF INDIA UNIVERSITY
Gnanabharathi Main Rd, Teachers Colony, Naagarabhaavi, Bengaluru, Karnataka 560072

ARCHITECT

HUNDREDHANDS
9/2, Madras Bank Road, Shanthala Nagar, Ashok Nagar, Bengaluru, Karnataka 560001

MEPF AND IBMS CONSULTANTS

LEAD CONSULTANCY & ENGINEERING SERVICES (INDIA) Pvt.Ltd.
No.27/2, 1st FLOOR, 80 FEET ROAD, INDRA NAGAR B STAGE, BENGALURU-560038, KARNATAKA.
Phone: +91 80 42980111, Web: lcsindia.org
India: Bengaluru | Mumbai | Pune | Gurgaon | Chennai | Hyderabad | Kolkata

DRAWING TITLE			
TERRACE FLOOR LIGHTING LAYOUT			
DRAWN BY	HMD	DRAWING NUMBER	SCALE
CHECKED	SSK	LCES-NLS-E-107	1:150
APPROVED	PD	REV - R0	SHEET SIZE
			A1
			DATE
			11.02.2025

DRAWING ISSUED FOR

TENDER

THIS DRAWING IS SOLE PROPERTY OF **LEAD CONSULTANCY**
USE OF THIS DRAWING FOR ANY PURPOSE OTHER THAN THAT MENTIONED TO BE DONE ONLY AFTER THEIR PRIOR APPROVAL.